

2026, Jericho Design Group, LLC. These drawings are protected by the copyright laws of the United States. These drawings or any part thereof may not be used for any purpose or reproduced in any form or by any means without the written consent of Doug Shaw.

7/29/2026 8:23:25 AM

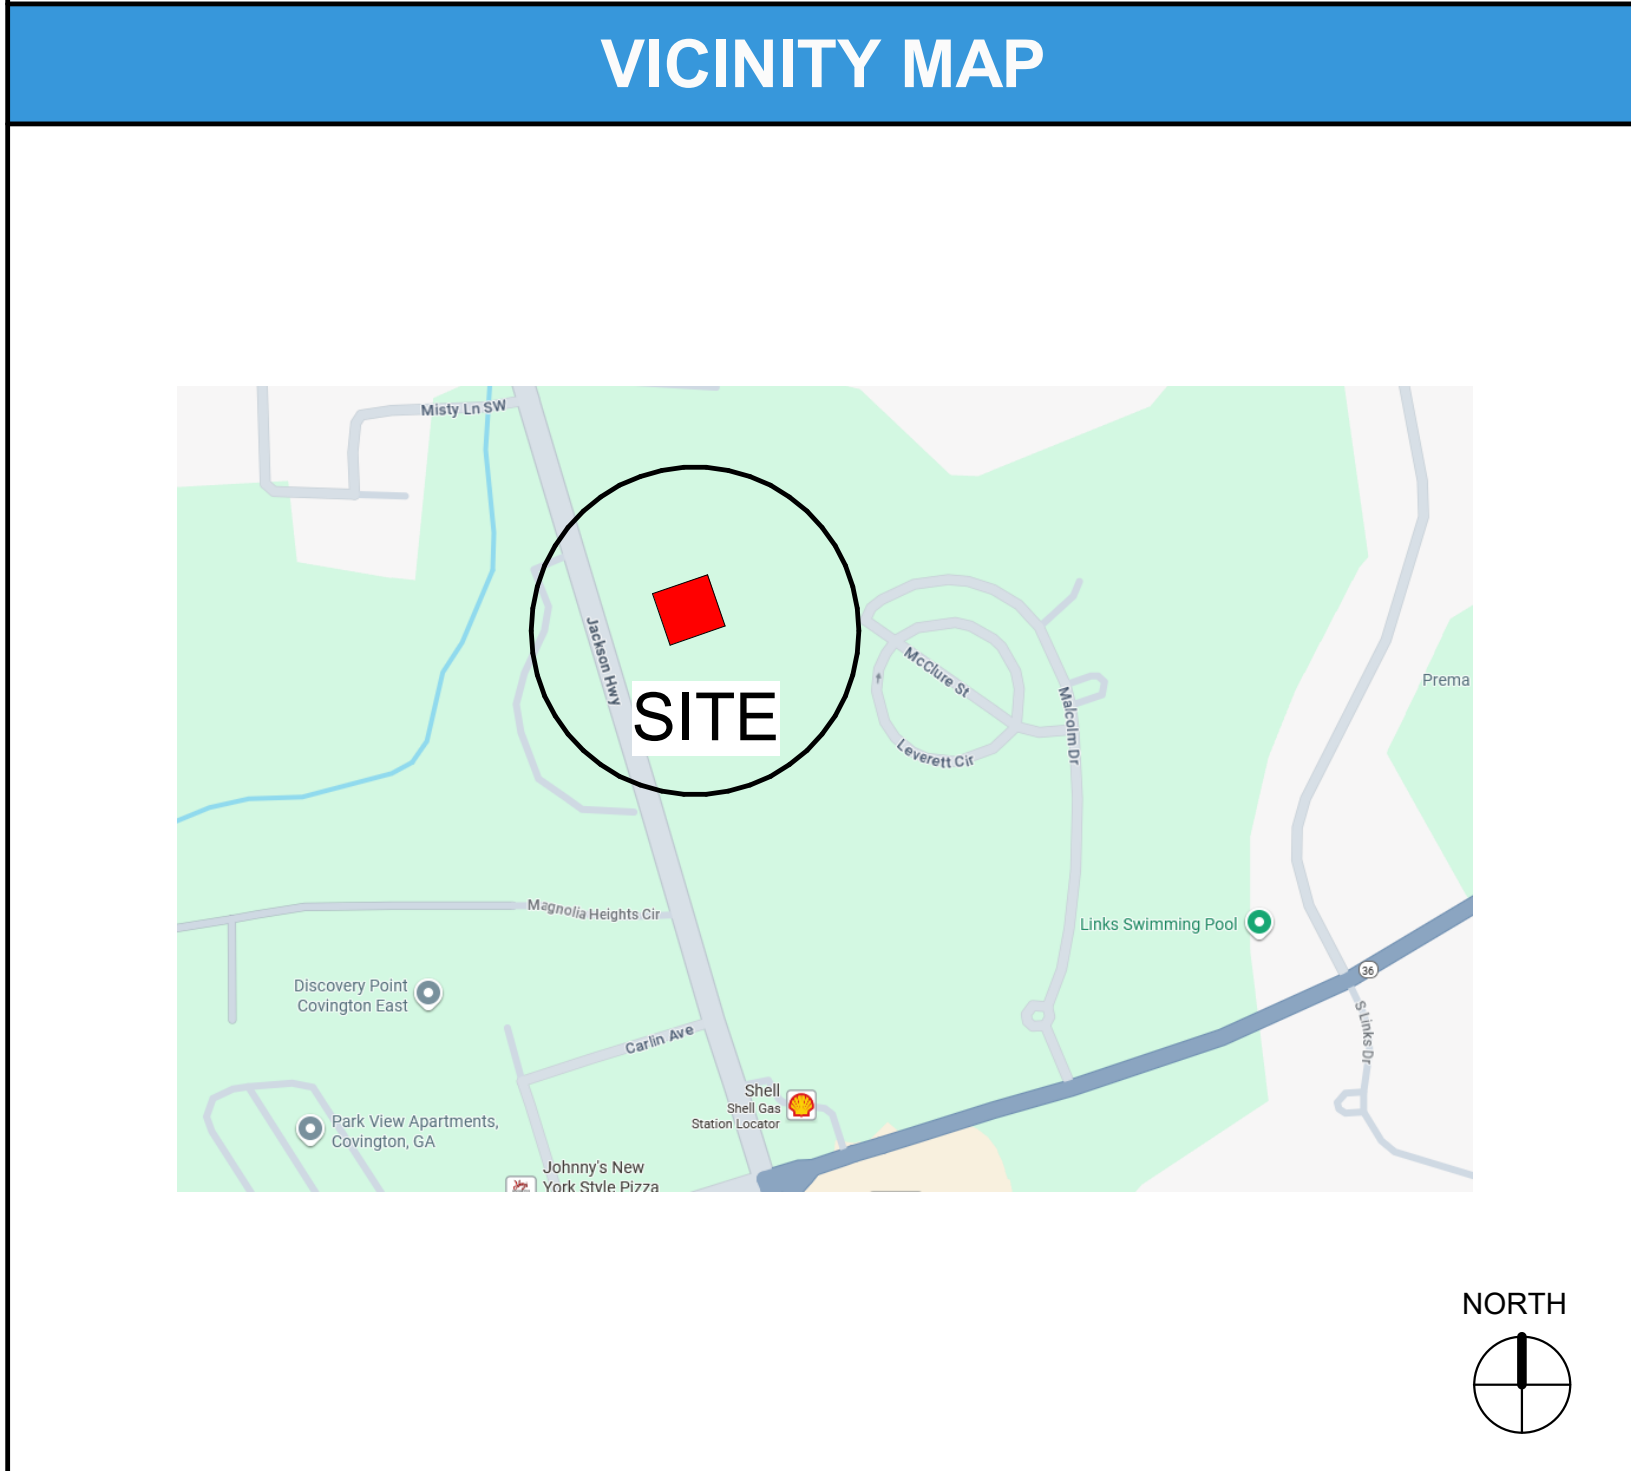
COVINGTON FIRE STATION 23

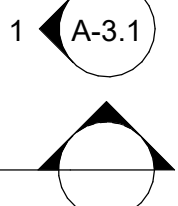
 
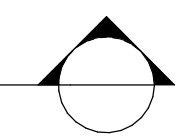
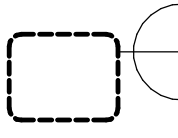
 
 
 
 
 
 
 
 
 
ISSUED FOR PERMIT



NOTE: RENDERED PERSPECTIVE IMAGE SHOWN ON SHEET CS-1.01 IS FOR GRAPHIC ILLUSTRATION ONLY.

PROJECT DIRECTORY		
OWNER:	COVINGTON FIRE DEPARTMENT 2101 PACE STREET COVINGTON, GA 30014	CHIEF JOE DOSS TEL: 770-385-2100 jdoss@cityofcovington.org
CONSTRUCTION MANAGER:	SUNBELT BUILDERS 10641 HIGHWAY 36 COVINGTON, GA 30014	MIKE MCCROREY TEL: 404-844-2939 mmccrorey@sunbeltbuilders.com
ARCHITECT:	JERICO DESIGN GROUP 208 PIRKLE FERRY RD SUITE C CUMMING, GA 30040	DOUG SHAW TEL: 678-983-5992 dshaw@jericho-design.com
CIVIL:	GEORGIA CIVIL, INC. 311 NORTH MAIN STREET UNIT C, SUITE 101 MADISON, GA 30650	JASON BROWN TEL: 770-713-9972 jason@georgiacivil.com
STRUCTURAL:	SHEAR STRUCTURAL 3411 PIERCE DRIVE SUITE 100 CHAMBLEE, GA 30341	HOLLY JEFFREYS TEL: 678-438-2879 hjeffreys@shearstructural.com
MECHANICAL & PLUMBING:	TOTAL ENGINEERS 169 NEW STREET MACON, GA 31201	KRUNAL PATEL TEL: 478-741-4632 krunalpatel@totalengineers.com
ELECTRICAL:	ELECTRICAL DESIGN CONSULTANTS, INC. 175 NEW STREET SUITE 1 MACON, GA 31201	TODD WRIGHT TEL: 478-781-1833 EXT. 104 twright@edc1973.com
ENERGY CODE INFORMATION		
R- VALUE METHOD: 2015 INTERNATIONAL ENERGY CONSERVATION CODE TABLE C402.1.3 – OPAQUE THERMAL ENVELOPE REQUIREMENTS CLIMATE ZONE #3A		
CODE REQUIREMENT		PROJECT APPLICATION
R-38	ATTIC INSULATION, ATTIC & OTHER	INSULATION @ ROOFS
R-25 CI	INSULATION ENTIRELY ABOVE ROOF DECK	INSULATION @ ROOFS
R13+R7.5 CI	INSUL. @ MTL STD FRAME WALLS	INSULATION MTL WALLS ABOVE GRADE
R13+R3.8 CI or R20	INSUL. @ WOOD FRAMED WALLS	INSULATION WD WALLS ABOVE GRADE
R-5.7 CI	INSULATION @ MASS (CONCRETE) WALLS	INSULATION @ BRICK VENEER/MASS WALLS
N/R	NOT REQUIRED AT UNHEATED SLABS	CONCRETE SLAB ON GRADE
N/R	NOT REQUIRED AT BELOW GRADE WALLS	CONCRETE FOUNDATION WALLS
N/R = NOT REQUIRED CI = CONTINUOUS INSULATION		



DRAWING INDEX		DRAWING INDEX		DRAWING INDEX		DRAWING INDEX	
SHEET NO.	SHEET NAME	SHEET NO.	SHEET NAME	SHEET NO.	SHEET NAME	SHEET NO.	SHEET NAME
01 COVER		S-2.11	ROOF FRAMING PLAN - MAIN BUILDING	A-5.72	SECTION DETAILS	10 MECHANICAL	
CS-1.01 COVER SHEET		S-2.12	ROOF FRAMING PLAN - STORAGE BUILDING	A-7.01	DOOR SCHEDULE, HARDWARE & ELEVATIONS	M0.1	MECHANICAL LEGEND, ABBREVIATIONS, AND NOTES
02 LIFE SAFETY		S-3.01	FOUNDATION DETAILS	A-7.02	WINDOW ELEVATIONS, DETAILS	M0.2	MECHANICAL SPECIFICATIONS
LS-1.01 LEVEL 1 - LIFE SAFETY		S-3.02	FOUNDATION DETAILS	A-7.51	DOOR & WINDOW DETAILS - INTERIOR	M0.3	MECHANICAL SCHEDULES
LS-1.02 LEVEL 2 - LIFE SAFETY		S-4.01	MASONRY DETAILS	A-7.52	DOOR & WINDOW DETAILS - EXTERIOR	M0.4	MECHANICAL SCHEDULES
03 GENERAL		S-5.01	STEEL FRAMING DETAILS	A-9.01	EXTERIOR 3D VIEWS	M0.5	MECHANICAL DETAILS
G-1.01 ADA REGULATORY DETAILS & DIAGRAMS		S-5.02	STEEL FRAMING DETAILS	A-9.02	EXTERIOR 3D VIEWS	M0.6	MECHANICAL DETAILS
G-2.01 PARTITION TYPES & DETAILS		S-5.03	STEEL FRAMING DETAILS	08 INTERIORS		M-1.01	LEVEL 1 - MECHANICAL PLAN
G-2.02 INTERIOR WALL DETAILS		S-5.11	STEEL FRAMING ELEVATIONS	ID-1.01	FINISH LEGEND & GENERAL NOTES	M-1.02	LEVEL 2 - MECHANICAL PLAN
G-2.10 UL RATED ASSEMBLIES		S-5.21	STEEL TRUSS ELEVATIONS	ID-2.01	LEVEL 1 - FINISH & REFERENCE PLAN	11 ELECTRICAL	
G-2.11 UL RATED ASSEMBLIES		S-5.22	STEEL TRUSS ELEVATIONS	ID-2.02	LEVEL 2 - FINISH & REFERENCE PLAN	E-001	LEGEND, NOTES, DETAILS AND FIXTURE SCHEDULE
G-3.10 SPECIFICATIONS		S-6.01	WOOD DETAILS	ID-2.51	ENLARGED FINISH PLANS & ELEVATIONS	E-002	ELECTRICAL SPECIFICATIONS
G-3.11 SPECIFICATIONS		S-6.11	WOOD TRUSS ELEVATIONS	ID-2.52	ENLARGED FINISH PLANS & ELEVATIONS	E-003	ELECTRICAL SPECIFICATIONS
G-3.12 SPECIFICATIONS		07a ARCHITECTURAL		ID-2.53	ENLARGED FINISH PLANS & ELEVATIONS	E-101	SITE PLAN - ELECTRICAL
G-3.13 SPECIFICATIONS		AS-1.01	ARCHITECTURAL SITE PLAN	ID-2.54	ENLARGED FINISH PLANS & ELEVATIONS	E-201	LEVEL 1 - LIGHTING
G-3.14 SPECIFICATIONS		AS-1.02	ARCHITECTURAL SITE DETAILS	ID-4.01	INTERIOR ELEVATIONS	E-202	LEVEL 2 - LIGHTING
G-3.15 SPECIFICATIONS		07c ARCHITECTURAL		ID-5.01	INTERIOR SECTIONS & DETAILS	E-301	LEVEL 1 - POWER & TEL/DATA SYSTEMS
G-3.16 SPECIFICATIONS		A-1.01D	LEVEL 1 - DIMENSION PLAN	ID-7.01	LEVEL 1 - SIGNAGE PLAN	E-302	LEVEL 2 - POWER & TEL/DATA SYSTEMS
G-3.17 SPECIFICATIONS		A-1.01R	LEVEL 1 - REFERENCE PLAN	ID-7.02	LEVEL 2 - SIGNAGE PLAN	E-401	LEVEL 1 - LOW VOLTAGE SYSTEMS
G-3.18 SPECIFICATIONS		A-1.02D	LEVEL 2 - DIMENSION PLAN	ID-7.03	SIGNAGE DETAILS	E-402	LEVEL 2 - LOW VOLTAGE SYSTEMS
G-3.19 SPECIFICATIONS		A-1.02R	LEVEL 2 - REFERENCE PLAN	09 PLUMBING		E-501	RISER DIAGRAMS & DETAILS
G-3.20 SPECIFICATIONS		A-1.30	EDGE OF SLAB - LEVEL 1	P0.1	PLUMBING SPECIFICATIONS	E-502	ELECTRICAL SCHEDULES
G-3.21 SPECIFICATIONS		A-1.31	EDGE OF SLAB - LEVEL 2	P0.2	FIRE PROTECTION SPECIFICATIONS	E-601	ELECTRICAL DETAILS
G-3.22 SPECIFICATIONS		A-1.51	ENLARGED PLANS	P1.1	FIRST FLOOR PLUMBING PLAN - SEWER & STORM	Grand total: 130	
G-3.23 SPECIFICATIONS		A-1.52	ENLARGED PLANS - TRAINING TOWER, STORAGE	P1.2	FIRST FLOOR PLUMBING PLAN - WATER & GAS		
G-3.24 SPECIFICATIONS		A-1.71	PLAN DETAILS	P2.1	SECOND FLOOR PLUMBING PLAN - SEWER		
G-3.25 SPECIFICATIONS		A-2.01	LEVEL 1 - REFLECTED CEILING PLAN	P2.2	SECOND FLOOR PLUMBING PLAN - WATER & GAS		
06 STRUCTURAL		A-2.02	LEVEL 2 - REFLECTED CEILING PLAN	P3.1	STORAGE BUILDING PLANS		
S-0.01 GENERAL NOTES		A-2.51	ENLARGED CEILING PLANS	P4.1	APPARATUS BAY PLUMBING PLAN - SEWER & STORM		
S-0.02 WIND LOADING DIAGRAM, LEGENDS, AND ABBREVIATIONS		A-2.52	CEILING DETAILS	P4.2	APPARATUS BAY PLUMBING PLAN - WATER & GAS		
S-0.03 LOADING PLANS - MAIN BUILDING		A-3.01	ROOF PLAN	P4.3	APPARATUS BAY TRENCH DRAIN RISER		
S-0.04 SPECIFICATIONS		A-3.51	ROOF DETAILS	P5.1	ENLARGED FIRST FLOOR PLUMBING PLAN - SEWER & STORM		
S-0.05 SPECIFICATIONS		A-4.01	EXTERIOR ELEVATIONS	P5.2	ENLARGED FIRST FLOOR PLUMBING PLAN - WATER & GAS		
S-0.06 SPECIFICATIONS		A-4.02	EXTERIOR ELEVATIONS - STORAGE & TRAINING TOWER	P6.1	FIRE STATION SEWER RISER		
S-0.07 SPECIFICATIONS		A-5.01	BUILDING SECTIONS	P6.2	FIRE STATION GAS RISER		
S-0.08 SPECIAL INSPECTIONS		A-5.51	WALL SECTIONS	P6.3	FIRE STATION WATER RISER		
S-0.09 SPECIAL INSPECTIONS		A-5.52	WALL SECTIONS				
S-1.01 FOUNDATION PLAN - MAIN BUILDING		A-5.53	WALL SECTIONS				
S-1.02 FOUNDATION PLAN - STORAGE BLDG & DRILL TOWER		A-5.54	WALL SECTIONS				
S-2.01 FLOOR FRAMING PLAN - MAIN BUILDING		A-5.55	WALL SECTIONS - STORAGE				
S-2.02 FLOOR FRAMING PLANS - DRILL TOWER							
ABBREVIATIONS		SYMBOLS		GENERAL NOTES			
@ ACT ACUSTICAL CEILING TILE	G.C. GENERAL CONTRACTOR		1 A-3.1 ELEVATION MARK		BATT INSULATION	1. THESE DRAWINGS ARE THE PROPERTY OF JERICHO DESIGN GROUP, LLC AND SHALL NOT BE REPRODUCED OR COPIED (PHYSICALLY AND/OR DIGITALLY) IN PART OR WHOLE. THEY ARE TO BE USED FOR THIS PROJECT ONLY AND ARE NOT TO BE USED ON ANY OTHER PROJECT.	9. FIELD VERIFY ALL EXISTING CONDITIONS PRIOR TO COMMENCEMENT OF ANY CONSTRUCTION ACTIVITIES. NOTIFY THE ARCHITECT OF ANY DISCREPANCIES BETWEEN FIELD CONDITIONS AND CONTRACT DOCUMENTS PRIOR TO ANY CONSTRUCTION ACTIVITY IN AREA OF CONCERN.
A F.F. ABOVE FINISHED FLOOR	GYP. BO. GYPSUM BOARD			SECTION MARK SIM - SIMILAR OH - OPPOSITE HAND			
ALUM. ALUMINUM	H.M. HOLLOW METAL		ENLARGED PLAN / DETAIL MARK		GRANULAR	3. THE CONTRACTOR IS TO NOTIFY ARCHITECT OF ANY DISCREPANCIES AFTER FULL REVIEW OF CONTRACT DOCUMENTS TO INCLUDE BUT NOT LIMITED TO ERRORS, OMISSIONS, INCONSISTENCIES, DISCREPANCIES, AND CONFLICTS WITH THE DRAWINGS/SPECIFICATIONS OR AS RELATED TO FIELD CONDITIONS. CONTRACTOR TO CONTACT ARCHITECT IMMEDIATELY TO DISCUSS A RESOLUTION.	11. THE CONTRACTOR SHALL PROVIDE ADEQUATE BRACING & SHORING FOR ALL WORK DURING THE CONSTRUCTION PERIOD.
B/ BOTTOM OF	I.B.C. INSTALLED BY CONTRACTOR			001 DOOR REFERENCE NUMBER		CONCRETE	4. DO NOT SCALE THE DRAWINGS UNDER ANY CONDITION.
BD. BOARD	J.T. JOINT		OFFICE 101 ROOM NAME & NUMBER		BRICK	5. WORK PERFORMED SHALL BE IN ACCORDANCE TO ALL FEDERAL, STATE AND LOCAL BUILDING CODE REQUIREMENTS PER INDUSTRY STANDARDS. ALL REQUIRED PERMITS AND FEES ASSOCIATED ARE TO BE THE RESPONSIBILITY OF THE CONTRACTOR NECESSARY FOR START AND COMPLETION OF THE PROJECT. COPIES OF INSPECTIONS AND PERMITS SHALL BE FURNISHED TO OWNER AT REQUEST AND/OR AT PROJECT CLOSEOUT.	13. PROVIDE EXPANSION AND CONTROL JOINTS IN ALL WORK AS PER PRODUCT MANUFACTURER'S STANDARDS, OR SPECIFICATIONS, UNLESS NOTED OTHERWISE.
BR. BRICK	L.L. LANDLORD		A COLUMN AND GRID NUMBER		STEEL, IRON	6. CONTRACTOR TO TAKE PRECAUTIONS IN PROTECTING THE WORK DURING CONSTRUCTION. ANY DAMAGE TO BE RESTORED TO ORIGINAL CONSTRUCTION BY THE CONTRACTOR. PATCH AND REPAIR ALL ITEMS DAMAGED OR ALTERED DURING CONSTRUCTION BY THE CONTRACTOR. ALL PATCHES SHALL BLEND WITH ADJACENT MATERIAL, COLOR, FINISH, AND TEXTURE. ALL EXISTING WORK FURNISHINGS, EQUIPMENT OR MATERIAL TO REMAIN THAT ARE DAMAGED BY THE CONTRACTOR'S OPERATION SHALL BE REPAIRED BY THE CONTRACTOR AT NO ADDITIONAL COST TO THE OWNER.	14. ALL DIMENSIONS ARE WITNESSED TO THE OUTSIDE FACE OF MASONRY, FACE OF STUD, CENTER OF COLUMN, TOP OF STRUCTURAL CONCRETE SLAB OR ROUGH WINDOW OPENING UNLESS NOTED OTHERWISE.
BRG. BEARING	MFR. MANUFACTURER		SF-1 WINDOW REFERENCE NUMBER		WOOD	7. REQUESTS FOR SUBSTITUTIONS MUST BE SUBMITTED IN WRITING TO THE ARCHITECT FOR CONSIDERATION ONLY IF IMPACT TO SCHEDULE, COST, CHANGE OR QUALITY OF PRODUCT. ACCEPTANCE BY ARCHITECT DOES NOT IDENTIFY PRODUCT TO BE OF BETTER QUALITY THAN SPECIFIED PRODUCT.	15. NOTES APPEAR ON VARIOUS SHEETS FOR DIFFERENT SYSTEMS AND MATERIALS. SHEETS ARE TO BE REVIEWED AND NOTES ON INDIVIDUAL SHEETS SHALL BE APPLIED TO RELATED DRAWINGS AND DETAILS.
CFMF COLD FORMED METAL FRAMING	MAT. MATERIAL		SOLID GROUT		MORTAR NET	8. SEAL ALL EXTERIOR PENETRATIONS AND VOIDS ON EXTERIOR BUILDING ENVELOPE.	16. INTERIOR PARTITION MOVEMENT CONTROL - VERTICAL CONTROL JOINTS FOR ANY WALL LENGTH ARE TO OCCUR AT NOT MORE THAN 30'-0" O.C. IN THE HORIZONTAL DIRECTION, UNLESS NOTED OTHERWISE.
CL. CENTER LINE	MAX. MAXIMUM		WOOD DIMENSIONAL		PLASTER, GYPSUM WALLBOARD		17. THE CONTRACTOR IS RESPONSIBLE FOR THE COORDINATION OF ALL PARTS OF THE WORK SO THAT NO WORK SHALL BE LEFT IN AN UNFINISHED OR INCOMPLETE CONDITION.
CLR. CLEAR	MECH. MECHANICAL		SHEATHING		RIGID INSULATION		
C.J. CONTROL JOINT	MIN. MINIMUM						
CMU. CONCRETE MASONRY UNIT	MTL. METAL						
COORD. COORDINATE	NC. NON-COMBUSTIBLE						
COL. COLUMN	N.I.C. NOT IN CONTRACT						
CONC. CONCRETE	N.T.E. NOT TO EXCEED						
CONT. CONTINUOUS	N.T.S. NOT TO SCALE						
D. DIAMETER	O.D. OVERFLOW DRAIN						
DWG. DRAWING	O.PP. OPPOSITE						
D.S. DOWN SPOUT	PL. PLASTIC LAMINATE						
EA. EACH	PLYWD. PLYWOOD						
ELEV. ELEVATION	PR. PAIR						
ELEC. ELECTRIC	P.T. PRESSURE TREATED						
E.S. EQUIPMENT SUPPLIER	O.C. ON CENTER						
EXP. EXPANSION	R.D. ROOF DRAIN						
EXT. EXTERIOR	S.B.O. SUPPLIED BY OWNER						
E.W.C. ELECTRIC WATER COOLER	SCHD. SCHEDULE						
F.D. FLOOR DRAIN	SIM. SIMILAR						
FEC FIRE EXTINGUISHER CABINET	STL. STEEL						
FF. FINISHED FLOOR	STRUCT. STRUCTURAL						
FL. FLOOR	T. TOP OF						
F.O. FACE OF	T&G TONGUE AND GROOVE						
F.F.F. FACE OF FINISH	TYP. TYPICAL						
F.O.M. FACE OF MASONRY	U.N.O. UNLESS NOTED OTHERWISE						
FOIC FURNISHED BY OWNER INSTALLED BY CONTRACTOR	VERT. VERTICAL						
F.R. FIRE RETARDANT	VWC VINYL WALL COVERING						
FRAN. FRANCHISEE	W. WIDE						
FRP FIBERGLASS REINFORCED POLYESTER	W/ WITH						
	WD. WOOD						
	W.W.F. WELDED WIRE FABRIC						

</