



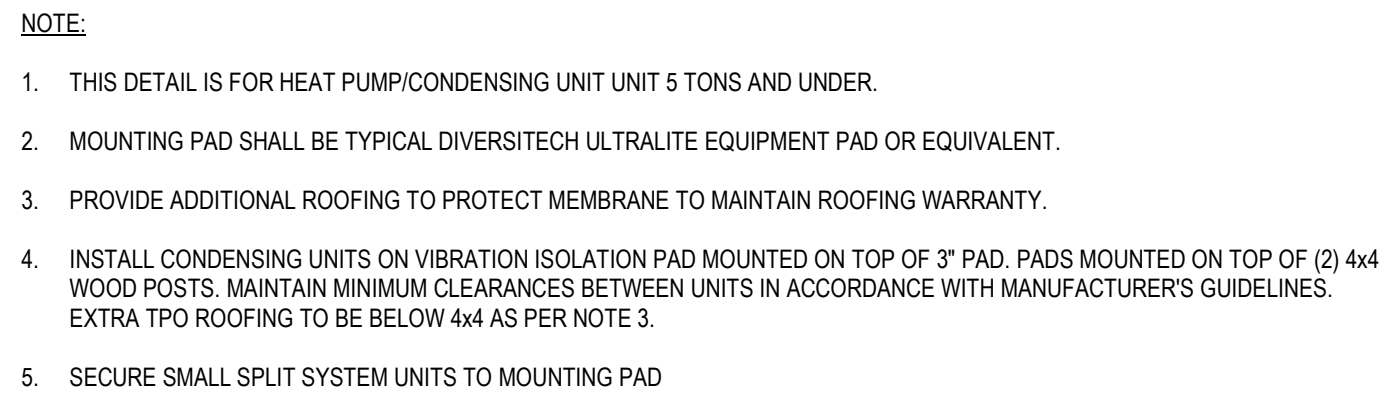


1 ROOF MOUNTED CONDENSING DETAIL
M0.7 NOT TO SCALE




2 ROOF CURB CAP FOR PIPING
M0.7 NO SCALE

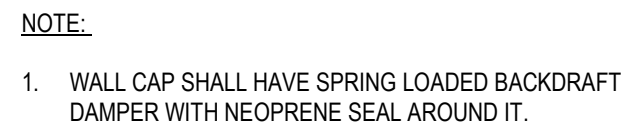

3 CEILING EXHAUST FAN WITH SIDEWALL DISCHARGE: DETAIL
MO.7 NOT TO SCALE

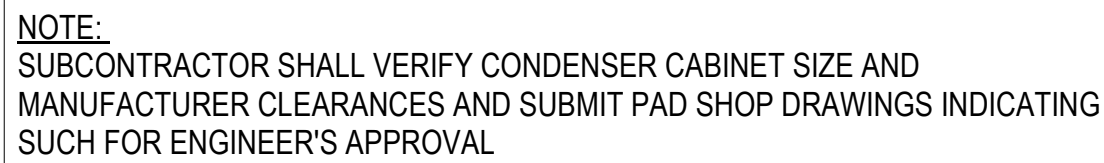


4 CONDENSER SPACING DETAIL
M0.7 NOT TO SCALE

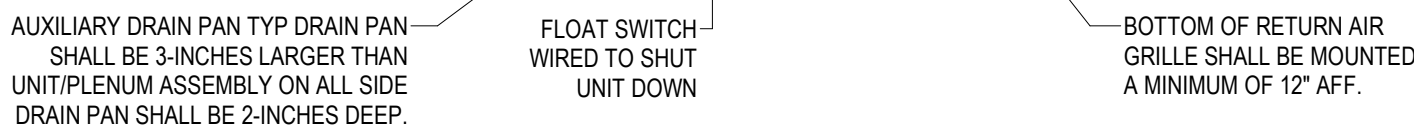


5 VERTICAL AIR HANDLER DETAIL: AH-4
M0.7 NOT TO SCALE




6 VENTILATOR ON SLOPED ROOF DETAIL
M0.7 NO SCALE

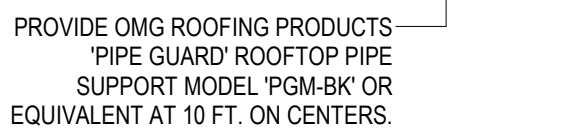


7 CONDENSATE DRAIN FOR ROOF TOP
M0.7 NO SCALE

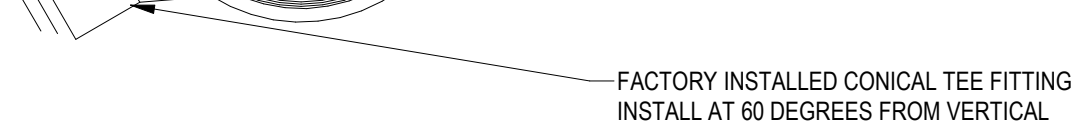

8 DUCT SUPPORT IN EXPOSED AREAS
M0.7 NOT TO SCALE

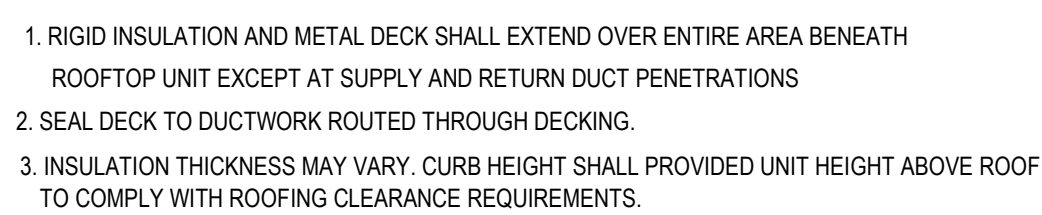

 9 ROOFTOP CURB INSTALLATION DETAIL
M0.7 NO SCALE



FIRE STATION #23

City of Covington

HIGHWAY 36
COVINGTON, GA 30014

[illegible]

Drawn By JSW	Checked By JMK
Date 07/22/2026	Job No. 25-109

Sheet Title
MECHANICAL DETAILS

Sheet No.

M0.7

RELEASED FOR CONSTRUCTION