

 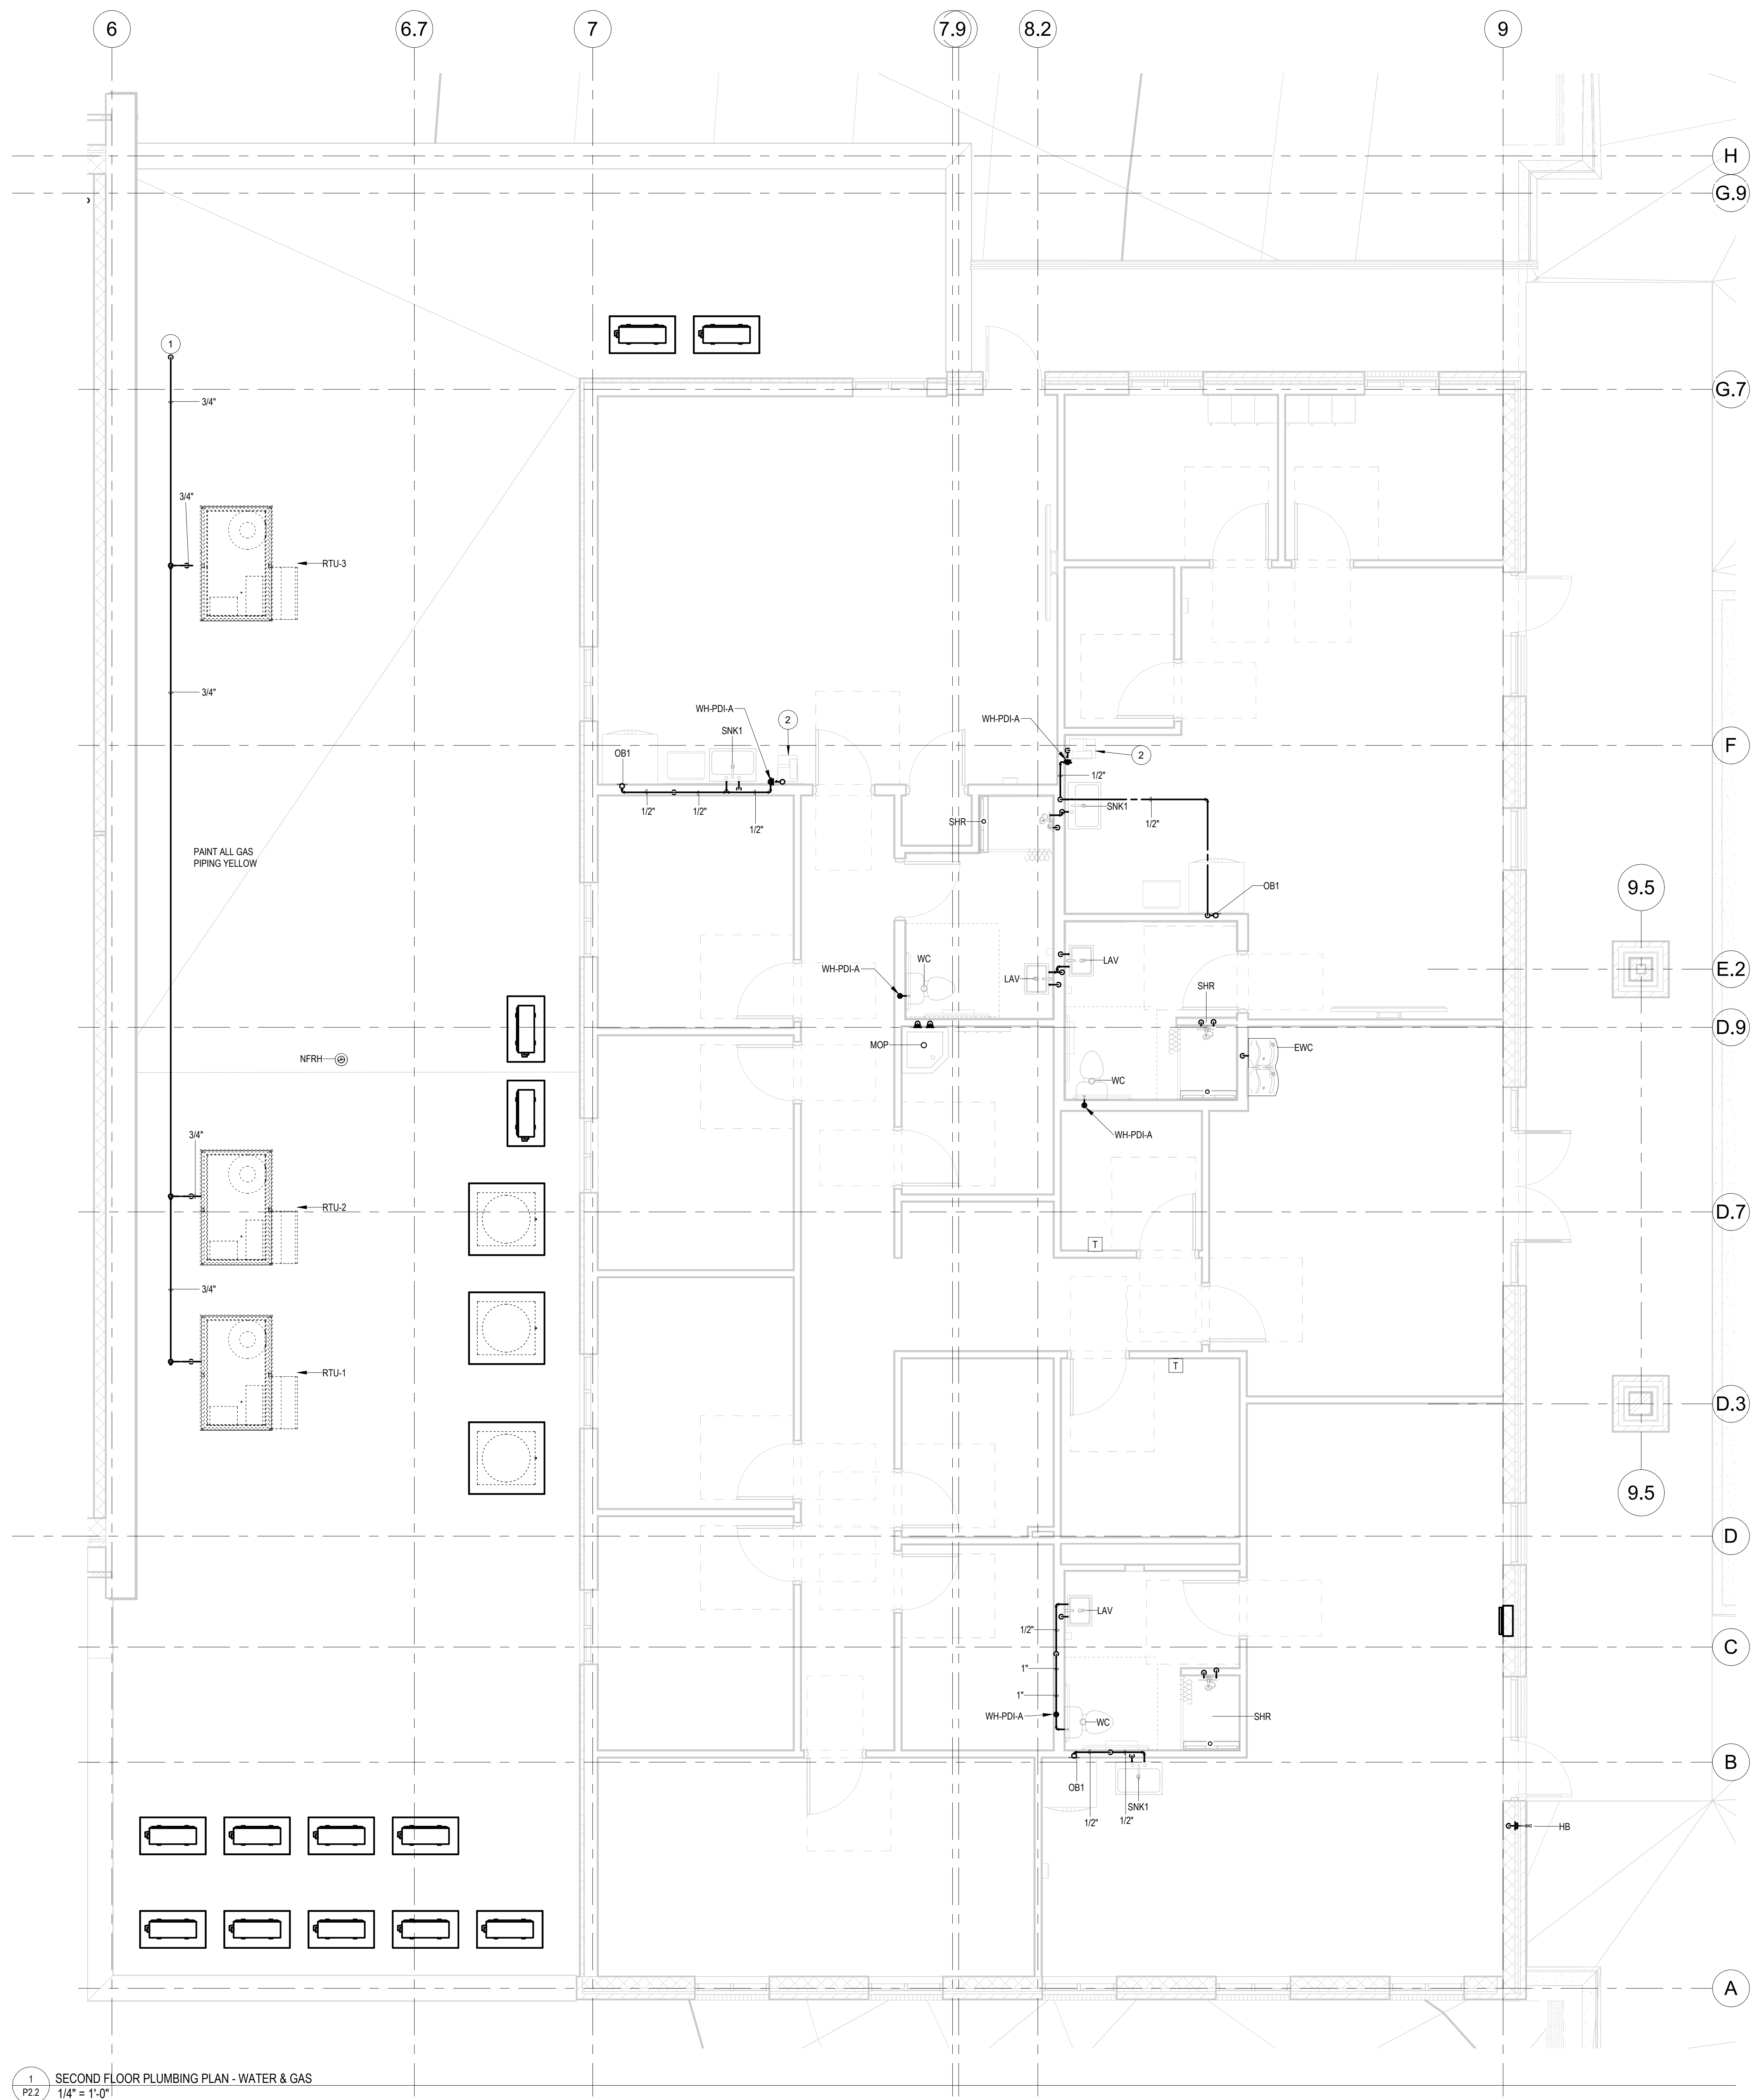


7/28/2026 1:09:04 PM

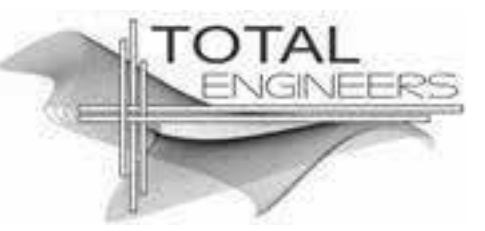

KEYED NOTES P2.2	
NOTE NUMBER	NOTE TEXT
1	3/4" 2.0 PSI GAS UP FROM FIRST FLOOR.
2	ACCESSIBLE SHUTOFF VALVE, WATER HAMMER ARRESTOR PDI-A, AND ASSE 1024 BACKFLOW PREVENTER (BFP). PROVIDE CONNECTION TO COFFEE MAKER. VERIFY FINAL CONNECTION SIZE AND LOCATION WITH EQUIPMENT MANUFACTURER.



FIRE STATION #23

City of Covington

COVINGTON, GA 30014

PRINT RECORD

[illegible]

Drawn By _____ Checked By _____
 Author _____ Checker _____

Date	Job No.
07/22/2026	25-109

Sheet Title

SECOND FLOOR PLUMBING PLAN - WATER & GAS

Sheet No.

P2.2

RELEASED FOR CONSTRUCTION