



GENERAL NOTES


REFER TO PROJECT MANUAL FOR FURTHER REQUIREMENTS

1. THE SCOPE OF WORK CONSISTS OF THE RENOVATION AND RE-PURPOSING OF THE COLLINS P. LEE COMMUNITY CENTER INTO THE COLLINS P. LEE MEMORIAL LIBRARY. THE LIMITS OF CONSTRUCTION / DISTURBED AREA WILL BE CONFINED TO THE IMMEDIATE AREA AROUND THE BUILDING. THE EXISTING SITE PLAN IS SHOWN FOR REFERENCE ONLY - HARRISBURG PARK SHALL REMAIN OPEN AND FULLY OPERATIONAL THROUGHOUT CONSTRUCTION.
2. THE CONTRACTOR IS SOLELY RESPONSIBLE FOR PROVIDING ALL SAFETY MEASURES REQUIRED TO PROTECT THE GENERAL PUBLIC FROM DEMOLITION AND CONSTRUCTION WORK FOR THE DURATION OF THE PROJECT.
3. SPOT ELEVATIONS ARE TO FINISHED FLOOR, UNLESS OTHERWISE NOTED.
4. DIMENSIONS ON PLAN MAY DIFFER FROM ACTUAL FIELD CONDITIONS. CONTRACTOR SHALL VERIFY DIMENSIONS OF ALL EXISTING CONDITIONS PRIOR TO CONSTRUCTION OR FABRICATION.

SHEET SPECIFIC NOTES

1. ALL NEW EXTERIOR CONCRETE TO HAVE A LIGHT BROOM FINISH WITH ROCK SALT FINISH.
2. CONTRACTOR TO LOCATE ALL EXISTING UTILITIES AND RELOCATE AS REQUIRED TO NOT INTERFERE WITH NEW CONSTRUCTION.

ARCHITECT
 Cas Architecture
 183 N Perry St
 Lawrenceville, GA
 30046
 404 806 0556
 www.casarc.com

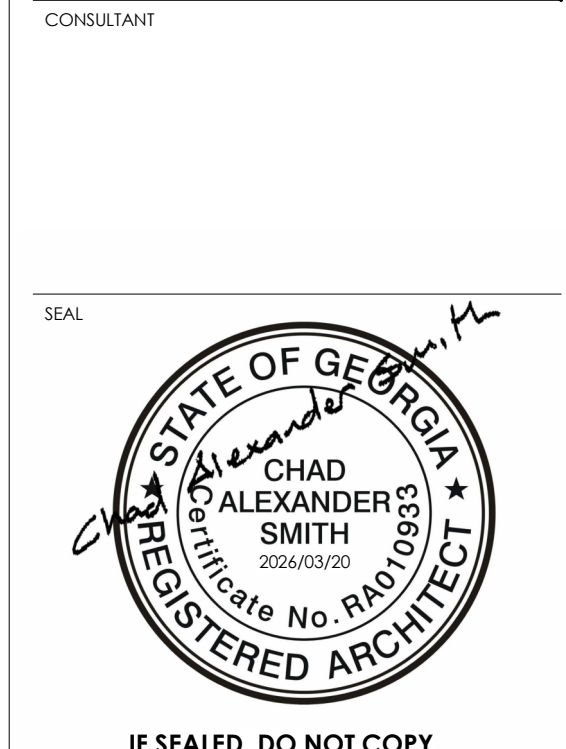

IF SEALED, DO NOT COPY

COLLINS P. LEE MEMORIAL LIBRARY
 237 HARRISBURG ROAD SW, MILLEDGEVILLE, GA 31061

COPYRIGHT © 2024 CAS ARCHITECTURE, P.C. ALL RIGHTS RESERVED. THE DOCUMENT AND ANY REPRODUCTIONS IN WHOLE OR IN PART, ARE INSTRUMENTS OF SERVICE AND ARE THE SOLE PROPERTY AND COPYRIGHT OF CAS ARCHITECTURE, P.C. AND MAY NOT BE REPRODUCED, PUBLISHED, USED OR COPIED IN ANY MANNER WITHOUT WRITTEN PERMISSION FROM CAS ARCHITECTURE, P.C. THESE DOCUMENTS HAVE BEEN PREPARED SPECIFICALLY FOR THIS PROJECT. THEY ARE NOT SUITABLE FOR USE ON OTHER PROJECTS OR IN OTHER LOCATIONS.

THIS DOCUMENT WAS CREATED ELECTRONICALLY. THIS MEDIA SHOULD NOT BE CONSIDERED A CERTIFIED DOCUMENT UNLESS IT HAS BEEN PROPERLY SEALED AND ORIGINALLY SIGNED BY A REGISTERED ARCHITECT OF CAS ARCHITECTURE, P.C.

THESE PLANS ARE COMPLEMENTARY. THEREFORE THE CONTRACTOR SHALL SEE THE ARCHITECTURAL, STRUCTURAL, MECHANICAL, PLUMBING, AND ELECTRICAL PLANS AND SPECIFICATIONS, WHEN REQUIRED BY ANY ONE, SHALL BE BINDING AS REQUIRED BY ALL THE INTENTIONS OF THE DOCUMENTS BEING USED. ALL LABOR, MATERIALS, EQUIPMENT AND OTHER ITEMS NECESSARY FOR THE PROPER EXECUTION AND COMPLETION OF THE WORK, THE CONTRACTOR SHALL BE RESPONSIBLE FOR THE COORDINATION OF THE WORK OF ALL TRADES.

NO.	DATE	ISSUANCE / REVISIONS

SHEET TITLE
 ARCHITECTURAL SITE PLAN

SHEET NUMBER

A120

PROJECT 25114 DATE 2026/03/20 DRAWN CAS FILE 25114_LEE MEMORIAL LIBRARY RV124

1 ARCHITECTURAL SITE PLAN
 A120 1" = 10'-0"

