



AREA CALCULATION NOTES

KEY SPACES SQUARE FOOTAGE SUMMARY

ADULTS/READING ROOM	1,462 S.F.
CHILDREN/READING ROOM	586 S.F.
PROGRAM/MEETING ROOM	376 S.F.
STUDY ROOMS	112 S.F.
HELP DESK	104 S.F.
WORKROOM	190 S.F.
BREAKROOM	105 S.F.
RESTROOMS	112 S.F.
ELECTRICAL ROOM	30 S.F.
STORAGE	105 S.F.
JANITOR	34 S.F.
CORRIDOR	39 S.F.
TOTAL NET SQUARE FOOTAGE	3,255 S.F.


EXISTING GROSS SQUARE FOOTAGE RENOVATION: 3,586 S.F.

GRAPHIC LEGEND

- EXISTING CONSTRUCTION TO REMAIN
- NEW WALLS, REFER TO G140 FOR WALL TYPES
- EXISTING COLUMN GRID
- COMMON SPACE/ ADULT GENERAL COLLECTION
- CHILDREN COLLECTION
- YOUNG ADULT SERVICES
- PROGRAM
- OFFICE/ STAFF WORKSPACE
- STUDY ROOMS
- RESTROOMS
- CIRCULATION SPACE
- UTILITARIAN SPACE

SHELVING COUNT

- ADULT SHELVES**
 [66IN. HEIGHT/ 3'-0" WIDTH / 5 ROWS PER UNIT]
 SINGLE SIDED SHELVES (10 UNITS) = 141 LF
 DOUBLE SIDED SHELVES (12 UNITS) = 340 LF
- CHILDREN SHELVES**
 [42IN. HEIGHT/ 3'-0" WIDTH / 3 ROWS PER UNIT]
 SINGLE SIDED SHELVES (9 UNITS) = 76.5 LF
 DOUBLE SIDED SHELVES (6 UNITS) = 102 LF
 BUILT-IN SHELVES = 74 LF

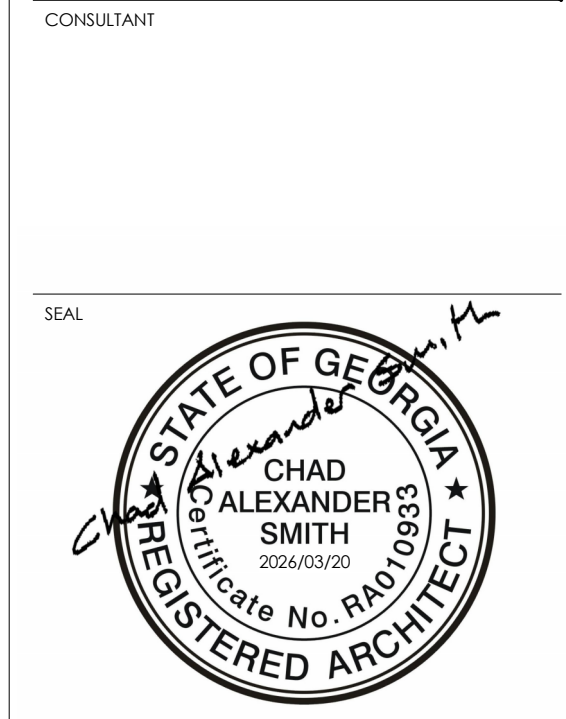

IF SEALED, DO NOT COPY

COLLINS P. LEE MEMORIAL LIBRARY
 237 HARRISBURG ROAD SW, MILLEDGEVILLE, GA 31061

COPYRIGHT © 2024 CAS ARCHITECTURE, P.C. ALL RIGHTS RESERVED. THIS DOCUMENT AND ANY REPRODUCTIONS IN WHOLE OR IN PART, ARE INSTRUMENTS OF SERVICE AND ARE THE SOLE PROPERTY AND COPYRIGHT OF CAS ARCHITECTURE, P.C. AND MAY NOT BE REPRODUCED, PUBLISHED, USED OR COPIED IN ANY MANNER WITHOUT WRITTEN PERMISSION FROM CAS ARCHITECTURE, P.C. THESE DOCUMENTS HAVE BEEN PREPARED SPECIFICALLY FOR THIS PROJECT. THEY ARE NOT SUITABLE FOR USE ON OTHER PROJECTS OR IN OTHER LOCATIONS.

THIS DOCUMENT WAS CREATED ELECTRONICALLY. THIS MEDIA SHOULD NOT BE CONSIDERED A CERTIFIED DOCUMENT UNLESS IT HAS BEEN PROPERLY SEALED AND ORIGINALLY SIGNED BY A REGISTERED ARCHITECT OF GA ARCHITECTURE, P.C.

THESE PLANS ARE COMPLEMENTARY. THEREFORE THE CONTRACTOR SHALL SEE THE ARCHITECTURAL, STRUCTURAL, MECHANICAL, PLUMBING, AND ELECTRICAL PLANS AND SPECIFICATIONS, WHEN REQUIRED BY ANY ONE SHALL BE BINDING AS REQUIRED BY ALL. THE ATTENTION OF THE CONTRACTOR IS TO BE GIVEN TO ALL MATERIALS, EQUIPMENT AND OTHER ITEMS NECESSARY FOR THE PROPER EXECUTION AND COMPLETION OF THE WORK. THE CONTRACTOR SHALL BE RESPONSIBLE FOR THE COORDINATION OF THE WORK OF ALL TRADES.

NO.	DATE	ISSUANCE / REVISIONS

SHEET TITLE
 AREA CALCULATION FLOOR PLAN

SHEET NUMBER

A201

PROJECT DATE DRAWN
 25114 2026/03/20 CAS

FILE 25114_LEE MEMORIAL LIBRARY RV124

1
 A201
AREA CALCULATION FLOOR PLAN
 1/4" = 1'-0"

