


1 PROGRAM / MEETING ROOM 111 DIMENSION PLAN
 A231 3/8" = 1'-0"

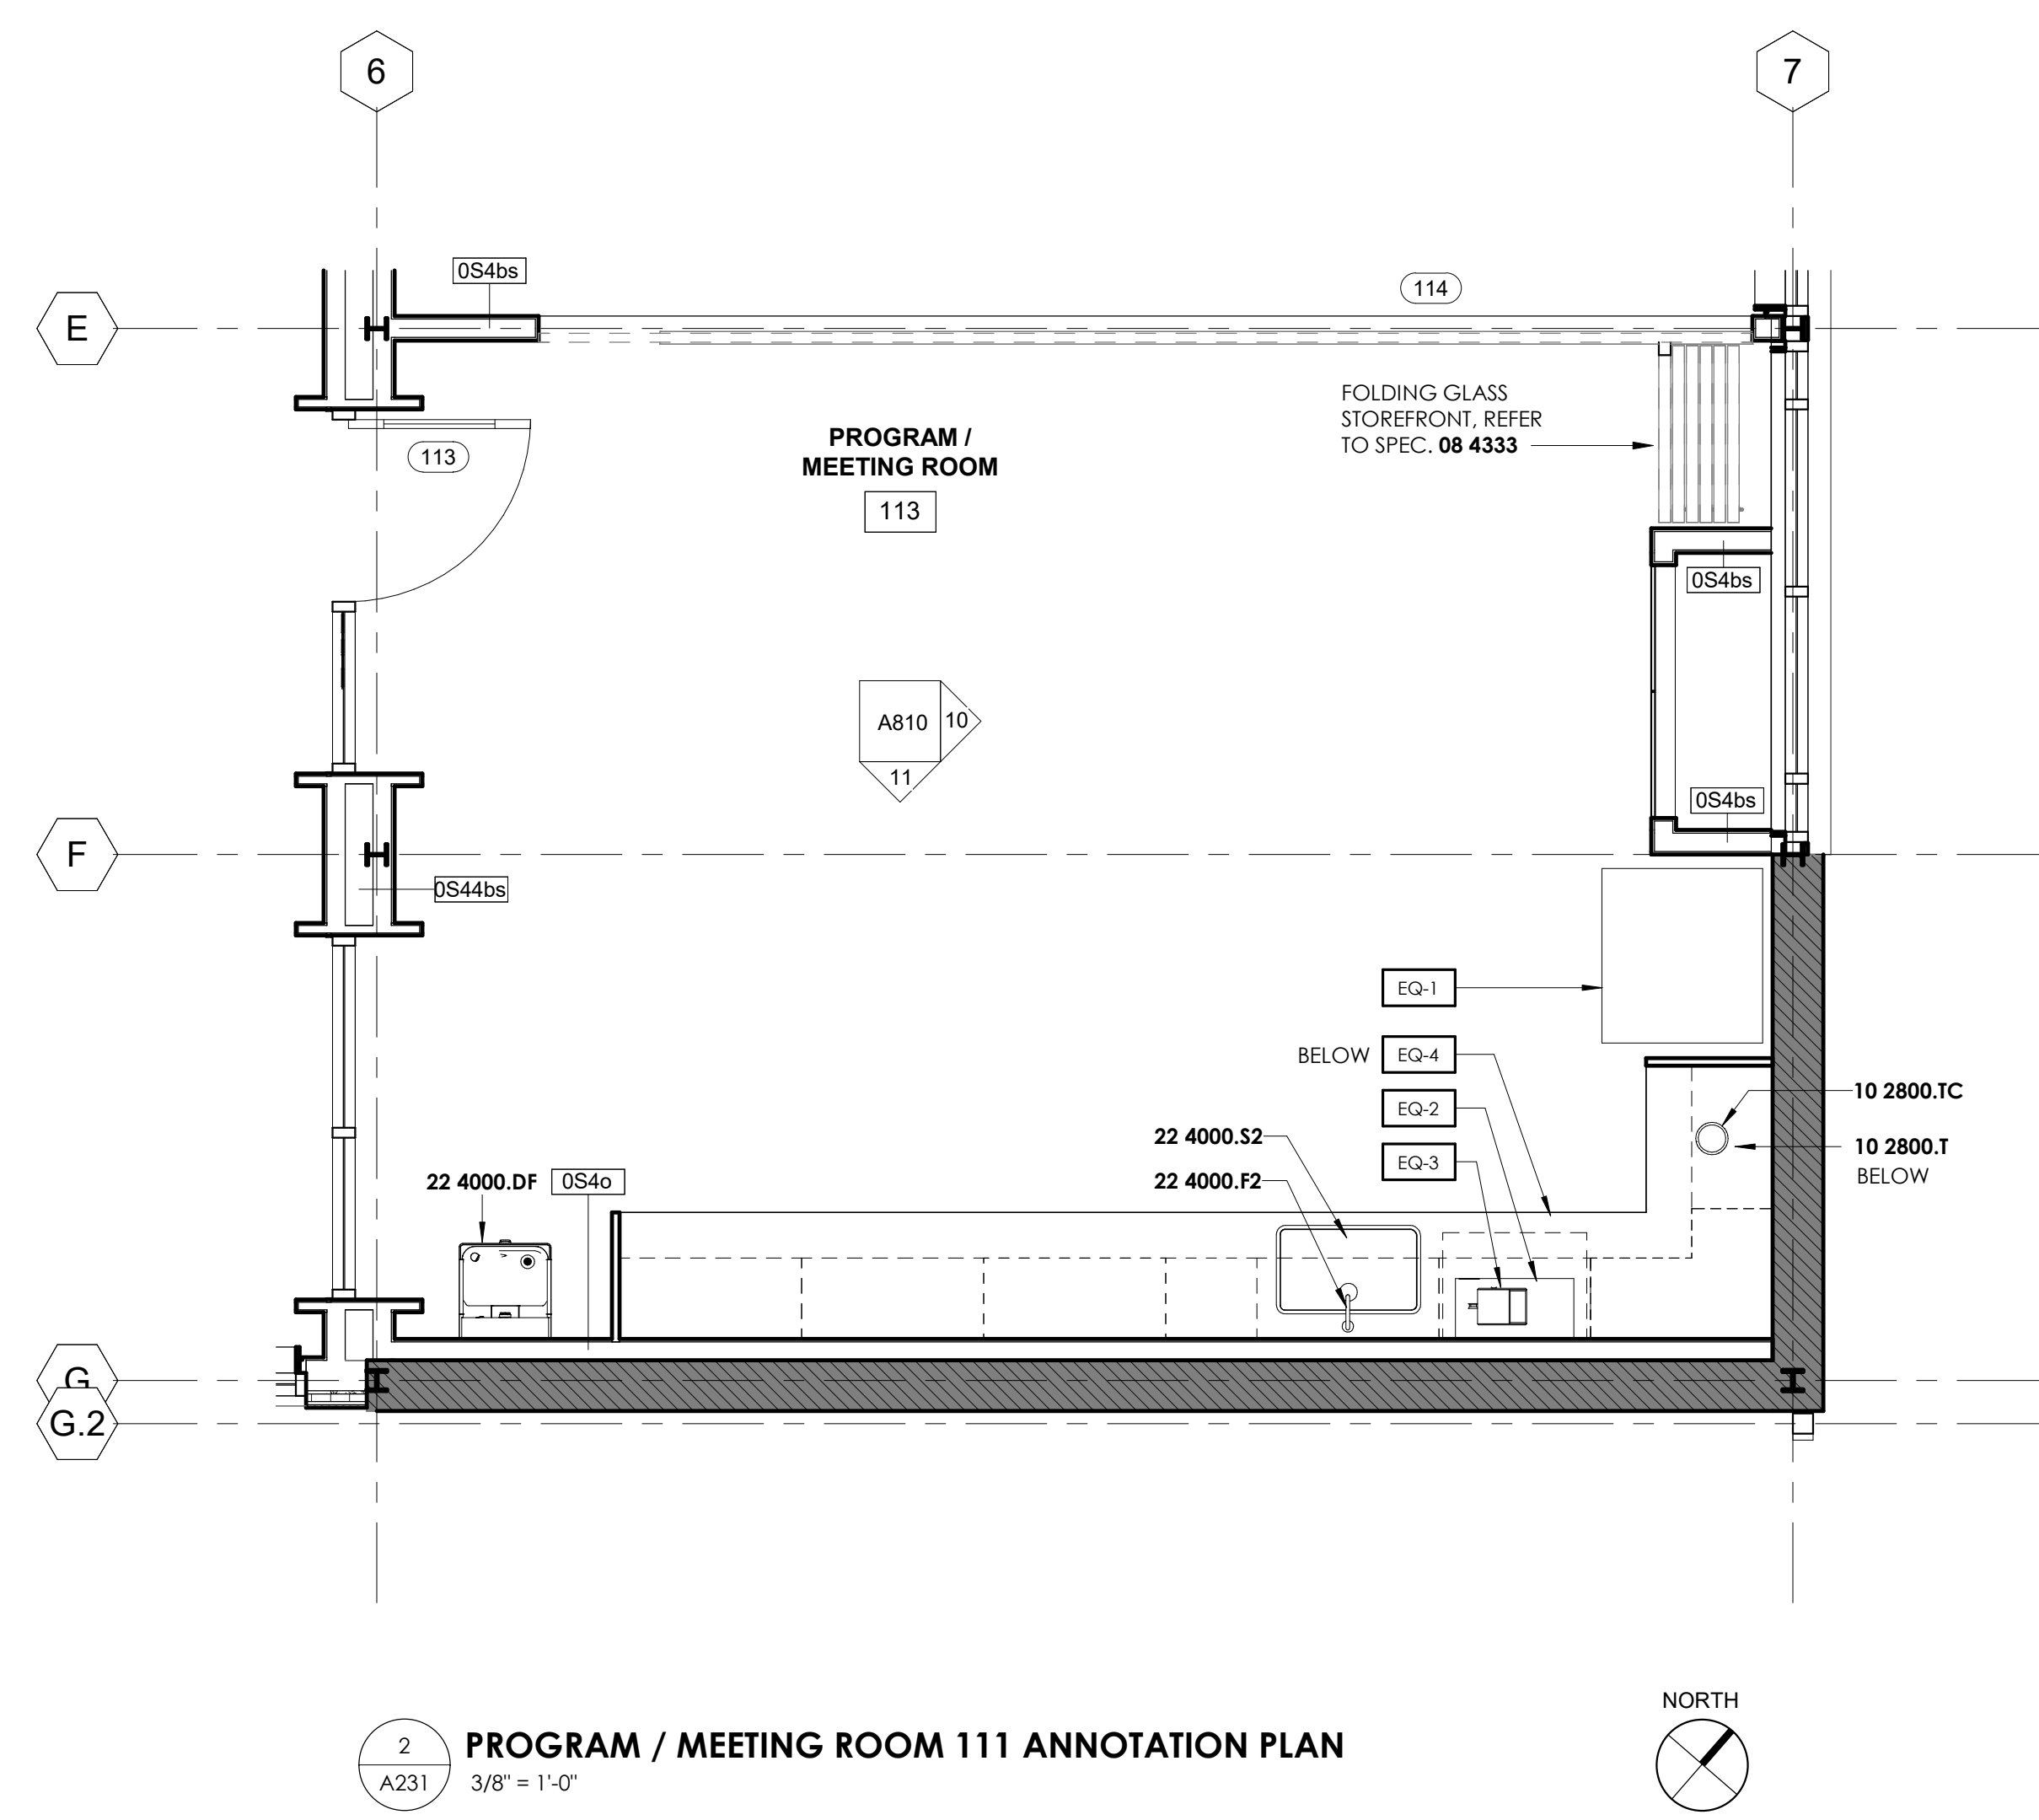

2 PROGRAM / MEETING ROOM 111 ANNOTATION PLAN
 A231 3/8" = 1'-0"

GRAPHIC LEGEND

- EXISTING CONSTRUCTION TO REMAIN
- NEW WALLS, REFER TO G140 FOR WALL TYPES
- EXISTING COLUMN GRID

1. REFER TO I DRAWINGS FOR ADDITIONAL DETAILS AND FINISH SELECTIONS.
2. DISCUSS WITH ARCHITECT WHERE TO START TILE PATTERN PRIOR TO INSTALLATION.
3. WALL TILES MAY NEED TO BE CUT TO CREATE WALL PATTERN. USE 3/8" WIDE SAW BLADE TO CREATE A 3/8" WIDE JOINT. ALL OTHER JOINTS BETWEEN TILE TO BE 3/8" CONSISTENT JOINT WIDTH EVERYWHERE.
4. GENERAL CONTRACTOR TO REVIEW PLUMBING DRAWINGS IN COMPARISON TO ARCHITECT'S FIXTURE SCHEDULE. ANY DISCREPANCIES SHOULD BE ADDRESSED BY CONTRACTOR PRIOR TO PURCHASING OF FIXTURES.
5. GENERAL CONTRACTOR TO REVIEW ELECTRIC DRAWINGS IN COMPARISON TO ARCHITECT'S FIXTURE SCHEDULE. ANY DISCREPANCIES SHOULD BE ADDRESSED BY CONTRACTOR PRIOR TO PURCHASING OF FIXTURES.
6. REFER TO G130 FOR STANDARD REACH RANGES, MOUNTING HEIGHTS AND OTHER REQUIREMENTS.
7. PROVIDE WHITE SNAP ON DRAIN PIPE PROTECTION UNDER SINKS.
8. REFER TO PLUMBING FIXTURE SCHEDULE AND EQUIPMENT SCHEDULE ON A230.

FIXTURE SCHEDULE

ITEM	PRODUCT	PRODUCT DESCRIPTION
10 2800.BC	BOBRICK, KOLA, KARE KB310-SWM, HORIZONTAL SURFACE MOUNTED BABY STATION, STAINLESS STEEL FINISH, PROVIDE BLOCKING.	
10 2800.GB	BOBRICK, B-5897, 1 1/4" DIA. GRAB BAR, STAINLESS WITH PEENED GRIPPING, NO. 4 FINISH (SATIN BRUSHED)	
10 2800.HD	DISON W-BLADE HAND DRYER, AB12-N-LV	
10 2800.M	KOHLER, K-30437, MIRROR WITH POLISHED CHROME FRAME	
10 2800.MH	BOBRICK, B-223 X 24, MOP AND BROOM HOLDER, SATIN FINISH STAINLESS STEEL FINISH	
10 2800.RH	BOBRICK, B-76717, SINGLE ROBE HOOK, BRIGHT-POLISHED STAINLESS STEEL FINISH	
10 2800.SP	BOBRICK, B-2013, AUTOMATIC WALL-MOUNTED FOAM SOAP DISPENSER, SATIN-FINISH STAINLESS STEEL	
10 2800.T	BOBRICK, B-2260, SATING STAINLESS STEEL FINISH	
10 2800.T2	GLOBAL INDUSTRIAL, W8261749BK, PLASTIC, BLACK.	
10 2800.TC	BOBRICK, B-532, SATIN STAINLESS STEEL FINISH	
10 2800.TP	BOBRICK, B-4288, SATIN STAINLESS STEEL FINISH	
10 2800.US	AMERICAN SPECIALTIES 0692-618	
22 4000.F1	REFER TO PLUMBING DRAWINGS; SLOAN, EBF-415 OPTIMA BATTERY POWER, DECK-MOUNTED LOW BODY FAUCET, CHROME FINISH.	
22 4000.F2	REFER TO PLUMBING DRAWINGS; SLOAN, EBF-750 OPTIMA BATTERY POWER, DECK-MOUNTED LOW BODY FAUCET, CHROME FINISH.	
22 4000.JS	STERN WILLIAMS, HL-1800 RECEPTOR W/MOEN 8124 VACUUM BREAK FAUCET, REFER TO PLUMBING DRAWINGS AND SPECIFICATIONS.	
22 4000.S1	REFER TO PLUMBING DRAWINGS; SOLID SURFACE SINK CORIAN GLACIER WHITE 8252 TO BE INTEGRAL WITH SS-1 COUNTERTOP (SEE FINISH LEGEND)	
22 4000.S2	REFER TO PLUMBING DRAWINGS; SOLID SURFACE SINK CORIAN GLACIER WHITE 3610 TO BE INTEGRAL WITH SS-1 COUNTERTOP (SEE FINISH LEGEND) AND ADA COMPLIANT	
22 4000.WC	REFER TO PLUMBING DRAWINGS; TOTO, CT725CJUF, HIGH EFFICIENCY TOILET WITH TOP SPUD INLET, FINISH: #01 COTTON - TOILET SEAT TO BE 19" A.F.F. (TYPICAL)	
22 4713.DF	ELKAY VRCGRNBWSK, SINGLE DRINKING FOUNTAIN WITH BOTTLE FILLER	

- *NOTE**
1. GENERAL CONTRACTOR TO REVIEW PLUMBING DRAWINGS IN COMPARISON TO ARCHITECT'S FIXTURE SCHEDULE. ANY DISCREPANCIES SHOULD BE ADDRESSED BY CONTRACTOR PRIOR TO PURCHASING OF FIXTURES.
 2. GENERAL CONTRACTOR TO REVIEW ELECTRIC DRAWINGS IN COMPARISON TO ARCHITECT'S FIXTURE SCHEDULE. ANY DISCREPANCIES SHOULD BE ADDRESSED BY CONTRACTOR PRIOR TO PURCHASING OF FIXTURES.
 3. REFER TO G130 FOR STANDARD REACH RANGES, MOUNTING HEIGHTS AND OTHER REQUIREMENTS.
 4. REFER TO SHEET 1110 FOR THE SPECIFICATIONS AND CORNER DETAILS.
 5. PROVIDE WHITE SNAP ON DRAIN PIPE PROTECTION UNDER SINKS.

EQUIPMENT SCHEDULE - REFER TO DRAWING I420 FOR RESPONSIBILITIES

TAG	SPECS	ITEMS	QTY	PRODUCT DESCRIPTION	SPACE
CONTRACTOR PROVIDED AND CONTRACTOR INSTALLED					
EQ-1	113101	REFRIGERATOR	2	FRIGIDAIRE FFH1835VS, 18 CU.FT., TOP FREEZER REFRIGERATOR WITH INTERNAL ICE MAKER, STAINLESS STEEL FINISH.	BREAKROOM / PROGRAM ROOM
EQ-2	113101	MICROWAVE	2	GE PROFILE SERIES COUNTER TOP SENSOR MICROWAVE OVEN (PE57227SLSS) - FINGERLESS STAINLESS STEEL FINISH.	BREAKROOM / PROGRAM ROOM
EQ-3	113101	COFFEE MAKER	2	KEURIG K-1500 COMMERCIAL COFFEE MAKER WITH POUR-OVER RESERVOIR	BREAKROOM / PROGRAM ROOM
EQ-4	113101	DISHWASHER	1	WHIRLPOOL WDT5505APZ, STAINLESS STEEL	PROGRAM ROOM

COPYRIGHT © 2024 CAS ARCHITECTURE, P.C. ALL RIGHTS RESERVED. THIS DOCUMENT AND ANY REPRODUCTIONS IN WHOLE OR IN PART, ARE INSTRUMENTS OF SERVICE AND ARE THE SOLE PROPERTY AND COPYRIGHT OF CAS ARCHITECTURE, P.C. AND MAY NOT BE REPRODUCED, PUBLISHED, USED OR COPIED IN ANY MANNER WITHOUT WRITTEN PERMISSION FROM CAS ARCHITECTURE, P.C. THESE DOCUMENTS HAVE BEEN PREPARED SPECIFICALLY FOR THIS PROJECT. THEY ARE NOT SUITABLE FOR USE ON OTHER PROJECTS OR IN OTHER LOCATIONS.

THIS DOCUMENT WAS CREATED ELECTRONICALLY. THIS MEDIA SHOULD NOT BE CONSIDERED A CERTIFIED DOCUMENT UNLESS IT HAS BEEN PROPERLY SEALED AND ORIGINALLY SIGNED BY A REGISTERED ARCHITECT OF GA ARCHITECTURE, P.C.

THESE PLANS ARE COMPLEMENTARY. THEREFORE THE CONTRACTOR SHALL SEE THE ARCHITECTURAL, STRUCTURAL, MECHANICAL, PLUMBING, AND ELECTRICAL PLANS AND SPECIFICATIONS, WHICH ARE PREPARED BY ANY ONE SHALL BE BINDING AS REQUIRED BY ALL THE INSTRUMENTS OF THE DOCUMENTS INCLUDE ALL LABOR, MATERIALS, EQUIPMENT AND OTHER ITEMS NECESSARY FOR THE PROPER EXECUTION AND COMPLETION OF THE WORK. THE CONTRACTOR SHALL BE RESPONSIBLE FOR THE COORDINATION OF THE WORK OF ALL TRADES.

NO.	DATE	ISSUANCE / REVISIONS

SHEET TITLE
 ENLARGED FLOOR PLANS

SHEET NUMBER

A231

PROJECT DATE DRAWN
 25114 2026/03/20 CAS
 FILE 25114_LEE MEMORIAL LIBRARY F124