



1 ADULT ARROW ROCKER CHAIR AXONOMETRIC
A842

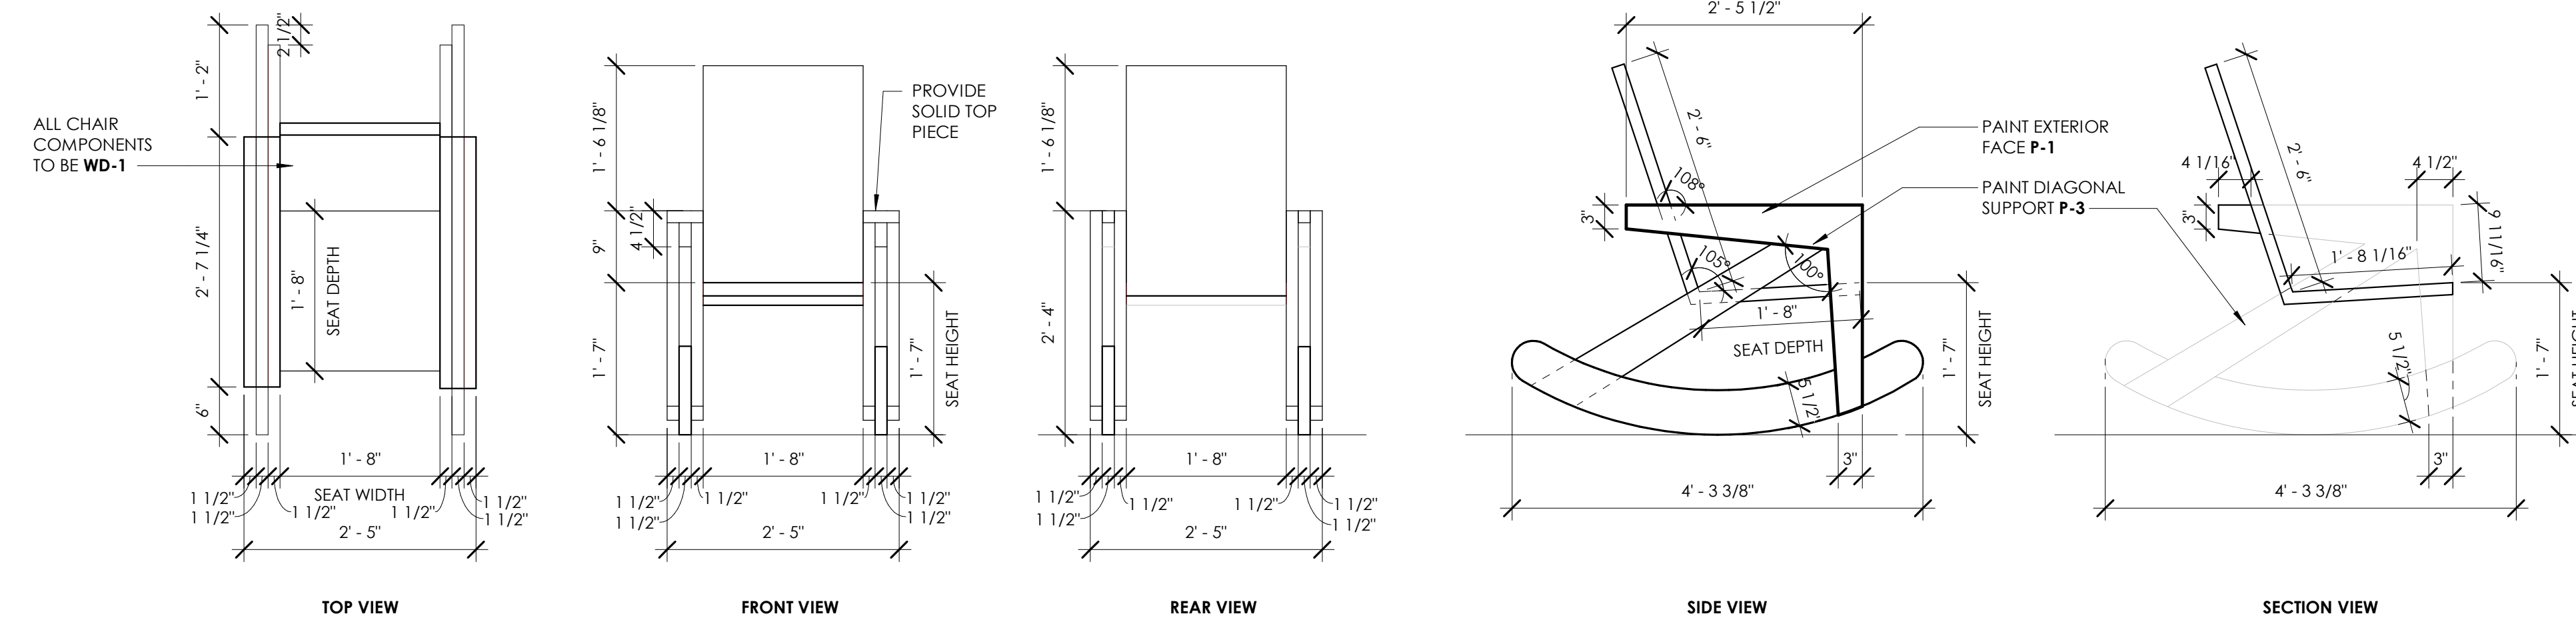


2 ADULT ARROW ROCKER CHAIR (CONTRACTOR TO PROVIDE QUANTITY OF TWO PLUS ONE SAMPLE)
3/4" = 1'-0"


NOTE: FOR ROCKERS PROVIDE EXTERIOR FINAL COAT PROTECTING CLEAR SEALER

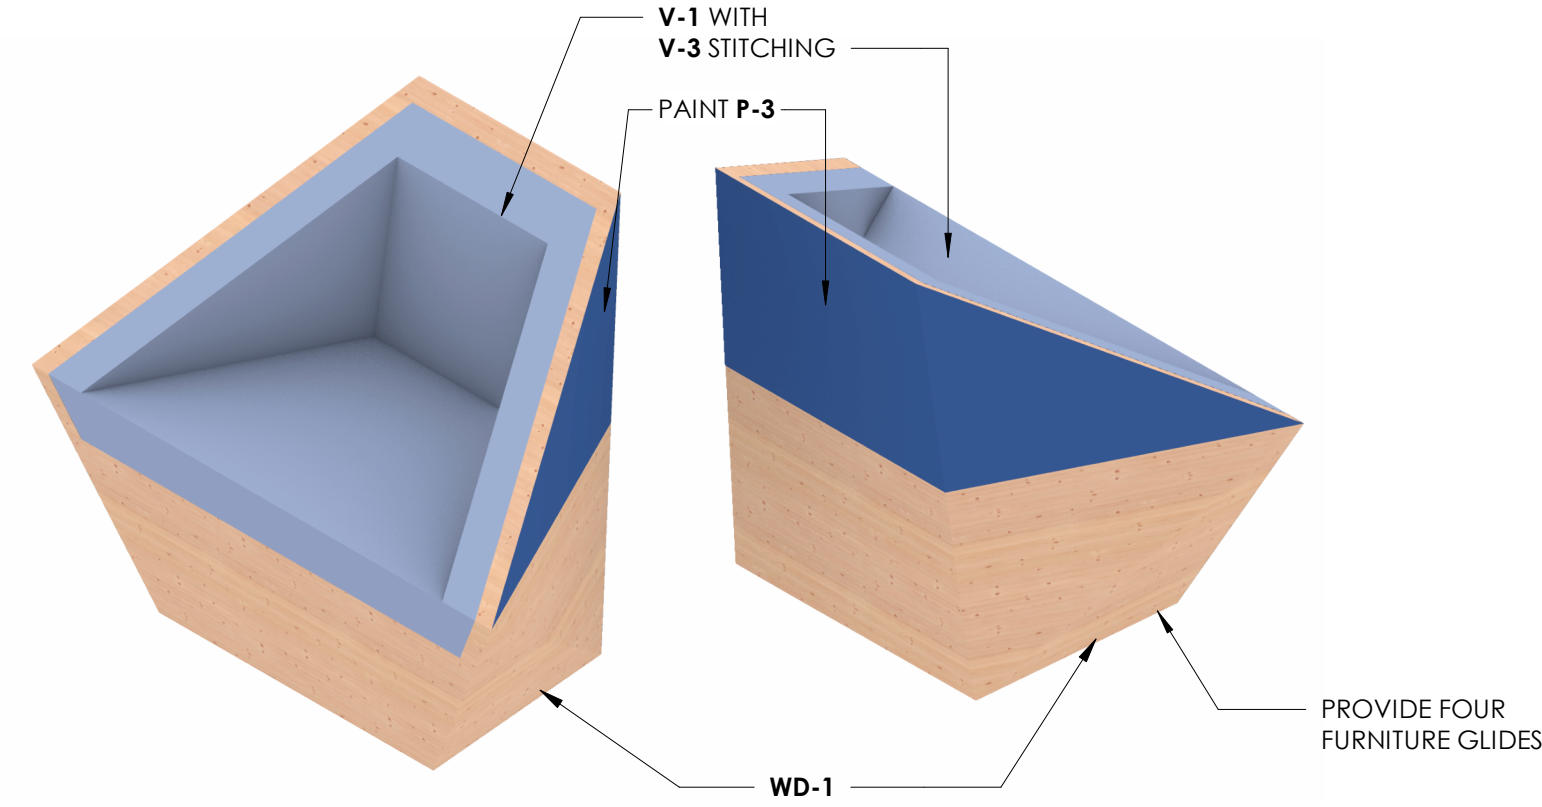


3 TEEN TAG CHAIR AXONOMETRIC
A842

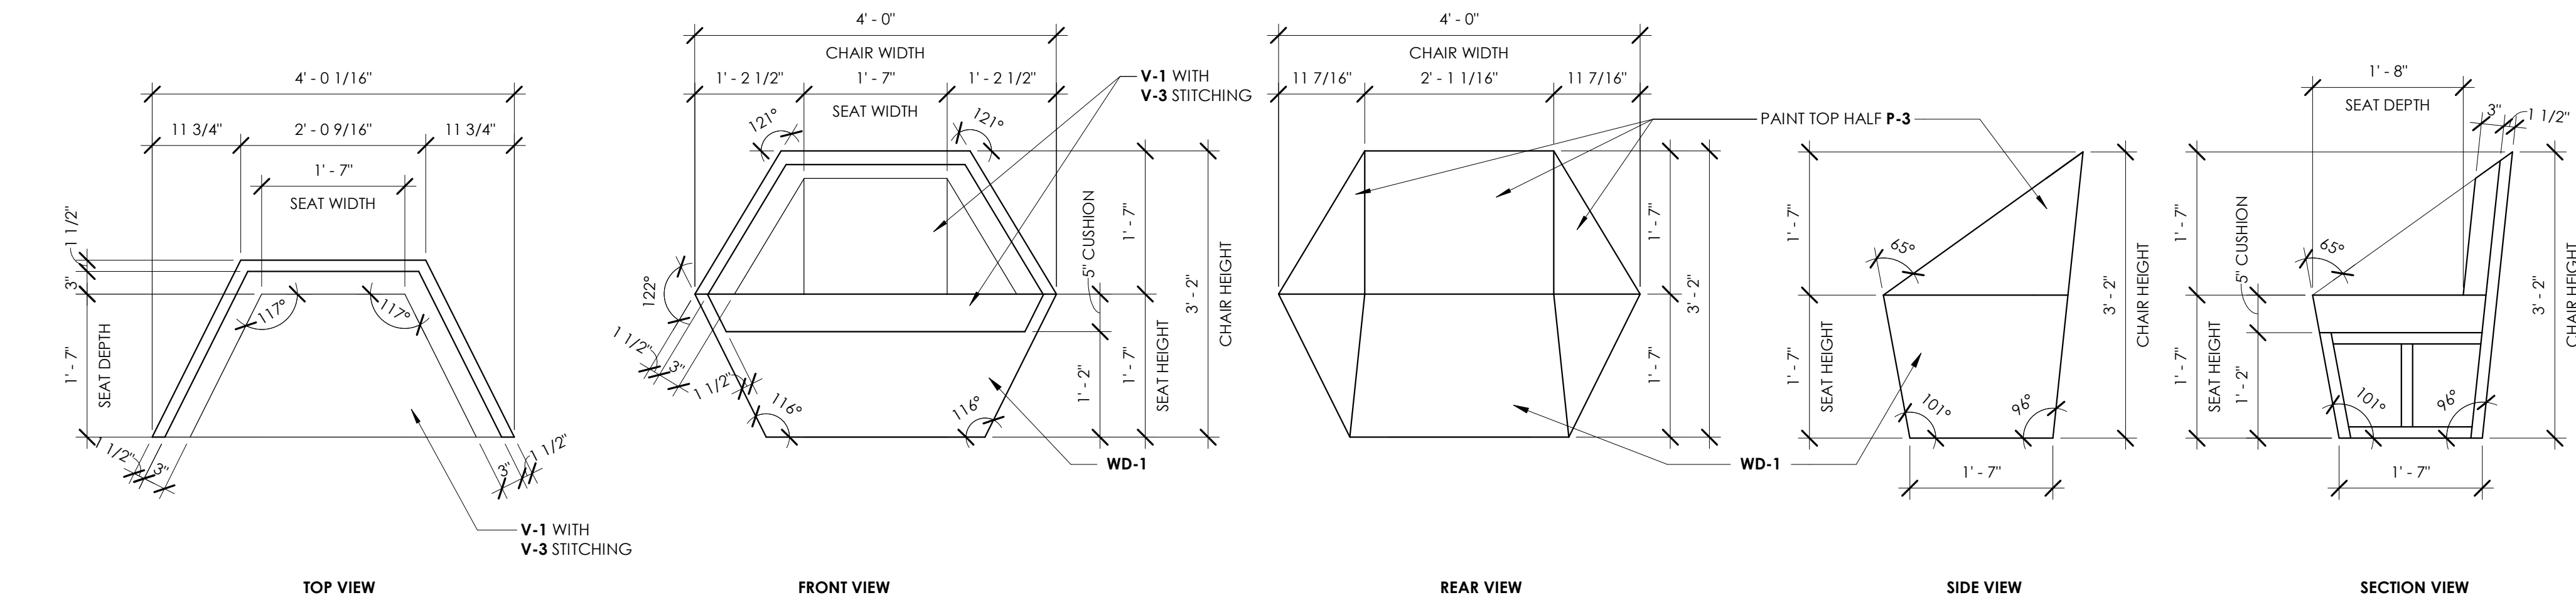


4 TEEN TAG CHAIR (CONTRACTOR TO PROVIDE QUANTITY OF TWO PLUS ONE SAMPLE)
3/4" = 1'-0"

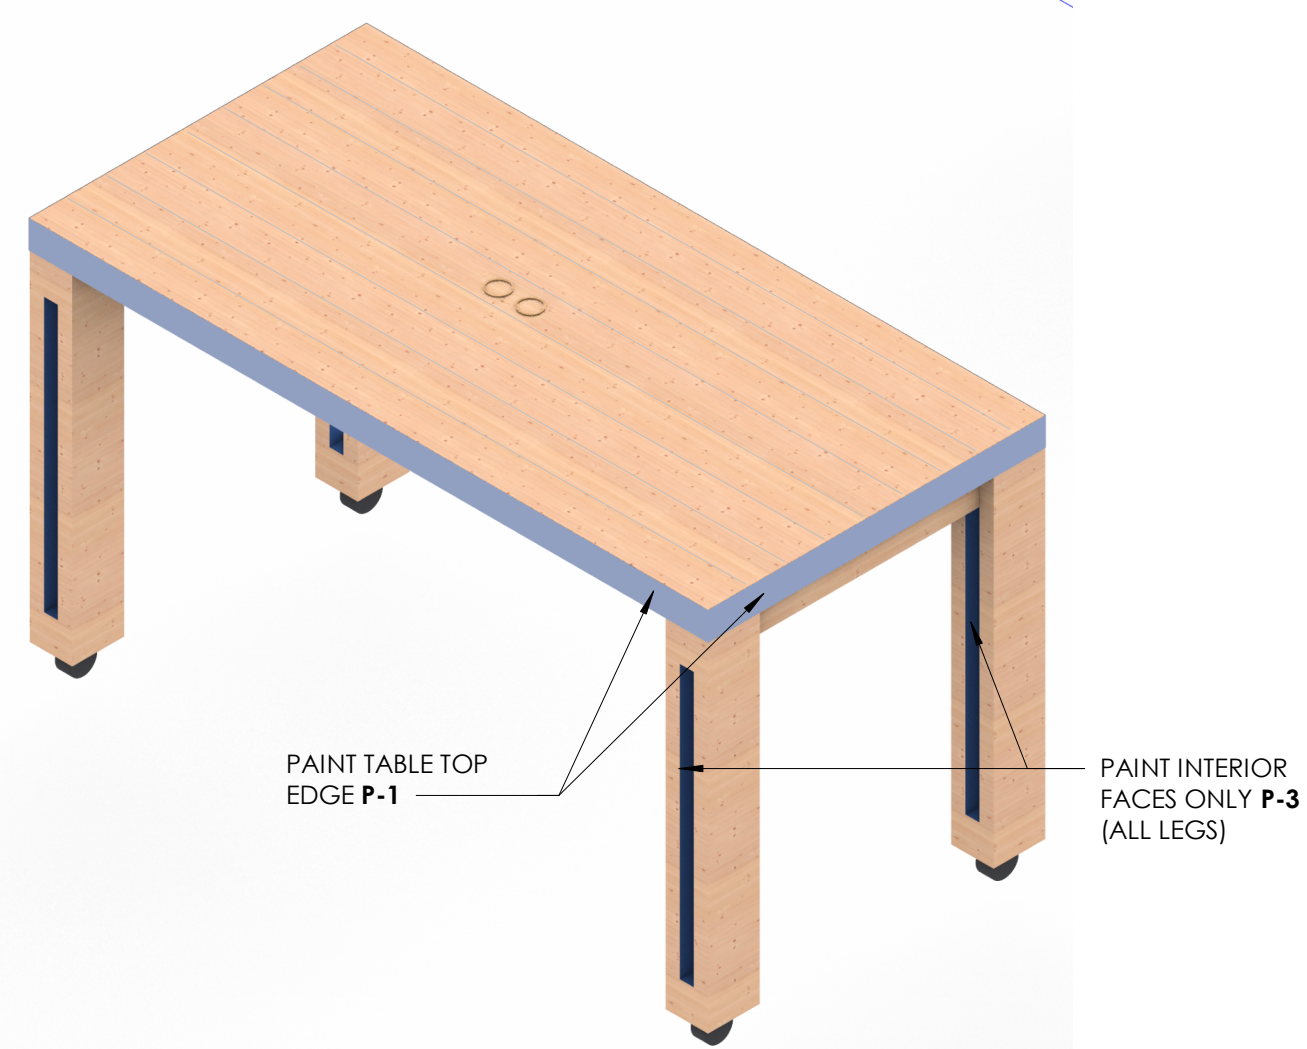


5 BUTCHER'S BLOCK TABLE AXONOMETRIC
A842

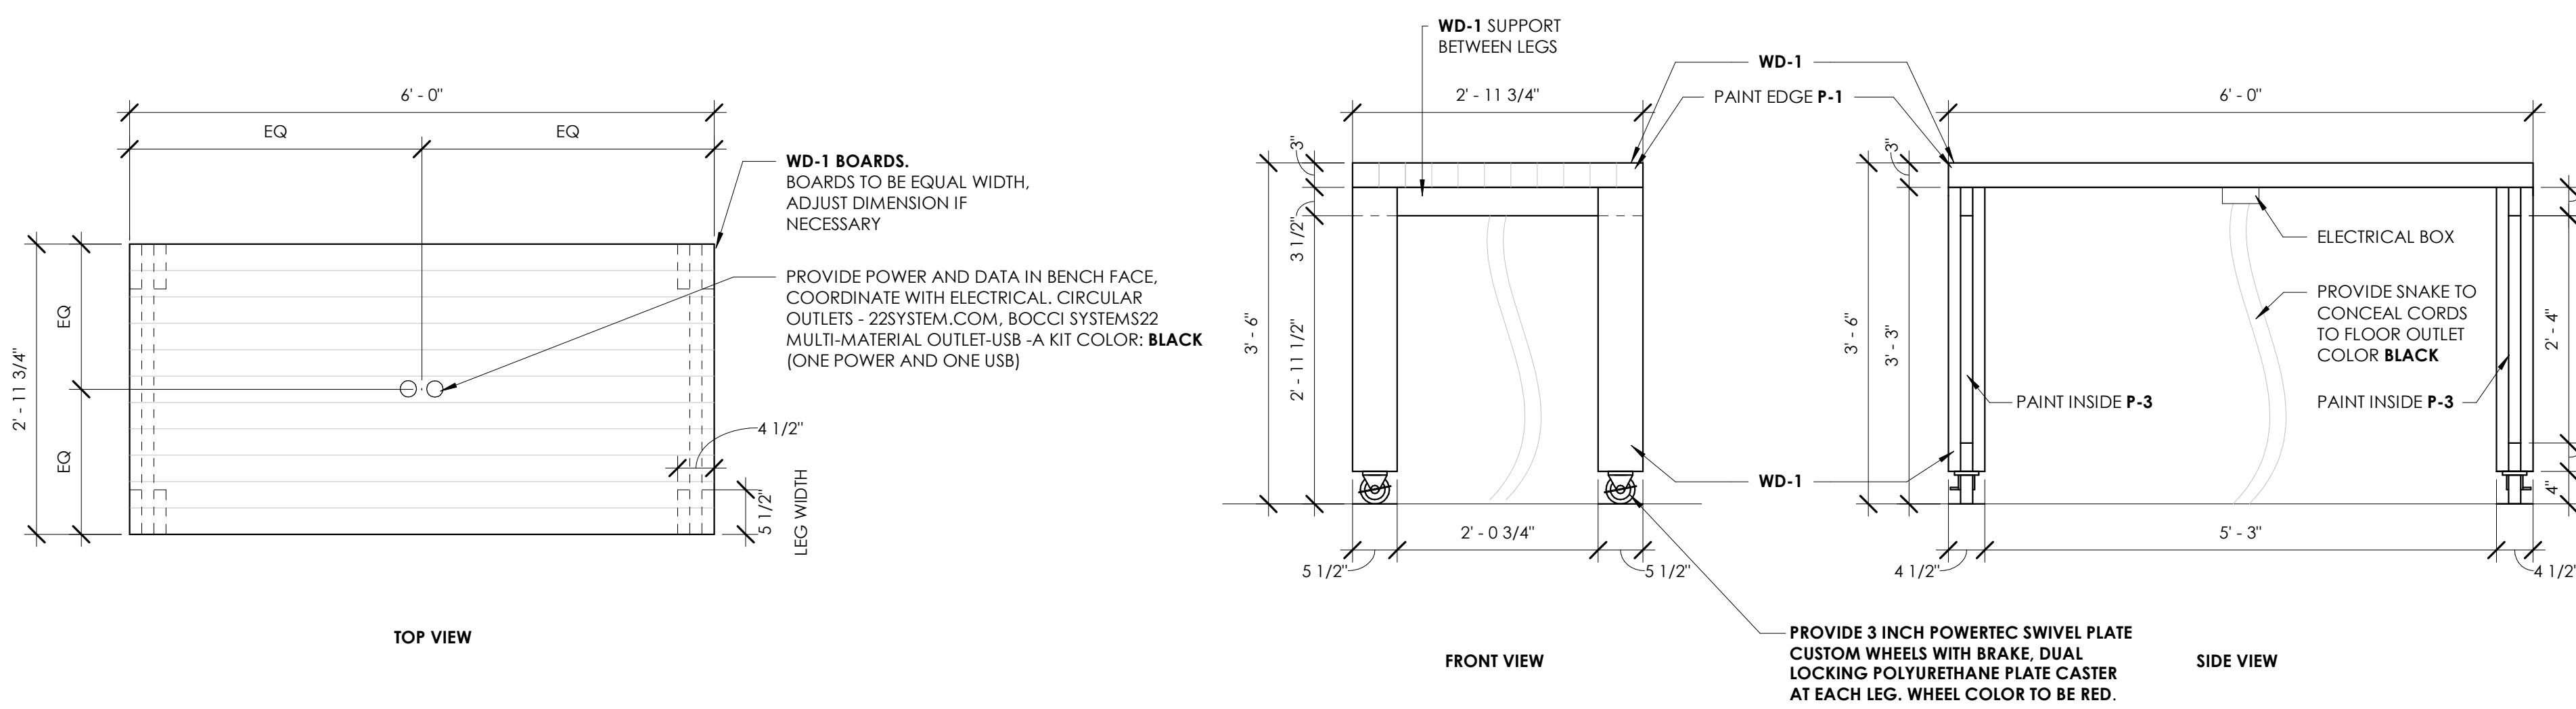

6 BUTCHER'S BLOCK TABLE (CONTRACTOR TO PROVIDE QUANTITY OF THREE)
3/4" = 1'-0"

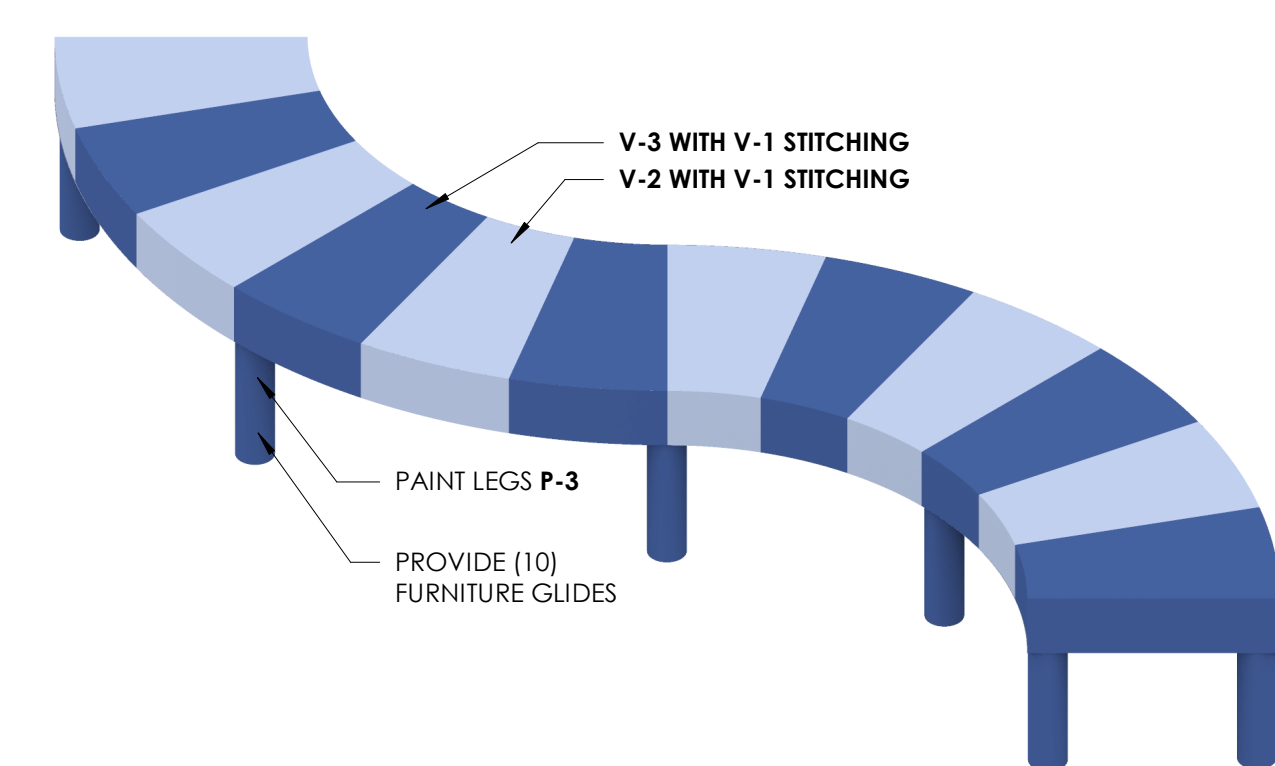

7 CHILDREN'S DOOR SWING BENCH AXONOMETRIC
A842

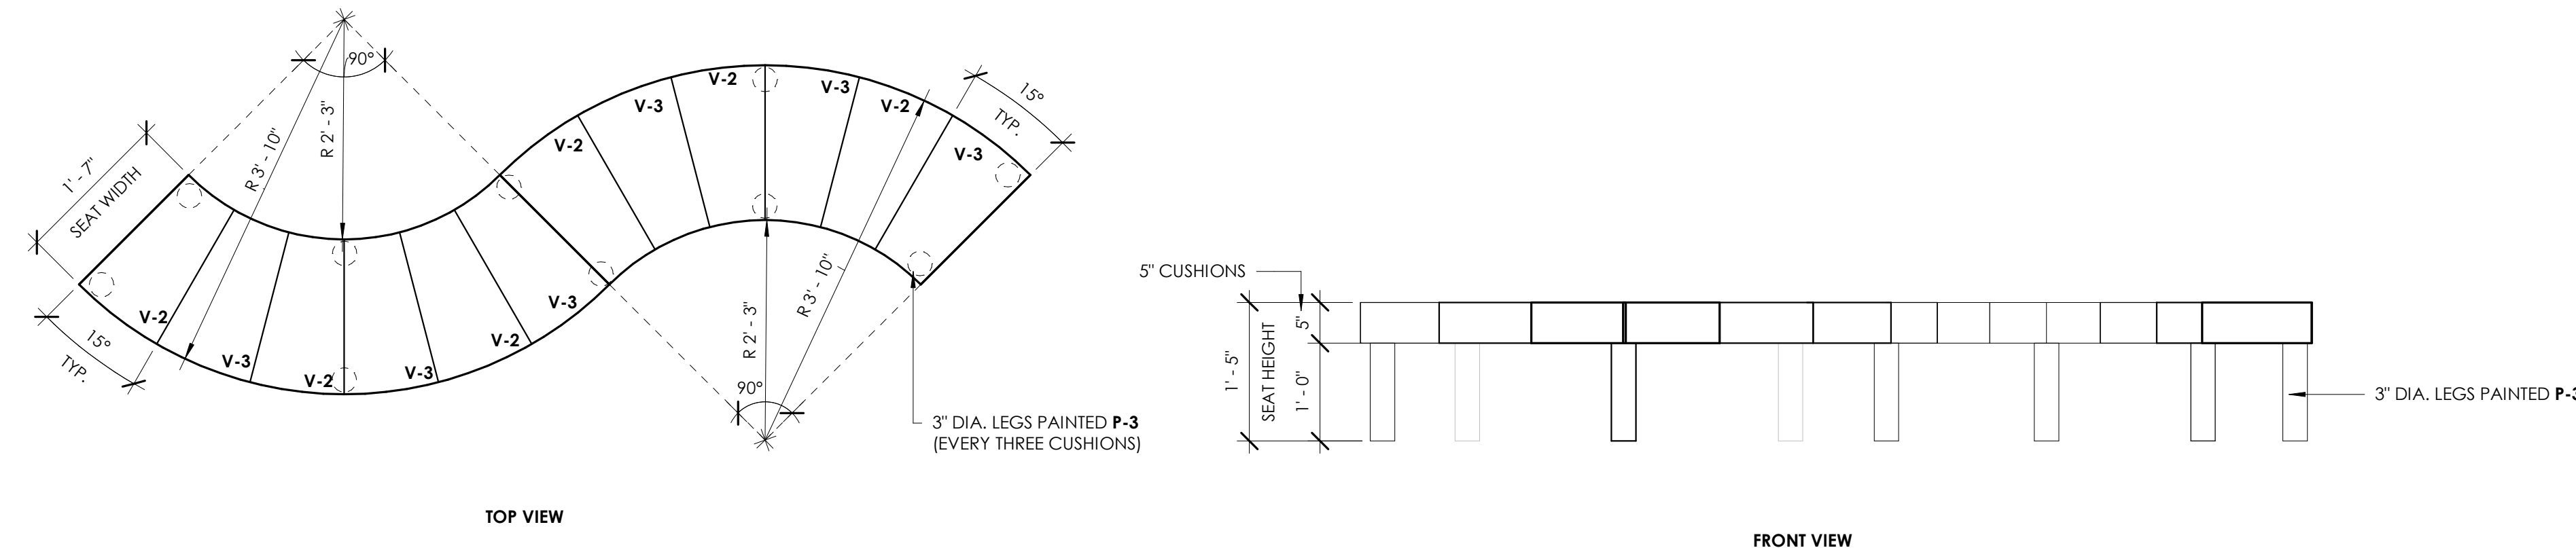

8 CHILDREN'S DOOR SWING BENCH (CONTRACTOR TO PROVIDE QUANTITY OF ONE)
3/4" = 1'-0"

FURNITURE MANUFACTURERS

REFER TO SPECIFICATION 125651 FOR FURNITURE MANUFACTURER.

FURNITURE GLIDES

FURNITURE GLIDE SLIDERS- CLEAR PTFE (TE FLO) CHAIR WHEELS SLIDES FOR CARPET- FLOOR PROTECTOR (1" - 1 1/2")

WOOD SPECIFICATION

REFER TO FINISH LEGEND I110 FOR WOOD SPECIES AND FINISH.

ARCHITECT

CAS

Cas Architecture
183 N Perry St
Lawrenceville, GA
30046
404.806.0556
www.casarc.com

CONSULTANT

CHAD ALEXANDER SMITH
REGISTERED ARCHITECT
No. 19933

IF SEALED, DO NOT COPY

COLLINS P. LEE MEMORIAL LIBRARY
237 HARRISBURG ROAD SW, MILLEDGEVILLE, GA 31061

COPYRIGHT © 2024 CAS ARCHITECTURE, P.C. ALL RIGHTS RESERVED. THIS DOCUMENT AND ANY REPRODUCTIONS IN WHOLE OR IN PART, ARE INSTRUMENTS OF SERVICE AND ARE THE SOLE PROPERTY AND COPYRIGHT OF CAS ARCHITECTURE, P.C. AND MAY NOT BE REPRODUCED, PUBLISHED, USED OR COPIED IN ANY MANNER WITHOUT WRITTEN PERMISSION FROM CAS ARCHITECTURE, P.C. THESE DOCUMENTS HAVE BEEN PREPARED SPECIFICALLY FOR THIS PROJECT. THEY ARE NOT SUITABLE FOR USE ON OTHER PROJECTS OR IN OTHER LOCATIONS.

THIS DOCUMENT WAS CREATED ELECTRONICALLY. THIS MEDIA SHOULD NOT BE CONSIDERED A CERTIFIED DOCUMENT UNLESS IT HAS BEEN PROPERLY SEALED AND ORIGINALLY SIGNED BY A REGISTERED ARCHITECT OF CAS ARCHITECTURE, P.C.

THESE PLANS ARE COMPLEMENTARY. THEREFORE THE CONTRACTOR SHALL SEE THE ARCHITECTURAL, STRUCTURAL, MECHANICAL, PLUMBING, AND ELECTRICAL PLANS AND SPECIFICATIONS, WHEN REQUIRED BY ANY ONE SHALL BE BINDING AS REQUIRED BY ALL THE INTENTION OF THE DOCUMENTS BELONGING TO COLLINS P. LEE MEMORIAL LIBRARY. MATERIALS, EQUIPMENT AND OTHER DEVICES NECESSARY FOR THE PROPER EXECUTION AND COMPLETION OF THE WORK, THE CONTRACTOR SHALL BE RESPONSIBLE FOR THE COORDINATION OF THE WORK OF ALL TRADES.

NO.	DATE	ISSUANCE / REVISIONS

SHEET TITLE
FURNITURE / MILLWORK DETAILS

SHEET NUMBER
A842

PROJECT DATE DRAWN
25114 2026/03/20 CAS

FILE
25114_LEE MEMORIAL LIBRARY R1V24