

COPYRIGHT © 2024 CAS ARCHITECTURE, P.C. ALL RIGHTS RESERVED. THIS DOCUMENT AND ANY REPRODUCTIONS IN WHOLE OR IN PART, ARE INSTRUMENTS OF SERVICE AND ARE THE SOLE PROPERTY AND COPYRIGHT OF CAS ARCHITECTURE, P.C. AND MAY NOT BE REPRODUCED, COPIED, PUBLISHED, USED OR COMMUNICATED IN ANY MANNER WITHOUT WRITTEN PERMISSION FROM CAS ARCHITECTURE, P.C. THESE DOCUMENTS HAVE BEEN PREPARED SPECIFICALLY FOR THIS PROJECT. THEY ARE NOT SUITABLE FOR USE ON OTHER PROJECTS OR IN OTHER LOCATIONS.

THIS DOCUMENT WAS CREATED ELECTRONICALLY. THIS MEDIA SHOULD NOT BE CONSIDERED A CERTIFIED DOCUMENT UNLESS IT HAS BEEN PROPERLY SEALED AND ORIGINALLY SIGNED BY A REGISTERED ARCHITECT OF CAS ARCHITECTURE, P.C.

THESE PLANS ARE COMPLEMENTARY. THEREFORE THE CONTRACTOR SHALL SEE THE ARCHITECTURAL, STRUCTURAL, MECHANICAL, PLUMBING, AND ELECTRICAL PLANS AND SPECIFICATIONS. WHEN DISCREPANCIES ARE FOUND, THE CONTRACTOR SHALL BE RESPONSIBLE FOR RESOLVING THEM. THE CONTRACTOR SHALL BE RESPONSIBLE FOR THE PROPER ERECTION AND COMPLETION OF THE WORK. THE CONTRACTOR SHALL BE RESPONSIBLE FOR THE COORDINATION OF THE WORK OF ALL TRADES.

NO.	DATE	ISSUANCE / REVISIONS
1	2024/04/11	ADDENDUM 1

SHEET TITLE
 WINDOW TYPES

SHEET NUMBER

A920


PROJECT DATE DRAWN
 25114 2026/03/20 CAS

25114_LEE MEMORIAL LIBRARY RV124

EXTERIOR GLAZING LEGEND	
G-0	SPEC. 08 8000 1" INSULATED LOW-E TINTED GLAZING *
*ALL EXTERIOR GLAZING TO BE TYPE G-0, UNLESS NOTED OTHERWISE	
G-1	PRINTED COLOR APPLIED TO #3 SURFACE COLOR TO MATCH PAINT COLOR P-1
G-3	PRINTED COLOR APPLIED TO #3 SURFACE COLOR TO MATCH PAINT COLOR P-3
G-7	PRINTED COLOR APPLIED TO #3 SURFACE COLOR TO MATCH PAINT COLOR P-7
G-8	PRINTED COLOR APPLIED TO #3 SURFACE COLOR TO MATCH PAINT COLOR P-8
G-9	PRINTED COLOR APPLIED TO #3 SURFACE COLOR TO MATCH PAINT COLOR P-9
G-10	PRINTED COLOR APPLIED TO #3 SURFACE COLOR TO MATCH PAINT COLOR P-10
G-12	FROSTED GLASS

NOTE: ALL EXTERIOR GLAZING MUST MEET STATE ENERGY CODE REQUIREMENTS, EITHER BY MEETING PRESCRIPTIVE VALUES FOR U-VALUE AND SHGC, OR BY MEETING PERFORMANCE REQUIREMENTS SET FORTH IN THIS PROJECT'S ENERGY ANALYSIS REPORT. ALL GLAZING MUST BE APPROVED BY ARCHITECT PRIOR TO INSTALLATION.

GLASS COLOR AND/OR PATTERN TO BE PRINTED USING THE FOLLOWING BASIS OF DESIGN (OR EQUAL):
 ON-SITE SYSTEMS
 470 SATELLITE BLVD., NE, BUILDING A
 SUWANEE, GA 30024
 http://www.on-sitesystems.com
 ALEX HOUWING
 678-982-4269

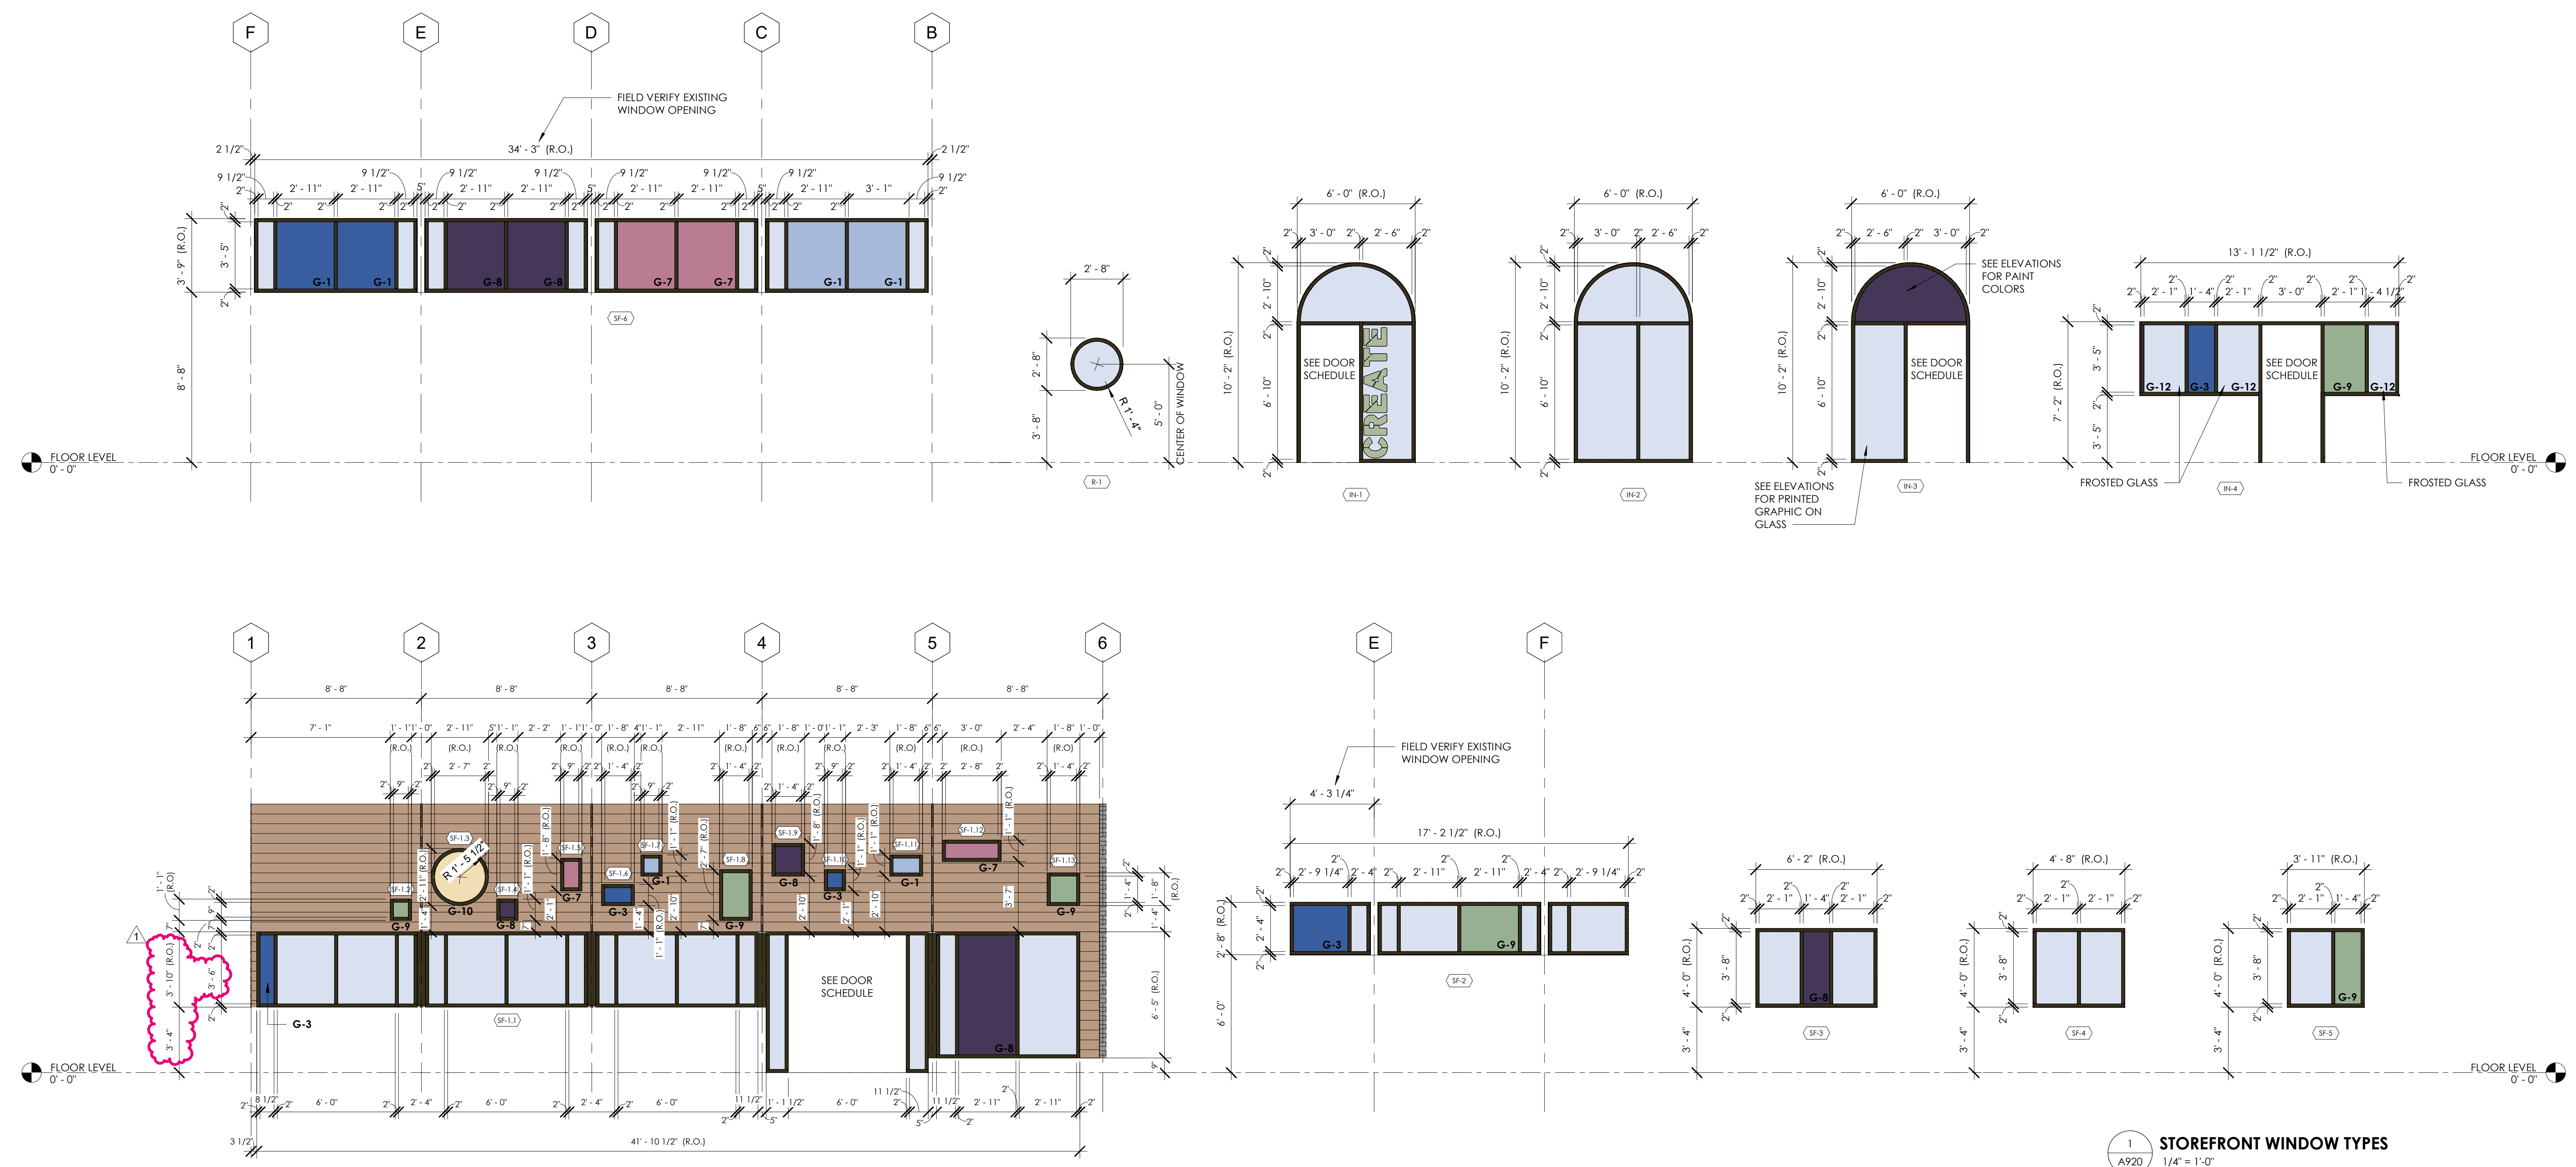

1 STOREFRONT WINDOW TYPES
 1/4" = 1'-0"