


FIXED AND PORTABLE GENERATOR INSTALLATIONS

DUBLIN, GA

FEMA HAZARD MITIGATION GRANT PROGRAM (HMGP)

FEMA PROJECT NUMBER: HMGP 4400-0025

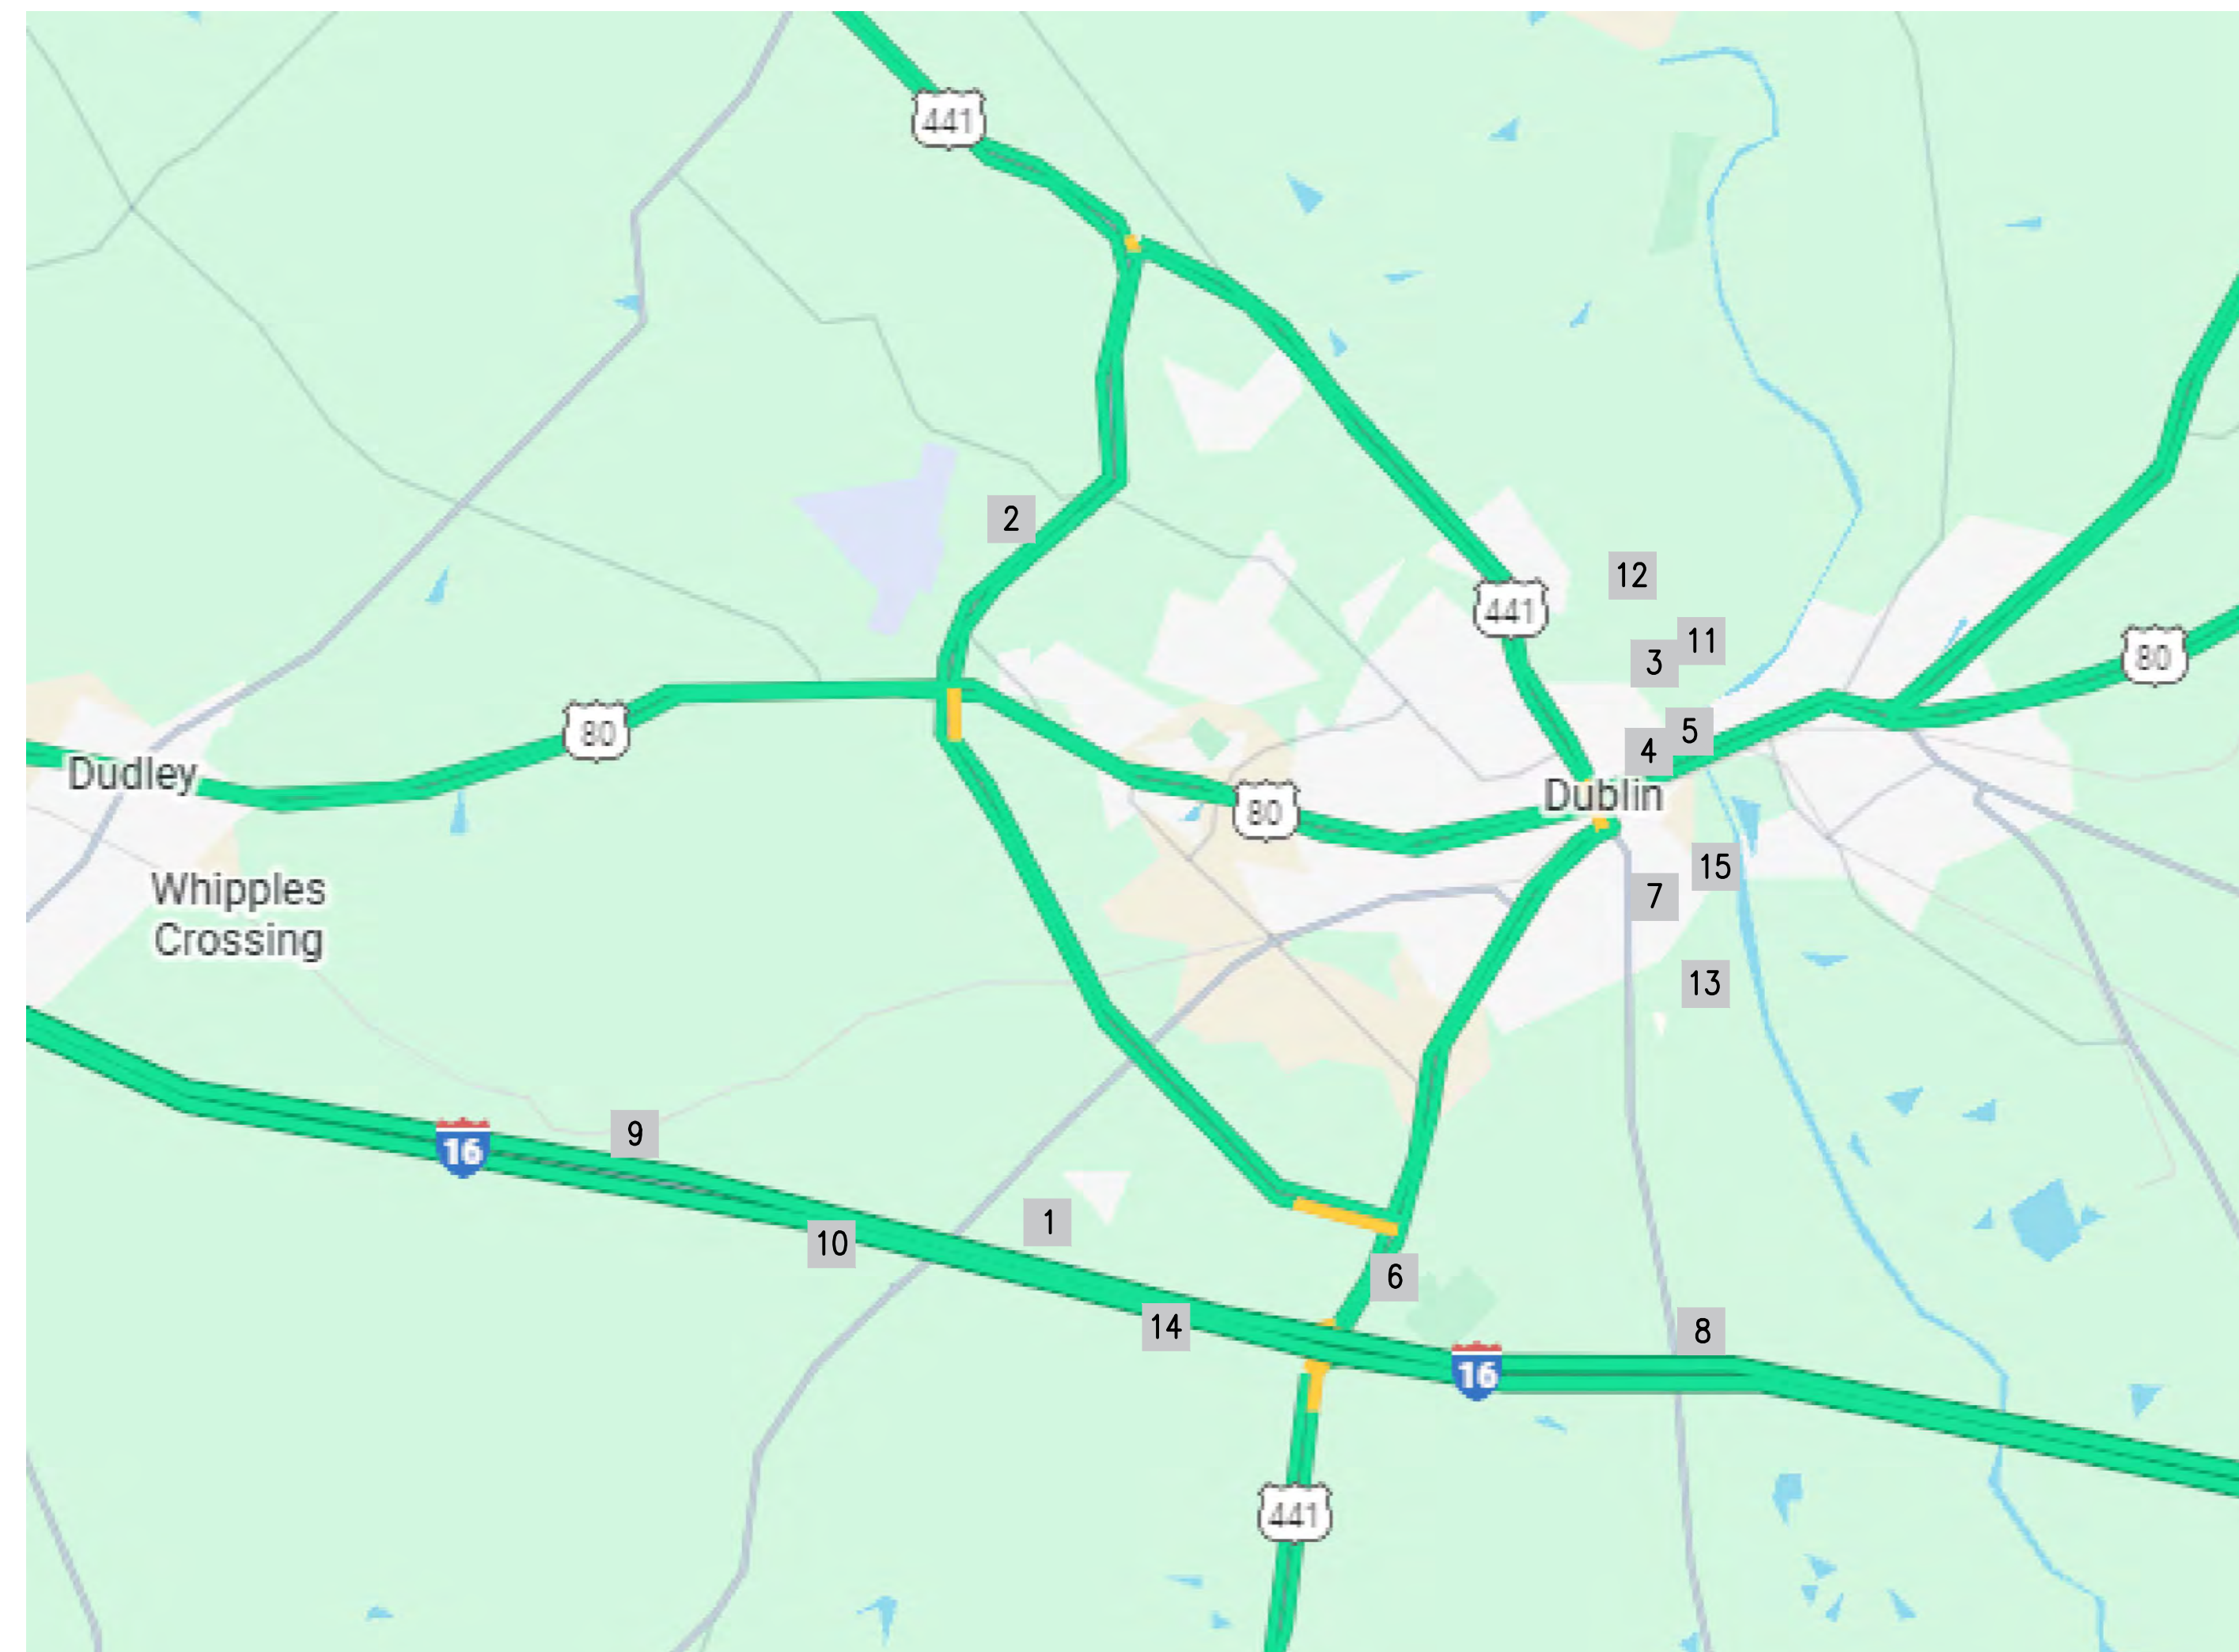


Index of Locations

MAP ID	PUMP STATION	ADDRESS
1	ACADEMY EXTENSION PUMP STATION	1010 HONEYSUCKLE ROAD
2	AIRPORT PUMP STATION	599 AIRPORT ROAD
3	ALABAMA PUMP STATION	808 ALABAMA STREET
4	EMERGENCY REPLACEMENT WATER WELL	200 TRUXTON STREET
5	EXISTING WATER WELL	EAST MADISON & SOUTH UNION STREET
6	HOLIDAY INN PUMP STATION - PORTABLE GENERATOR	2186 HOLIDAY INN ROAD
7	CARVER STREET PUMP STATION - PORTABLE GENERATOR	1251 CARVER STREET
8	HWY 19 PUMP STATION	1572 HWY 19 SOUTH
9	I-16 WEST BOUND PUMP STATION	12063 I-16
10	LOVES PUMP STATION	63 WALDREP ROAD
11	RAW WATER PUMP STATION	101 PARKER DAIRY ROAD
12	SURFACE WATER TREATMENT PLANT	106 PARKER DAIRY ROAD
13	WASTEWATER TREATMENT PLANT	250 RIVERVIEW DRIVE
14	WEST LAURENS PUMP STATION	297 WEST LAURENS SCHOOL ROAD
15	WASHINGTON STREET PUMP STATION	1106 SOUTH WASHINGTON STREET

Index of Drawings

DWG NO.	DRAWING TITLE
G0	COVER SHEET
GENERAL	
CIVIL	
C1	SITE PLAN - ALABAMA & RAW WATER PUMP STATIONS
STRUCTURAL	
S0	STRUCTURAL DETAILS
S1	SURFACE WATER TREATMENT PLANT STRUCTURAL DETAILS
ELECTRICAL	
E0	DETAILS, NOTES, ABBREVIATIONS, AND LEGENDS
E1	DEMOLITION & NEW WORK PLANS - ACADEMY EXTENSION PUMP STATION
E2	DEMOLITION & NEW WORK PLANS - AIRPORT PUMP STATION
E3	DEMOLITION & NEW WORK PLANS - ALABAMA PUMP STATION
E4	DEMOLITION & NEW WORK PLANS - RAW WATER PUMP STATION
E5	ELECTRICAL SITE PLAN - ALABAMA & RAW WATER PUMP STATIONS
E6	DEMOLITION & NEW WORK PLANS - EMERGENCY REPLACEMENT WATER WELL
E7	DEMOLITION & NEW WORK PLANS - EXISTING WATER WELL
E8	DEMOLITION & NEW WORK PLANS - HOLIDAY INN PUMP STATION
E9	DEMOLITION & NEW WORK PLANS - CARVER STREET PUMP STATION
E10	DEMOLITION & NEW WORK PLANS - HWY 19 PUMP STATION
E11	DEMOLITION & NEW WORK PLANS - I-16 WEST BOUND PUMP STATION
E12	DEMOLITION & NEW WORK PLANS - LOVES PUMP STATION
E13	DEMOLITION & NEW WORK PLANS - SURFACE WATER TREATMENT PLANT
E14	DEMOLITION & NEW WORK PLANS - WASTEWATER TREATMENT PLANT
E15	DEMOLITION & NEW WORK PLANS - WEST LAURENS PUMP STATION
E16	DEMOLITION & NEW WORK PLANS - WASHINGTON STREET PUMP STATION

REVISION	ITEM	DATE

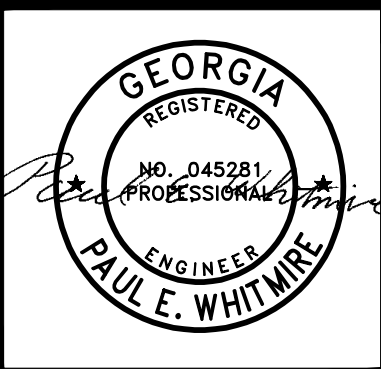

SHEET:
COVER SHEET

590 MEANS STREET NW
STE. 200
ATLANTA, GA 30318
TOLAND
MIZELL
MOLNAR

PROJECT:
FIXED AND PORTABLE GENERATOR INSTALLATIONS

JOB NO: TMM 2507
DATE: 01-30-26
DRAWN: FSD
CHECKED: PEW
APPROVED: RBP
SCALE: AS NOTED

SHEET
G0

