

HENRY COUNTY SCHOOLS

HCS - SRO Offices - Warhawk Fieldhouse Modifications

47 LEMON STREET MCDONOUGH, GA 30253

FINAL DOCUMENTS

06 / 18 / 2026

PROJECT NUMBER: 250306

ARCHITECT
PBK ARCHITECTS, INC
525 EAST TAYLOR ST.
GRIFFIN, GA 30224
T 770-227-5473

CIVIL ENGINEER
CARTER ENGINEERING GROUP
6310 PEAKE RD, STE 200
MACON, GA 31210
T 478-219-2600

MEP ENGINEER
ANDREWS, HAMMOCK & POWELL
250 CHARTER LANE
MACON, GA 31210
T 478.405.8301

STRUCTURAL
PBK ARCHITECTS, INC
5019 WEST BROAD ST., SUITE M207
SUGAR HILL, GA 30158
T (770) 227-5473

SHEET INDEX

SHEET NUMBER	SHEET NAME
ARCHITECTURAL GENERAL	
G-000	COVER SHEET

SHEET NUMBER	SHEET NAME
CIVIL	
C1.1	OVERALL SITE PLAN
C2.1	SITE SURVEY AND DEMOLITION PLAN
C3.1	SITE LAYOUT AND PAVING PLAN
C4.1	SITE GRADING AND DRAINAGE PLAN
C5.1	SITE WATER AND SANITARY SEWER PLAN
C6.1	SOIL EROSION AND SEDIMENT CONTROL PLAN
C6.2	SOIL EROSION AND SEDIMENT CONTROL NOTES
C6.3	SOIL EROSION AND SEDIMENT CONTROL DETAILS
C7.1	MISCELLANEOUS SITE DETAILS
C7.2	MISCELLANEOUS SITE DETAILS
L1.1	LANDSCAPE PLAN
L1.2	LANDSCAPE NOTES AND DETAILS

SHEET NUMBER	SHEET NAME
ARCHITECTURAL GENERAL	
G-101	LIFE SAFETY PLAN
ARCHITECTURAL SITE	
AS-101	ARCHITECTURAL SITE PLAN
AS-102	ALUMINUM WALKWAY CANOPY DETAILS
ARCHITECTURAL DEMOLITION	
AD-101	DEMOLITION PLAN
ARCHITECTURAL	
A-101	FLOOR PLAN
A-111	DIMENSION FLOOR PLAN
A-201	REFLECTED CEILING PLAN & DETAILS
A-301	ROOF PLAN & DETAILS
A-401	ENLARGED TOILET PLANS
A-501	EXTERIOR ELEVATIONS
A-601	BUILDING & WALL SECTIONS
A-801	DOOR SCHEDULE & DETAILS
A-802	PARTITION TYPES
A-901	FINISH PLAN
A-902	MILLWORK ELEVATIONS & DETAILS
ARCHITECTURAL GRAPHICS	
AG001	SIGNAGE GRAPHIC STANDARDS


SHEET NUMBER	SHEET NAME
STRUCTURAL	
S-010	GENERAL NOTES
S-011	GENERAL NOTES
SD-101	DEMO PLAN
S-101	FOUNDATION PLAN
S-102	ROOF FRAMING PLAN
S-300	GENERAL CONCRETE AND STL REINF NOTES AND TYP DETAILS
S-301	GENERAL SLAB-ON-GRADE NOTES AND TYP DETAILS
S-302	FOUNDATION DETAILS
S-400	GENERAL CMU NOTES AND TYP DETAILS
S-401	GENERAL CMU NOTES AND TYP DETAILS
S-402	MISC CMU DETAILS
S-501	GENERAL EXISTING FRAMING NOTES AND TYP DETAILS

SHEET NUMBER	SHEET NAME
PLUMBING	
PD-101	PLUMBING OVERALL DEMOLITION PLAN
PLUMBING	
P-101	PLUMBING FLOOR PLAN - WATER PIPING
P-102	PLUMBING FLOOR PLANS - WASTE PIPING
P-201	PLUMBING WATER RISER
P-202	PLUMBING WASTE RISER
P-301	PLUMBING SCHEDULE, LEGEND, AND DETAILS

SHEET NUMBER	SHEET NAME
MECHANICAL	
MD-101	MECHANICAL DEMOLITION FLOOR PLAN
MECHANICAL	
MA-101	MECHANICAL NEW WORK FLOOR PLAN
M-501	MECHANICAL DETAILS
M-502	MECHANICAL DETAILS
M-601	MECHANICAL SCHEDULES, LEGEND & GENERAL NOTES

SHEET NUMBER	SHEET NAME
E	
E101	ELECTRICAL SITE PLAN
E101	ELECTRICAL LIGHTING AND POWER FLOOR PLAN
E201	ELECTRICAL LOW VOLTAGE AND MECHANICAL POWER FLOOR PLAN
E801	ELECTRICAL PANELS AND SCHEDULES
E802	ELECTRICAL DETAILS AND LEGEND

PROJECT SYMBOLS

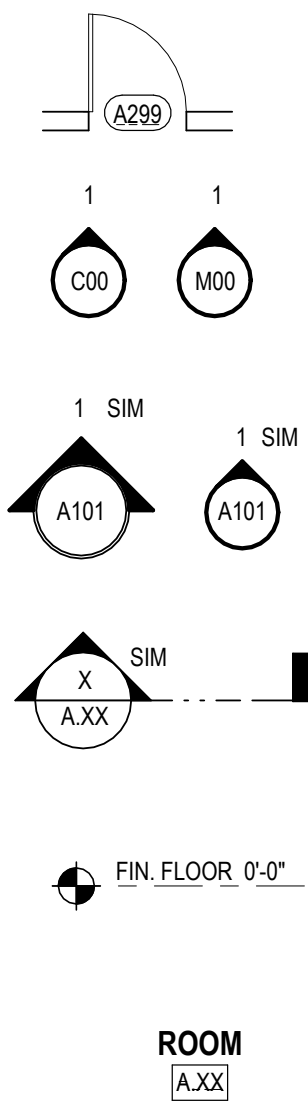

DOOR TAG

CASEWORK / MILLWORK
REFERENCE

EXTERIOR / INTERIOR
ELEVATION REFERENCE

SECTION REFERENCE

ELEVATION TARGET

SPACE NAME REFERENCE

RE: 01 / A-101B

MATCHLINE
VIEW REFERENCE

PARTITION TYPE TAG

KEYNOTE TAG

WINDOW & LOUVER TAG

MATERIAL TAG

REVISION TAG

MATCHLINE - SEE SECTOR "B"
MATCHLINE - SEE SECTOR "A"

MATCHLINE REFERENCE

NORTH ARROW

EXIT SIGN w/
DIRECTION SYMBOL

APC #1 ← CEILING TYPE
8'-0" ← CEILING HEIGHT

--- CENTER LINE, & SYMBOL

--- ABOVE LINE

--- BEYOND LINE

--- BREAK LINE

CONSTRUCTION TYPE SYMBOLS

--- EXISTING CONSTRUCTION
TO REMAIN

--- EXISTING CONSTRUCTION
TO BE DEMOLISHED

--- NEW NON-RATED
CONSTRUCTION

24 HOUR CONTACT:
HENRY COUNTY SCHOOLS, 396 TOMLINSON STREET
MCDONOUGH, GA 30253
MR. BARRY MILES, 770.957.1891

BUILDING AREA	
EXISTING BUILDING:	7,097 SF
ADDITION:	0 SF
TOTAL AREA:	7,097 SF


OCCUPANCY: BUSINESS
BUILDING USE: OFFICE
CONSTRUCTION TYPE: TYPE IIB, NON-SPRINKLERED

INTERNATIONAL BUILDING CODE, 2024 EDITION
INTERNATIONAL FUEL GAS CODE, 2024 EDITION
INTERNATIONAL MECHANICAL CODE, 2024 EDITION
INTERNATIONAL PLUMBING CODE, 2024 EDITION
NATIONAL ELECTRICAL CODE, 2023 EDITION
INTERNATIONAL FIRE CODE, 2024 EDITION
NFPA 101 2024 EDITION
ANSI 117.1
2010 ADA STANDARDS FOR ACCESSIBLE DESIGN
ALL WITH GA. AMENDMENTS

FIRE MARSHAL NOTE

THE SCOPE OF THIS PROJECT DOES NOT INCLUDE ANY ADDITIONS TO THE EXISTING BUILDING. IT INCLUDES MODIFICATIONS TO THE EXISTING LIFE SAFETY ASPECTS OF THE BUILDING (SEE SHEET G-121)

VICINITY MAP

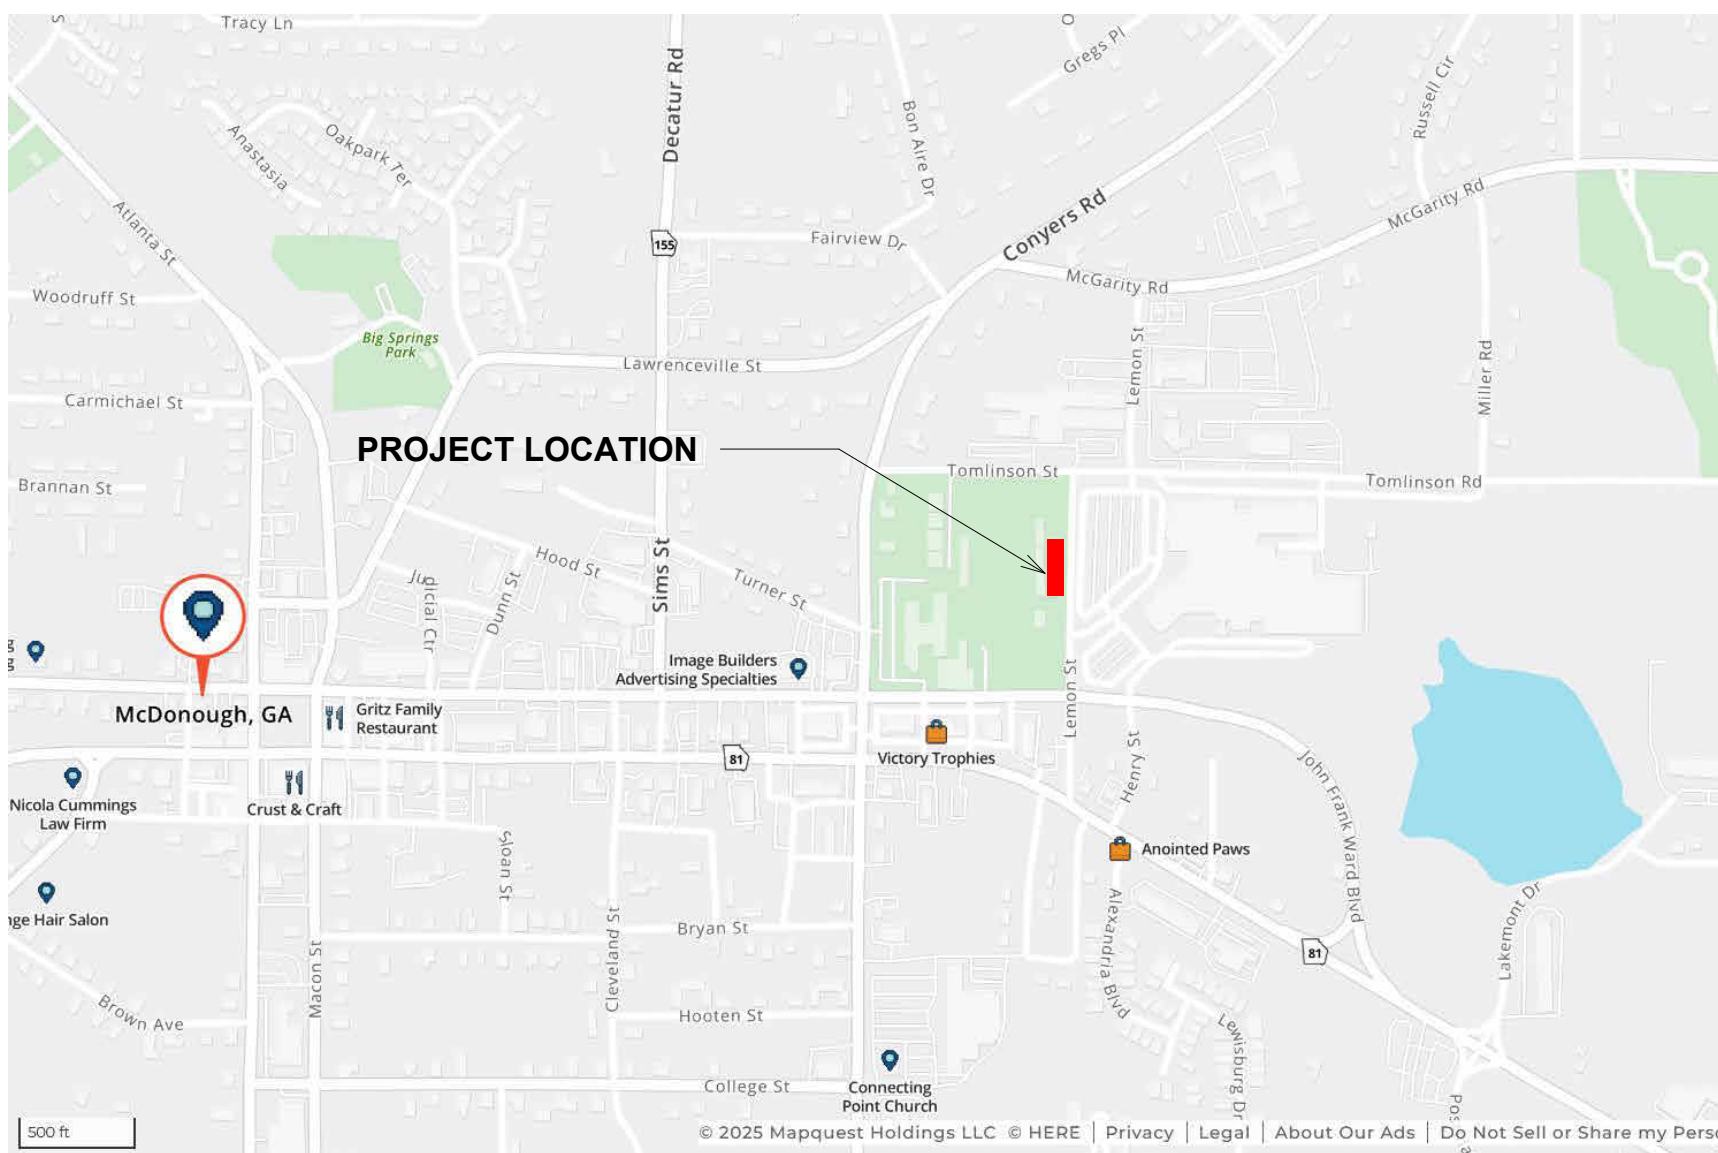

CLIENT HENRY COUNTY SCHOOLS		
DATE 06 / 18 / 2026		PROJECT NUMBER 250306
DRAWING HISTORY		
No.	Description	Date
CHECKED BY: RV		
DRAWN BY: JH		