

DEMOLITION PLAN LEGEND



- DEMO DOOR
- DEMO WINDOW
- DEMO WALL

DEMO PLAN KEYNOTES

Note Number	Note Text
D1	REMOVE BRICK VENEER AND MASONRY WALL, FROM TOP OF FOOTING TO BOTTOM OF ROOF DECK.
D2	REMOVE EXTERIOR DOOR AND FRAME.
D3	REMOVE BRICK VENEER AND MASONRY TO ACCOMMODATE NEW DOOR/WINDOW.
D4	REMOVE WALL FROM TOP OF SLAB UP TO BOTTOM OF ROOF DECK.
D5	REMOVE PLUMBING FIXTURES. COORDINATE SUPPLY SHUT-OFF WITH PLUMBING DWGS.
D6	REMOVE ALL CEILINGS, LIGHT FIXTURES AND HVAC GRILLES IN THIS AREA.
D7	DEMO EXISTING CONCRETE SLAB IN THIS AREA. COORD. FINISH FLOOR HEIGHTS IN EACH AREA TO PROVIDE 1 NEW FINISH FLOOR ELEVATION.
D8	DEMO EXISTING CONCRETE SIDEWALK IN THIS AREA.
D9	REMOVE FLOOR DRAINS. SEE PLUMBING
D10	REMOVE EXISTING SHEAR WALL FROM BOTTOM OF FOOTING TO BOTTOM OF ROOF DECK
D11	REMOVE EXISTING ROOF SYSTEMS DOWN TO THE STEEL DECK. COORD. TIMING WITH NEW ROOF SYSTEM INSTALLATION.
D12	REMOVE EXISTING METAL SOFFIT PANELS

GENERAL ARCH DEMOLITION NOTES

- DEMOLITION PLANS INDICATE SOME OF THE SCOPE-OF-WORK INVOLVED FOR THE DEMOLITION PHASE OF THIS PROJECT. CONTRACTOR SHALL REFER TO PLUMBING, MECHANICAL, AND ELECTRICAL DOCUMENTS FOR ADDITIONAL DEMOLITION SCOPE.
- CONTRACTOR SHALL VERIFY EXISTING SITE AND BUILDING CONDITIONS AND DIMENSIONS IN THE FIELD PRIOR TO DEMOLITION ACTIVITIES AND WORK.
- CONTRACTOR SHALL NOTIFY ARCHITECT OF ANY DISCREPANCIES IN WRITING.
- CONTRACTOR SHALL NOTIFY ARCHITECT AND OWNER OF ANY POSSIBLE ASBESTOS CONTAINING MATERIALS DISCOVERED BEFORE PROCEEDING WITH WORK. PROTECT INTERIOR CONSTRUCTION TO REMAIN DURING DEMOLITION AND CONSTRUCTION.
- CONTRACTOR SHALL OBTAIN ALL NECESSARY PERMITS BEFORE COMMENCING WORK.
- AFTER AWARD OF THE CONTRACT, CHANGE ORDER REQUESTS FOR ADDITIONAL MONEY WILL NOT BE APPROVED IF THE WORK COULD HAVE BEEN ANTICIPATED DURING A SITE VISIT BY THE CONTRACTOR.
- CONTRACTOR SHALL NOT SCALE DRAWINGS.
- CONTRACTOR SHALL PROVIDE ALL NECESSARY TEMPORARY SHORING, TEMPORARY BRACING, AND OR TEMPORARY SUPPORTS AS REQUIRED TO MAINTAIN STRUCTURAL INTEGRITY OF EXISTING STRUCTURE TO REMAIN AND OR EXISTING BUILDING ELEMENTS TO REMAIN.
- CONTRACTOR IS TO VERIFY THE EXACT LOCATION OF ALL EXISTING UTILITIES PRIOR TO DEMOLITION ACTIVITIES AND WORK.
- CONTRACTOR SHALL REMOVE TRASH AND DEBRIS REGULARLY AS NECESSARY TO ELIMINATED INTERFERENCE WITH ROADS, STREET, WALKS, AND ALL OTHER ADJACENT FACILITIES.
- CONTRACTOR SHALL REMOVE TRASH AND DEBRIS FROM THE SITE ON A DAILY BASIS.
- CONTRACTOR IS RESPONSIBLE FOR CONSTRUCTION OF TEMPORARY DUST AND OR SOUND PARTITION BETWEEN CONSTRUCTION AREA AND AREAS NOT IN SCOPE AS NECESSARY. DEMOLITION ACTIVITIES SHALL BE PERFORMED SO AS TO PRODUCE MINIMAL DISTURBANCE TO EXISTING FACILITY AND OCCUPANTS (I.E. MINIMIZE EXCESSIVE AND PROLONGED NOISE LEVELS AND DUST).
- ALL EXISTING EQUIPMENT THAT REMAINS SHALL BE PROTECTED DURING DEMOLITION AND OR CONSTRUCTION TO PREVENT DAMAGE. ANY DAMAGE TO REMAINING EXISTING EQUIPMENT SUSTAINED DURING DEMOLITION AND OR CONSTRUCTION SHALL BE EQUIVALENTLY REPLACED OR EQUIVALENTLY REPAIRED AT NO COST TO THE OWNER.
- OWNER HAS RIGHT OF FIRST REFUSAL OF ALL ITEMS REMOVED AS PART OF THE SCOPE OF WORK, WHETHER IDENTIFIED AS SALVAGE OR NOT.
- NOTIFY THE BUILDING OWNER OF ANY MATERIALS, FIXTURES, ETC. TO BE REMOVED THAT ARE DEEMED SALVAGEABLE. TURN OVER ANY REQUESTED ITEMS TO THE BUILDING OWNER IN GOOD AND CLEAN CONDITION.

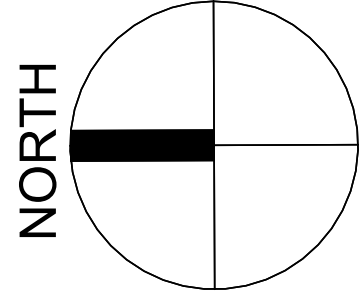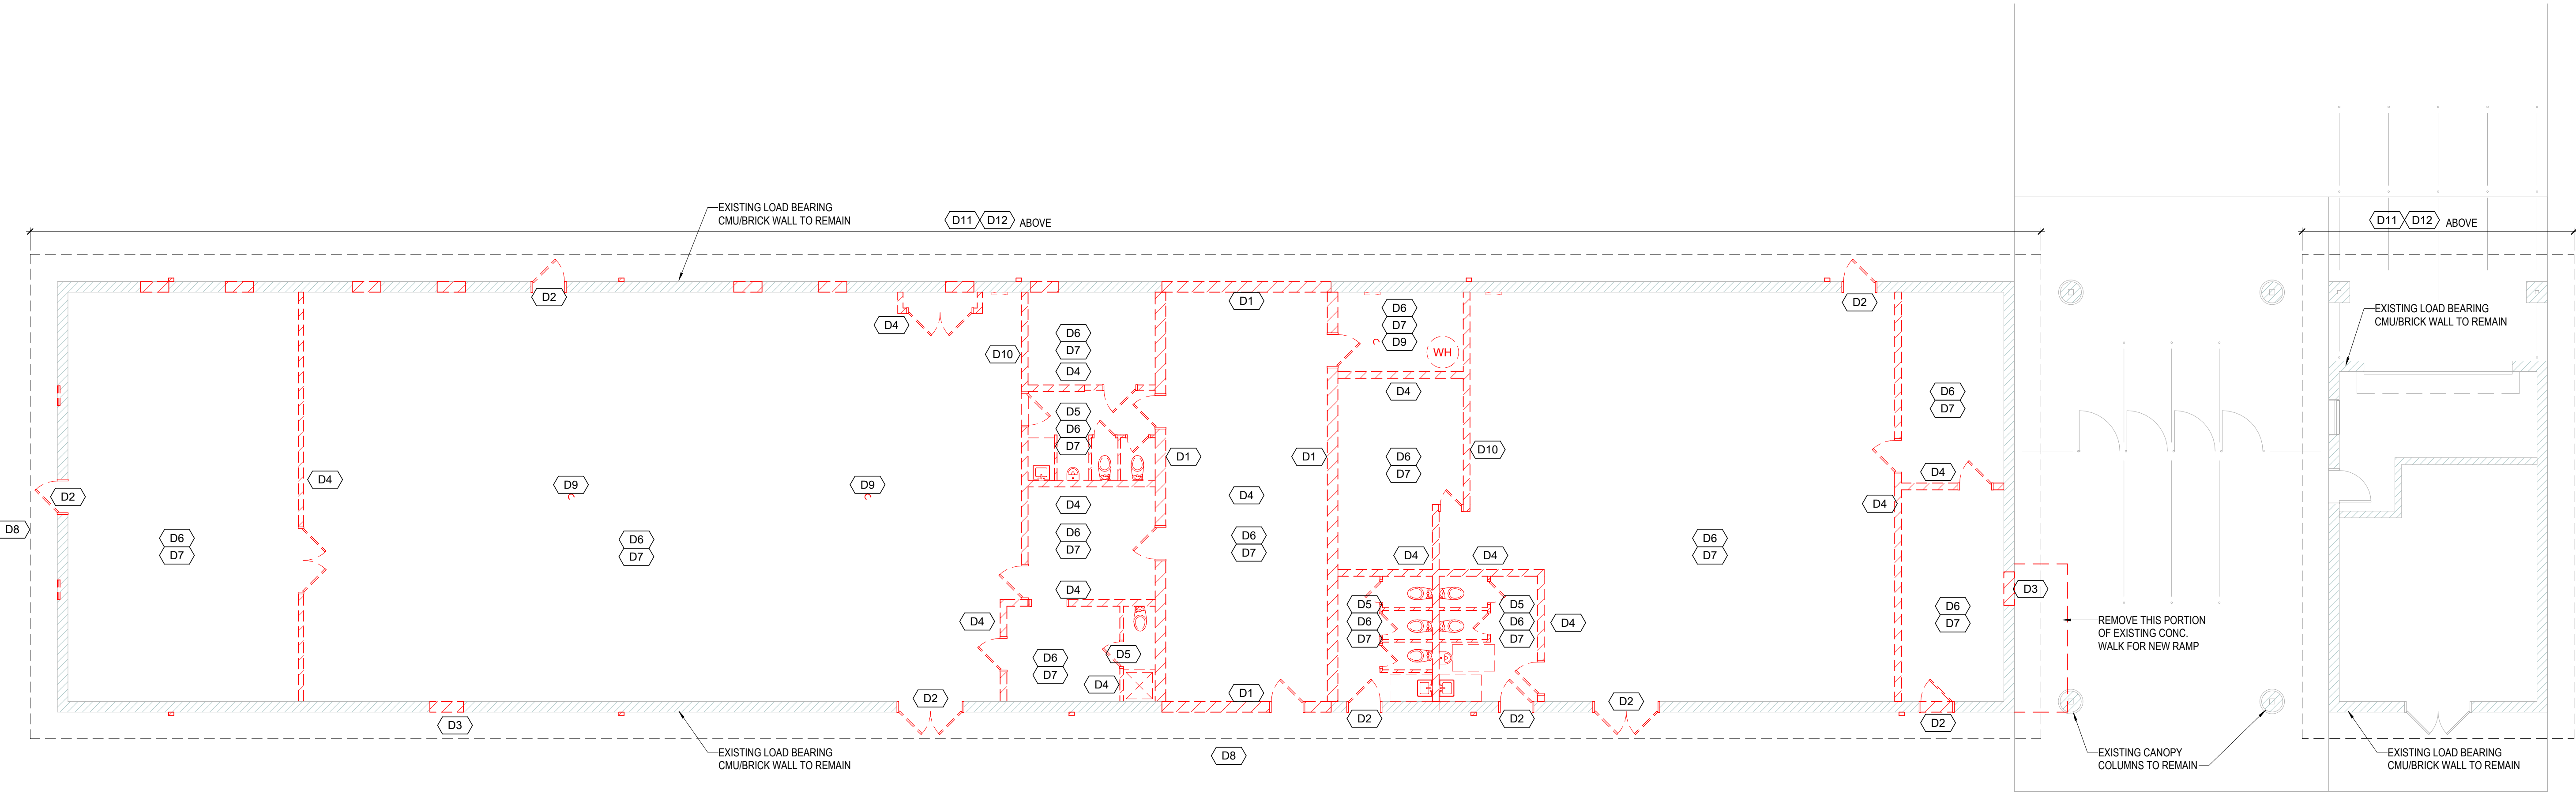

Architectural Registration No. 9020

CLIENT HENRY COUNTY SCHOOLS		
DATE 06 / 18 / 2026		PROJECT NUMBER 250306
DRAWING HISTORY		
No.	Description	Date
CHECKED BY: RV		
DRAWN BY: KW		