




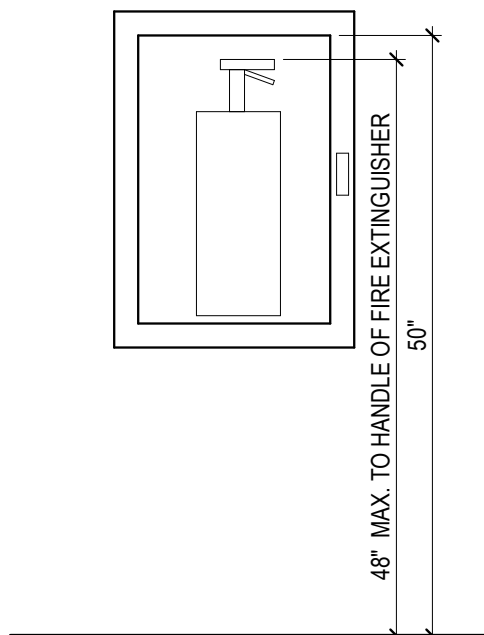

NOTE:
1. IN FIRE RATED WALLS PROVIDE FIRE RATED CABINETS TO MATCH RATING OF WALL

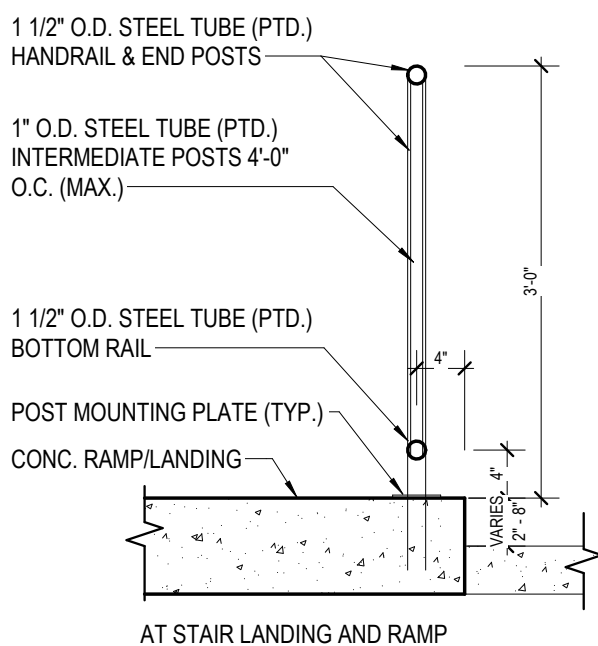

FLOOR PLAN LEGEND

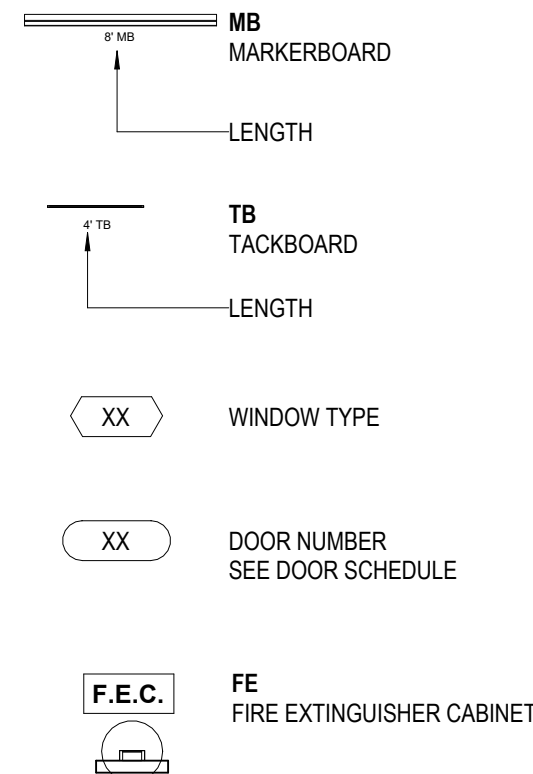

PLAN KEYNOTES (This Sheet Only)


Note Number	Note Text
1	COMMEMORATIVE PLAQUE. SEE DETAIL 07/AG051
2	DRINKING FOUNTAINS. SEE PLUMBING.
3	REFRIGERATOR. N.I.C.
4	OFFICE COPIER. N.I.C.
5	HANGING ROD WITH WOOD SHELF ABOVE. SEE 8/A-902
6	EVIDENCE LOCKERS
7	ROLLER WINDOW SHADES
8	EXISTING LOAD BEARING CMU WALL WITH FACE BRICK. CLEAN EXISTING FACE BRICK AS PER SPECIFICATIONS. TYPICAL FULL PERIMETER SERVICE/TELLER WINDOW (A03). SEE SPECS.
9	
10	FILL EXISTING DOOR/LLOUVER OPENING WITH CMU/BRICK TO MATCH EXISTING WALL. TOOTH BRICK INTO ADJACENT FACE BRICK TO BLEND INTO EXISTING BRICK

GENERAL ARCH PLAN NOTES

- DO NOT SCALE DRAWINGS. WRITTEN DIMENSIONS TAKE PRECEDENCE. CONTACT ARCH IF CLARIFICATION IS NECESSARY IN ORDER TO DETERMINE THE INTENT OF THE CONTRACT DOCUMENTS.
- DRAWINGS NOTED AS "N.I.S" OR "N.I.S" ARE NOT TO SCALE.
- ALL DIMENSIONS ARE TO STRUCTURAL COLUMN LINES OR THE SURFACE OF PARTITION ASSEMBLY U.N.O.
- FIELD VERIFY ALL DIMENSIONS AND EXISTING CONDITIONS BEFORE COMMENCING WORK. NOTIFY ARCHITECT OF ANY DISCREPANCIES PRIOR TO PROCEEDING WITH AFFECTED WORK.
- NOTES OR DIMENSIONS NOTED AS "TYPICAL" OR "TYP" OR "TYP" SHALL APPLY TO CONDITIONS THAT ARE THE SAME OR SIMILAR.
- DIMENSIONS NOTED AS "FIELD VERIFY" OR "F.V." OR "V.P." SHALL BE MEASURED AND CONFIRMED AT THE PROJECT SITE BY THE CONTRACTOR AND REVIEWED WITH THE ARCH. BEFORE INCORPORATING INTO THE WORK.
- DIMENSIONS NOTED AS "CLEAR" OR "CLEAR INSIDE" OR "CLR" REQUIRE SPECIFIC COORDINATION AMONG DISCIPLINES AND/OR MANUFACTURERS.
- ALL INTERIOR PARTITIONS THIS SHEET, EXCEPT FOR FURR-OUT PARTITIONS, SHALL BE PARTITION TYPE S6 U.N.O.
- ALIGN FINISHED FACE OF WALLS WHERE WALL PARTITIONS OF DIFFERING THICKNESS ABUT AND/OR ADJOIN IN THE SAME PLANE.
- PROVIDE AND INSTALL CONTINUOUS REVEAL TRIM AT JOINT WHERE GYPSUM BOARD WALL PARTITIONS ABUT AND/OR ADJOIN MASONRY WALL PARTITIONS IN THE SAME PLANE.
- ALL INTERIOR CMU OUTSIDE CORNERS SHALL HAVE BULLNOSE U.N.O.
- ALL DOORS SHALL BE SET 4 INCHES OFF THE ADJACENT PERPENDICULAR WALL ON THE HINGE SIDE OF THE DOOR U.N.O. NOTIFY ARCH OF ANY DOOR-RELATED CONFLICTS, INCLUDING BUT NOT LIMITED TO CONFLICTS CONCERNING ACCESSIBILITY STANDARDS.
- ALL DOOR THRESHOLDS AT ALL EXTERIOR DOORS SHALL BE SET IN FULL BED OF SEALANT.
- COORDINATE ALL ROOF DRAIN LEADER LOCATIONS WITH FLOOR PLAN PRIOR TO FLOOR SLAB CONSTRUCTION.
- ALL FLOOR SLOPES TO FLOOR DRAINS SHALL NOT EXCEED 1/8".
- PROVIDE AND INSTALL SELF-LEVELING UNDERLAYMENT WHERE UNEVEN FLOOR SLAB EXISTS PRIOR TO INSTALLATION OF FLOOR FINISHES.
- COORDINATE HOUSEKEEPING PAD LOCATIONS AND DIMENSIONS WITH EQUIPMENT TO BE INSTALLED.
- ALL REQUIRED ACCESSIBLE CLEARANCES FOR ALL ITEMS, INCLUDING BUT NOT LIMITED TO ALL COUNTER TOPS, ALL PLUMBING FIXTURES, ALL DRINKING FOUNTAINS, ALL ELECTRIC WATER COOLERS, ALL LAVATORIES, ALL URINALS, ALL TOILETS SHALL BE STRICTLY ENFORCED.
- APPLY BITUMINOUS COATING TO ALL CONCEALED STRUCTURAL STEEL MEMBERS AT ALL EXTERIOR CANOPY LOCATIONS.
- REFER TO OTHER DISCIPLINE DOCUMENTS FOR ADDITIONAL SCOPE OF WORK.
- PROVIDE WINDOW BLINDS FOR ALL WINDOW TYPES A01. SEE SPECIFICATIONS.
- CONTRACTOR SHALL FULLY CLEAN EXTERIOR OF THE EXISTING BUILDING, INCLUDING FACE BRICK, CONCRETE SIDEWALKS & RAMPS, DOORS, WINDOWS, GATES, & OVERHEAD CANOPY. REFER TO SPECIFICATIONS OF CLEANING REQUIREMENTS.
- ALL EXISTING EXTERIOR STEEL LINTELS, HANDRAILS, GATES, DOORS & WINDOWS SHALL BE PREPPED AS SPECIFIED AND REPAINTED

03 FIRE EXTINGUISHER DETAIL
3/4" = 1'-0"

02 HANDRAIL SECTION @ LANDING & RAMP
3/4" = 1'-0"

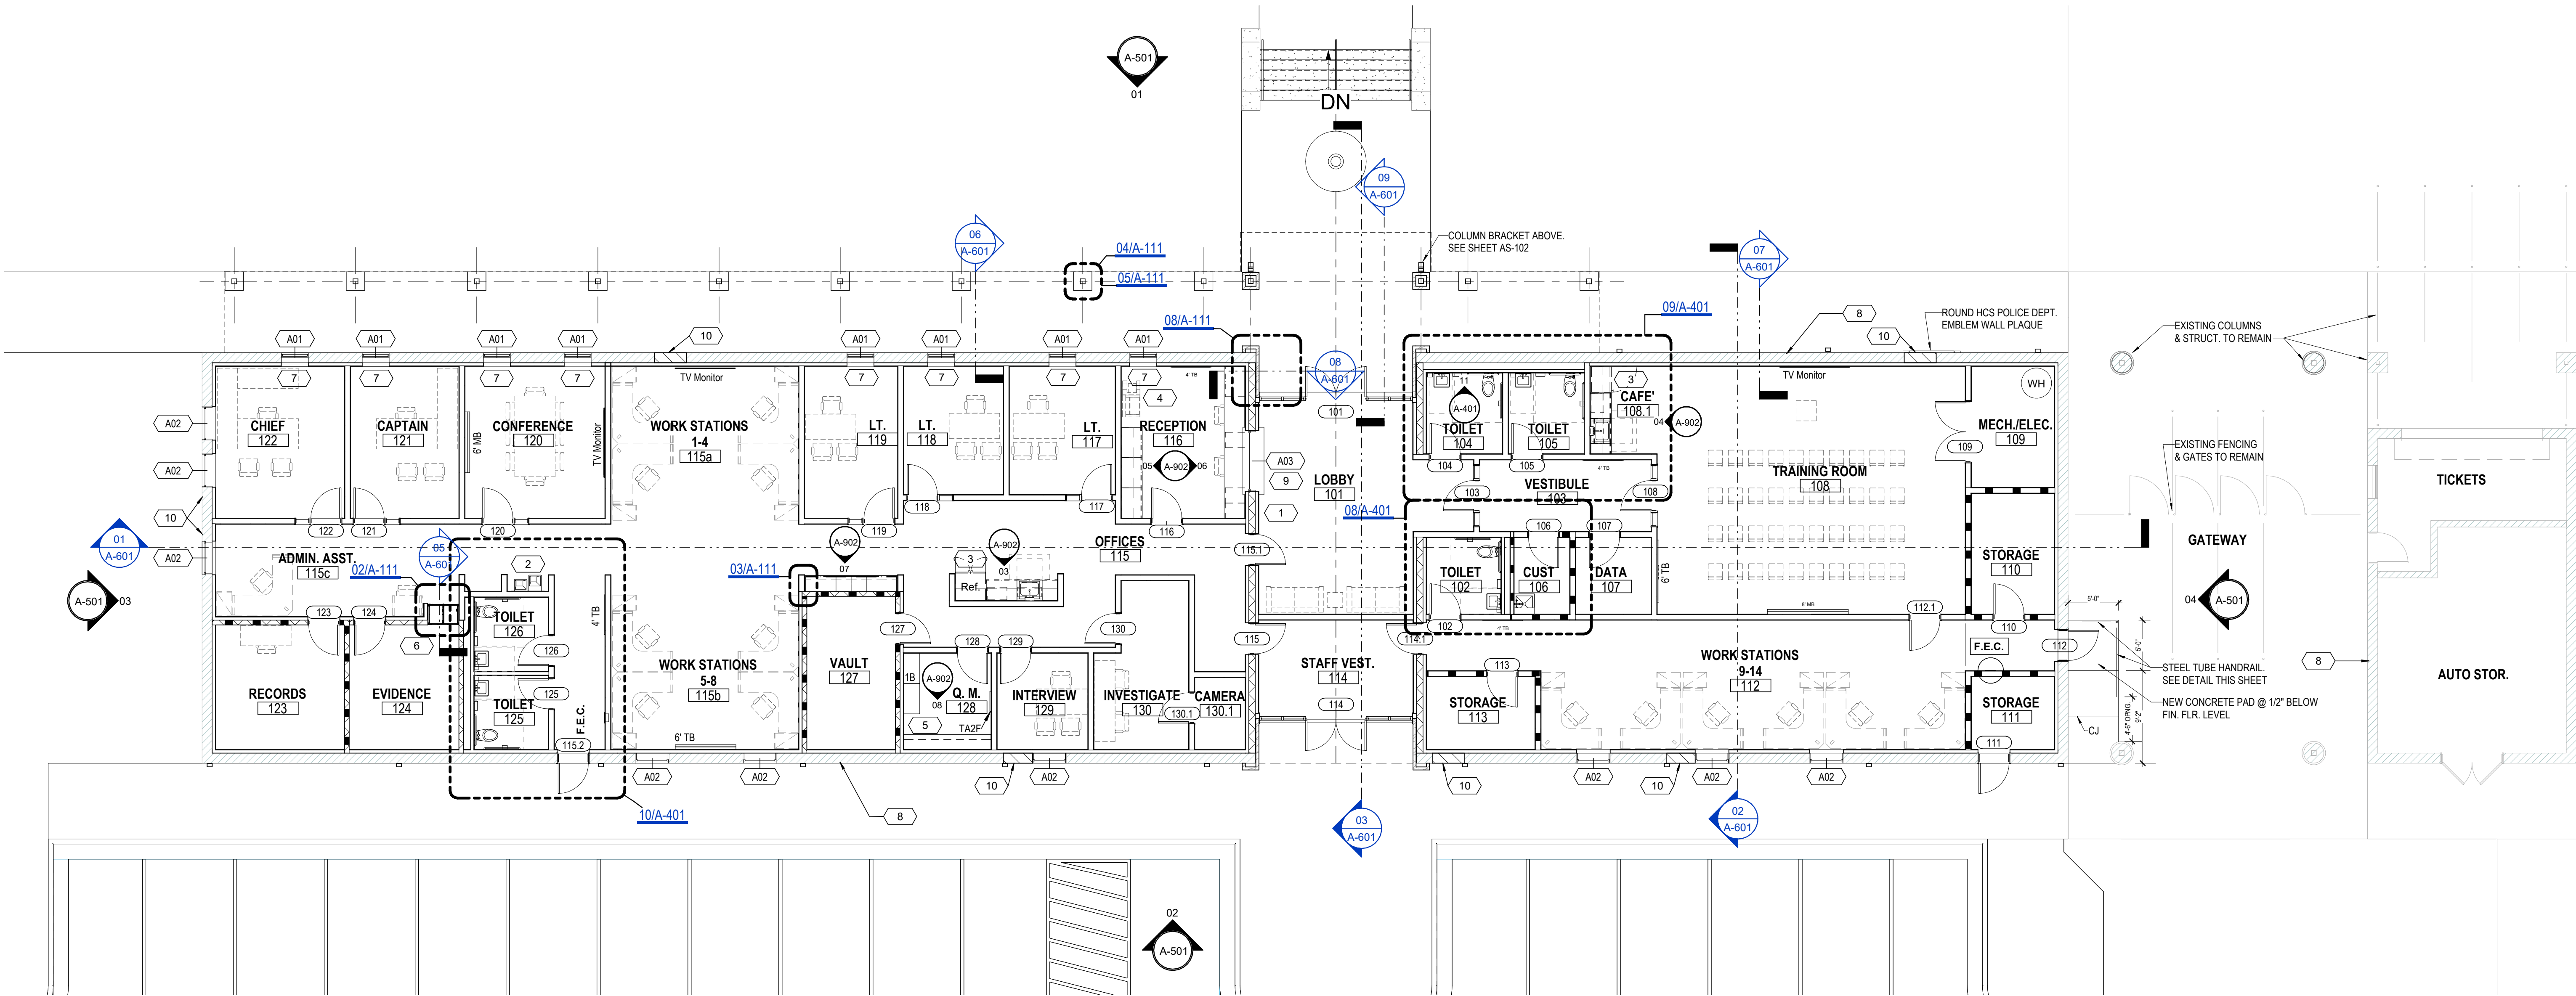

01 FLOOR PLAN
1/8" = 1'-0"



www.rbr.com


770-227-5473

GRIFFIN, GA

HCS - SRO Offices - Warhawk Fieldhouse Modifications

47 LEMON STREET MCDONOUGH, GA 30253

FINAL DOCUMENTS

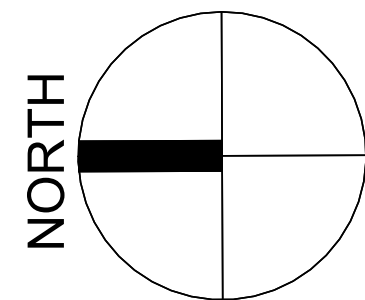

Architectural Registration No. 9020

CLIENT HENRY COUNTY SCHOOLS		
DATE 06 / 18 / 2026		PROJECT NUMBER 250306
DRAWING HISTORY		
No.	Description	Date
CHECKED BY: RV		
DRAWN BY: KW		

FLOOR PLAN

A-101