


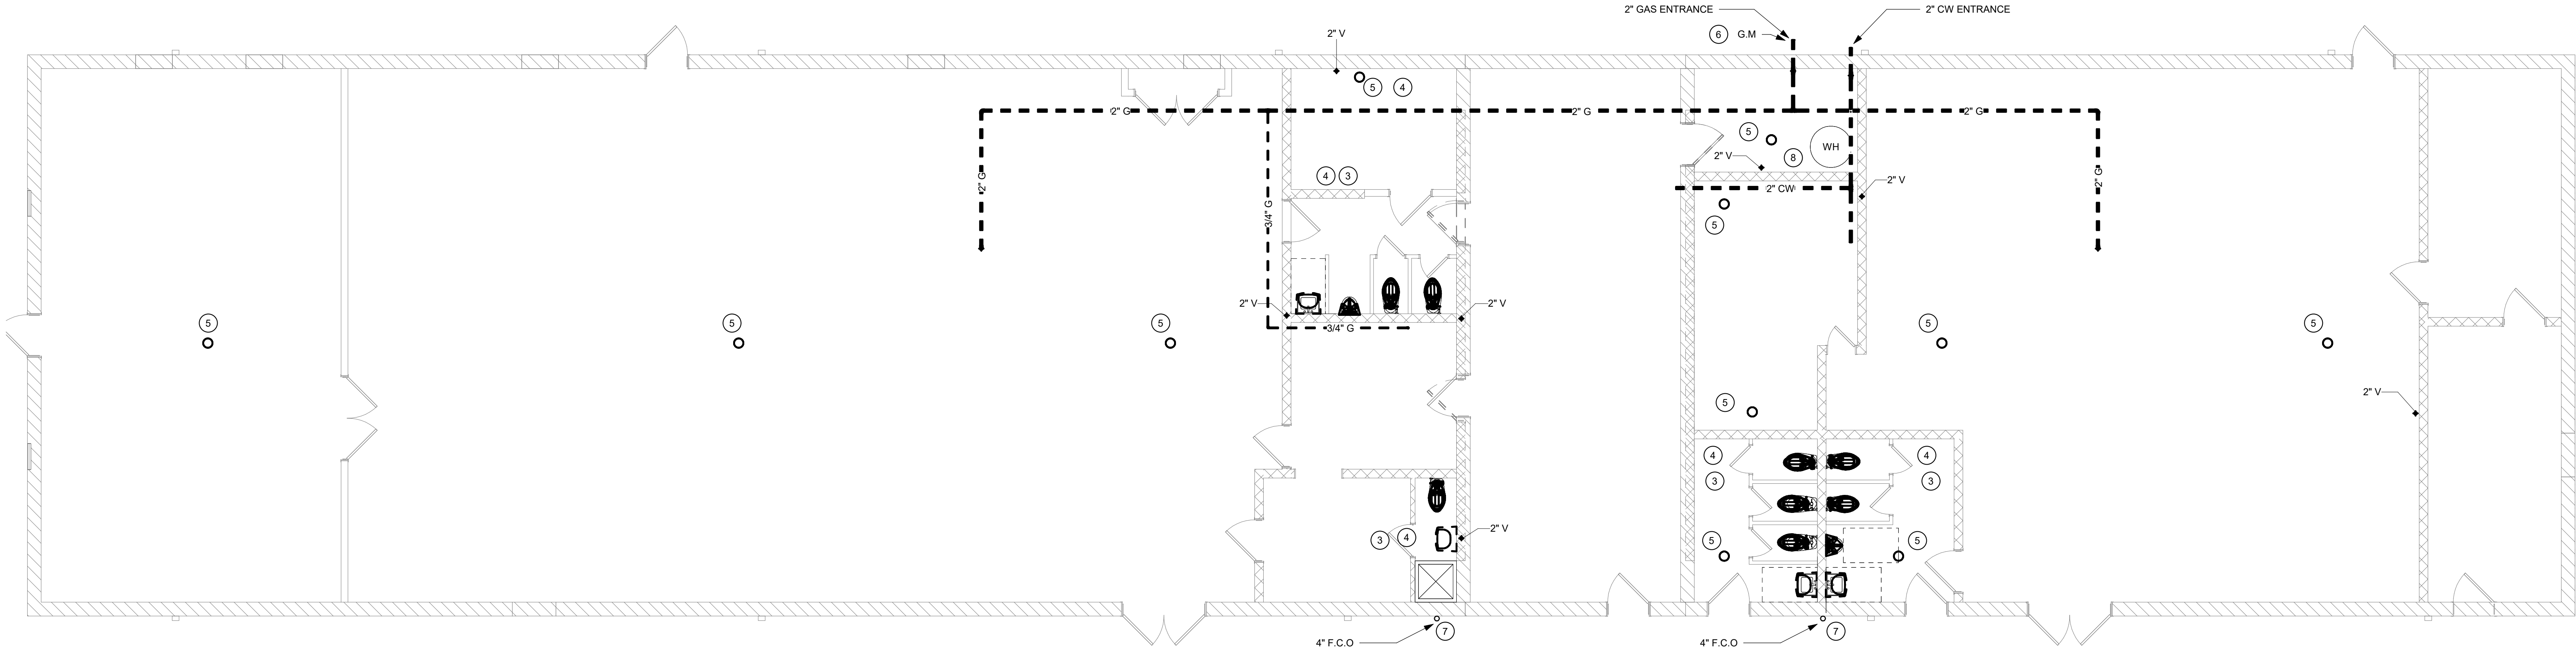

PLUMBING OVERALL DEMOLITION FLOOR PLAN
SCALE: 3/16" = 1'-0"


NOTES: (THIS SHEET ONLY)

1. REMOVE ALL WATER PIPING FROM BUILDING BACK TO ENTRANCE LOCATION AND CAP OUTSIDE A MINIMUM OF 5'-0" AWAY FROM BUILDING.
2. GENERAL: REMOVE ALL ABOVE SLAB WASTE AND VENT PIPING.
3. REMOVE ALL WASTE PIPING FROM BUILDING AND CAP OUTSIDE BELOW GRADE MINIMUM OF 5' FT FROM BUILDING.
4. REMOVE EXISTING PLUMBING FIXTURES AND ALL ASSOCIATE WASTE, WATER, AND VENT PIPING.
5. EXISTING FLOOR DRAINS TO BE REMOVED. REMOVE PIPING BELOW FINISHED FLOOR.
6. REMOVE ALL GAS PIPING FROM BUILDING BACK TO GAS METER SET. CONTRACTOR SHALL CONTACT LOCAL UTILITY AND MAKE ARRANGMENT FOR REMOVAL OF EXISTING GAS METER AND SERVICE.
7. EXISTING CLEANOUTS TO BE REMOVED. CAP PIPING BELOW FINISHED GRADE.
8. REMOVE EXISTING 125 GALLON GAS FIRED WATER HEATER AND ALL ASSOCIATED PIPING AND FLUE THRU ROOF. PATCH ROOF TO MATCH EXISTING.



HCS - SRO Offices - Warhawk Fieldhouse
Modifications
47 LEMON STREET MCDONOUGH, GA 30253

BID SET

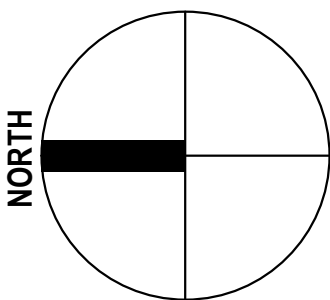

CLIENT		
HENRY COUNTY SCHOOLS		
DATE		PROJECT NUMBER
06/18/2026		250306
DRAWING HISTORY		
No.	Description	Date
CHECKED BY: JMC		
DRAWN BY: BRP		

PLUMBING OVERALL
DEMOLITION PLAN

PD-101