
 


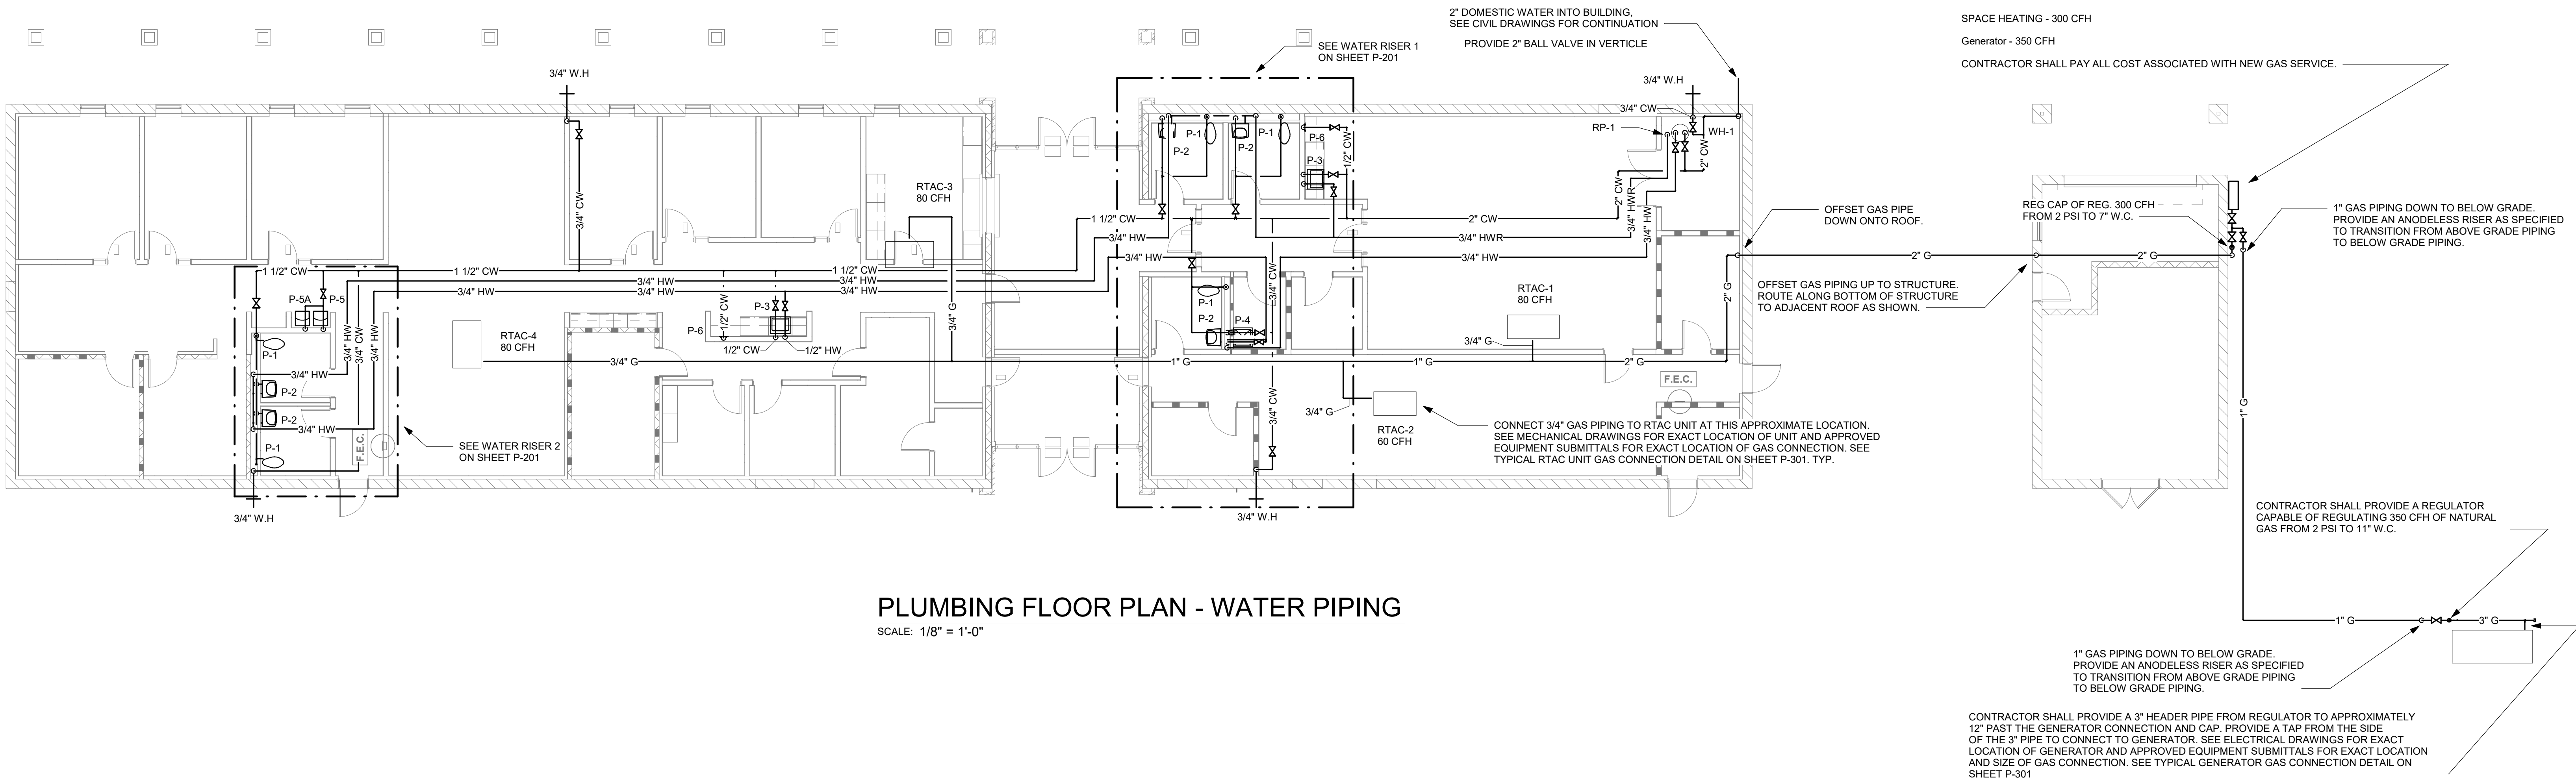


PLUMBING FLOOR PLAN - WATER PIPING
SCALE: 1/8" = 1'-0"



HCS - SRO Offices - Warhawk Fieldhouse
Modifications
47 LEMON STREET MCDONOUGH, GA 30253

BID SET

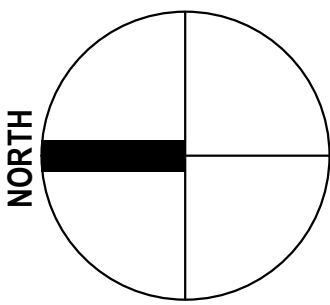

CLIENT		
HENRY COUNTY SCHOOLS		
DATE	PROJECT NUMBER	
06/18/2026	250306	
DRAWING HISTORY		
No.	Description	Date
CHECKED BY: JMC		
DRAWN BY: BRP		

PLUMBING FLOOR
PLAN - WATER PIPING

P-101