



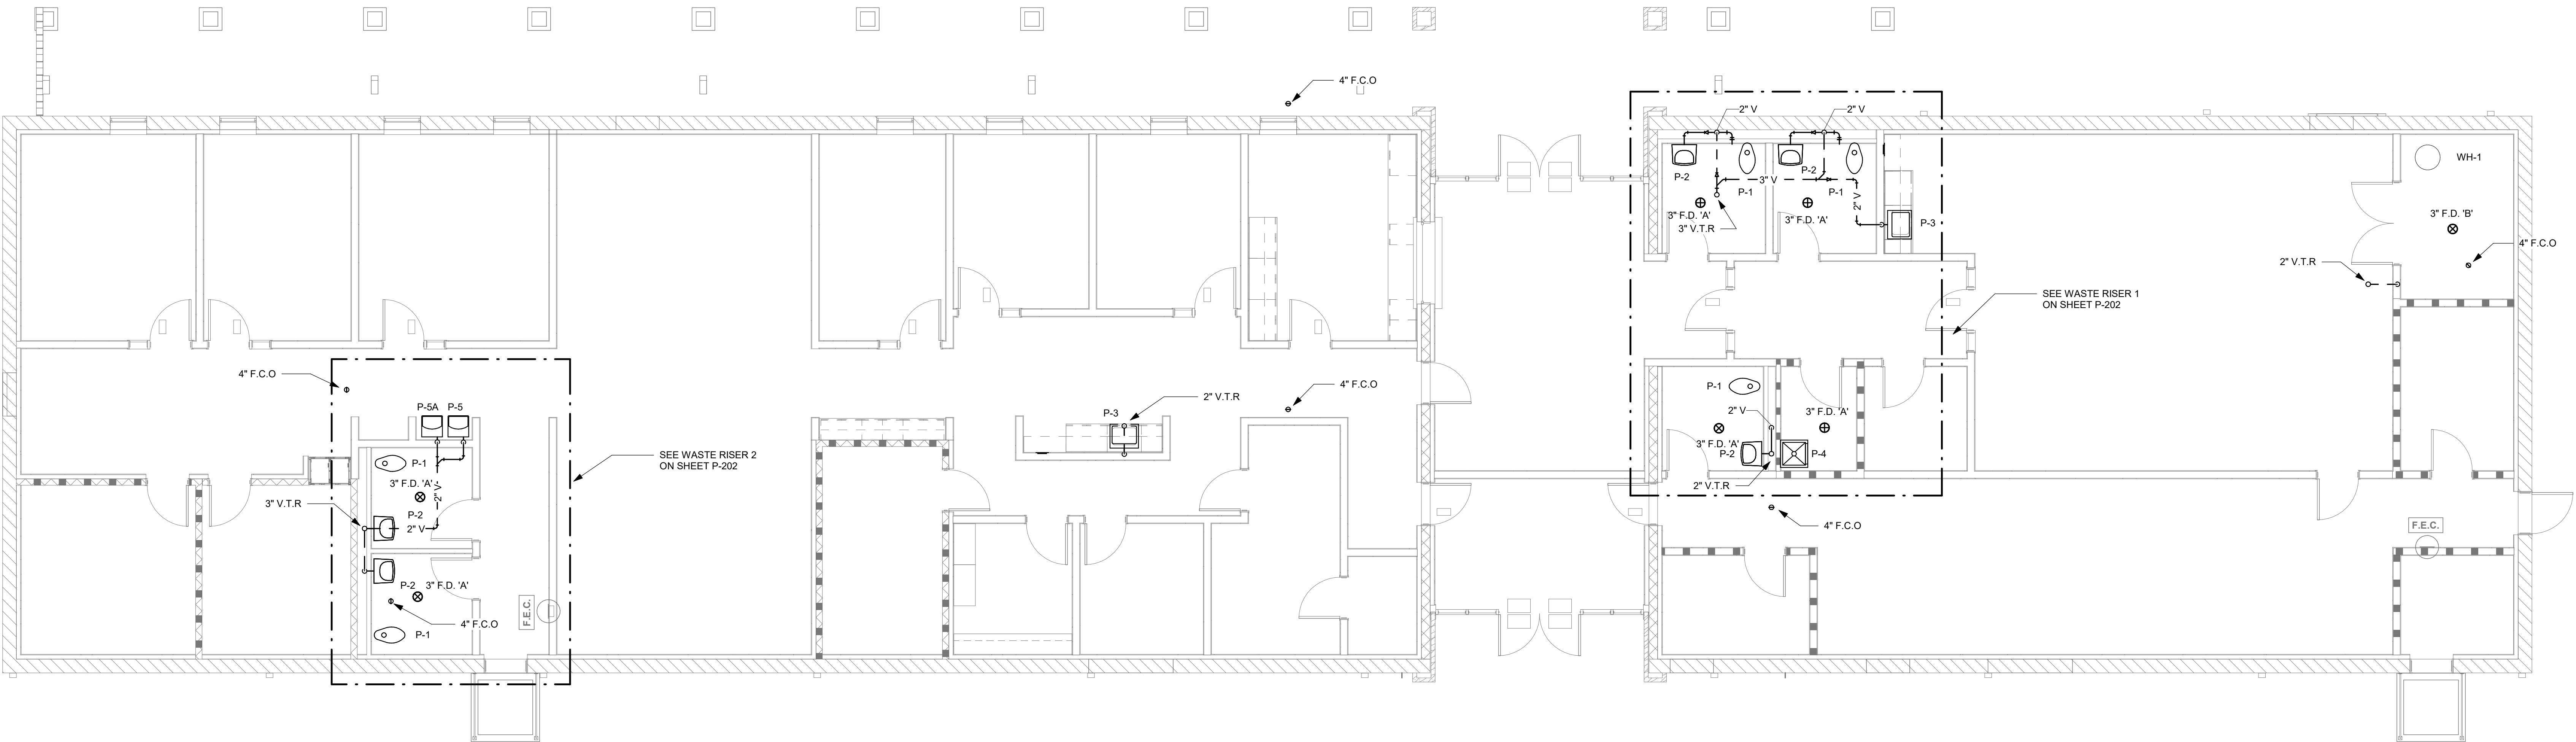



PLUMBING FLOOR PLAN - WASTE PIPING - ABOVE SLAB
SCALE: 3/16" = 1'-0"

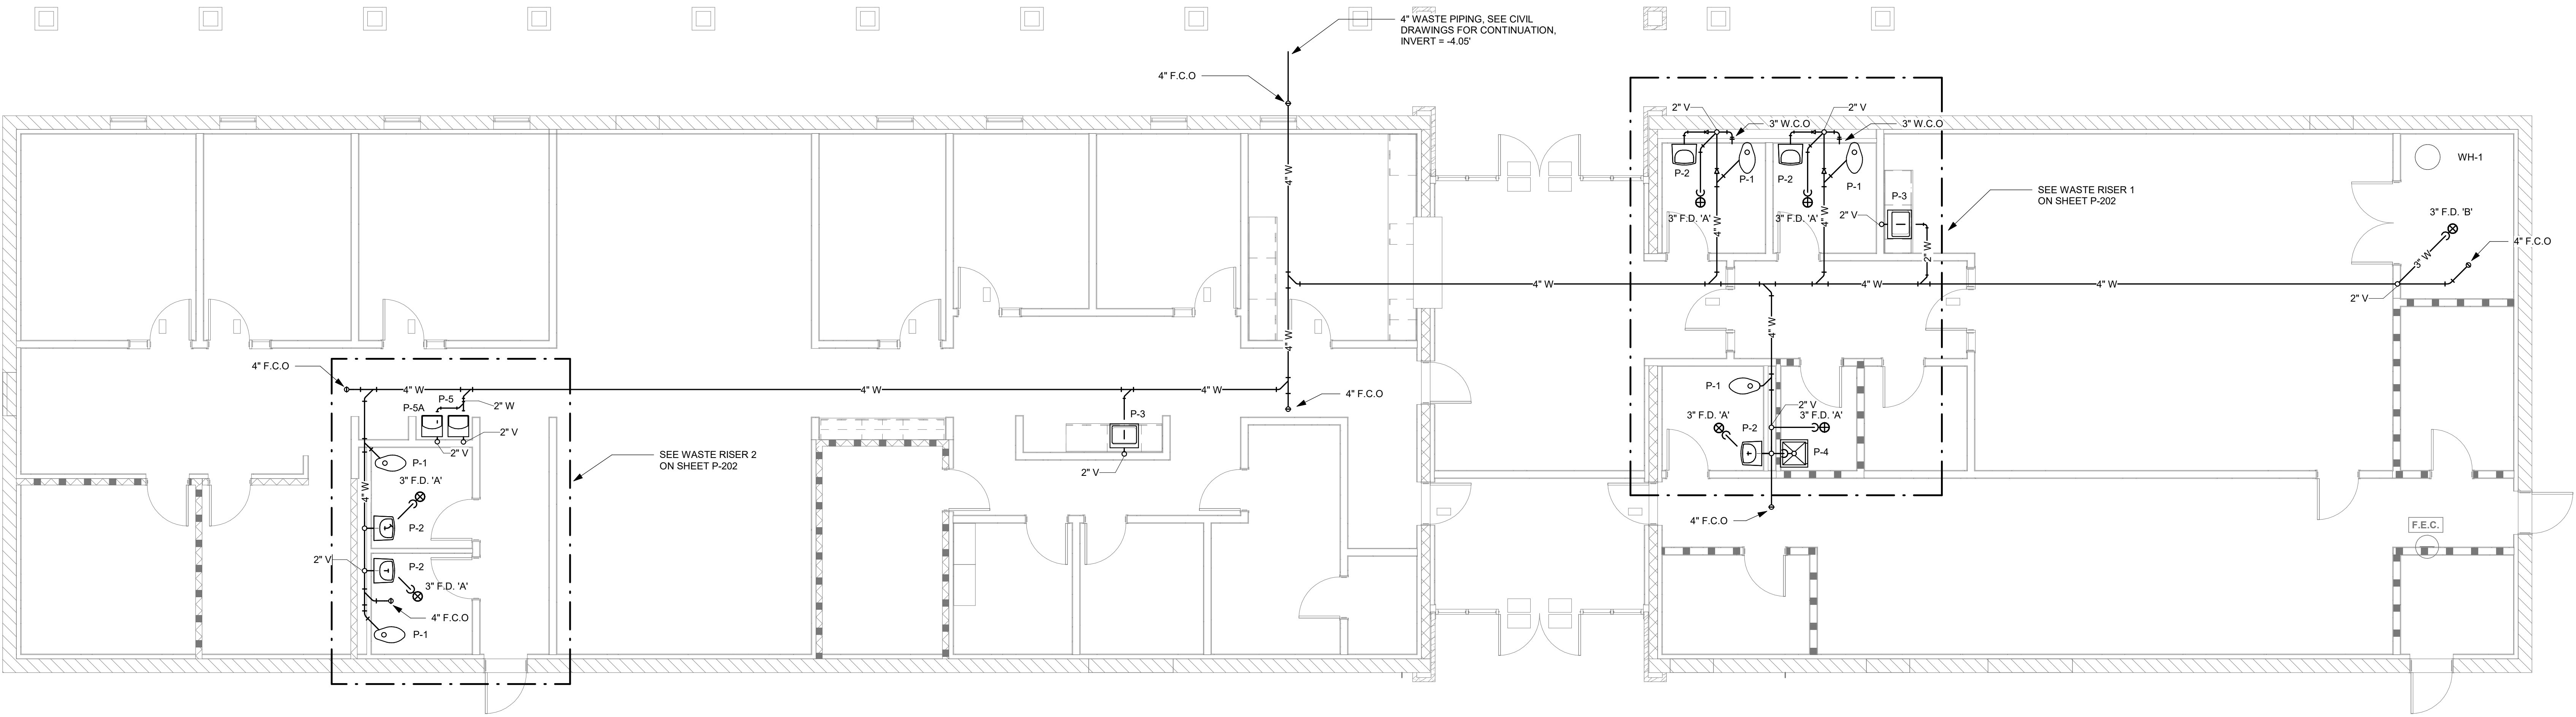

PLUMBING FLOOR PLAN - WASTE PIPING - BELOW SLAB
SCALE: 3/16" = 1'-0"



HCS - SRO Offices - Warhawk Fieldhouse
Modifications
47 LEMON STREET MCDONOUGH, GA 30253
BID SET

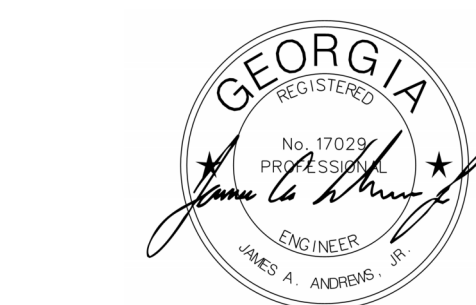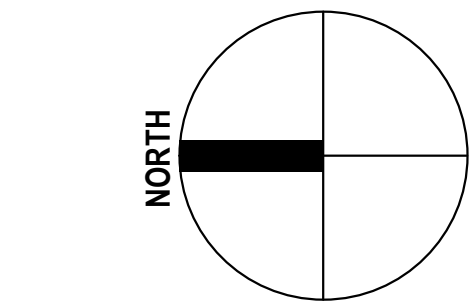

CLIENT HENRY COUNTY SCHOOLS		
DATE 06/18/2026		PROJECT NUMBER 250306
DRAWING HISTORY		
No.	Description	Date
CHECKED BY: JMC		
DRAWN BY: BRP		

PLUMBING FLOOR
PLANS - WASTE
PIPING