


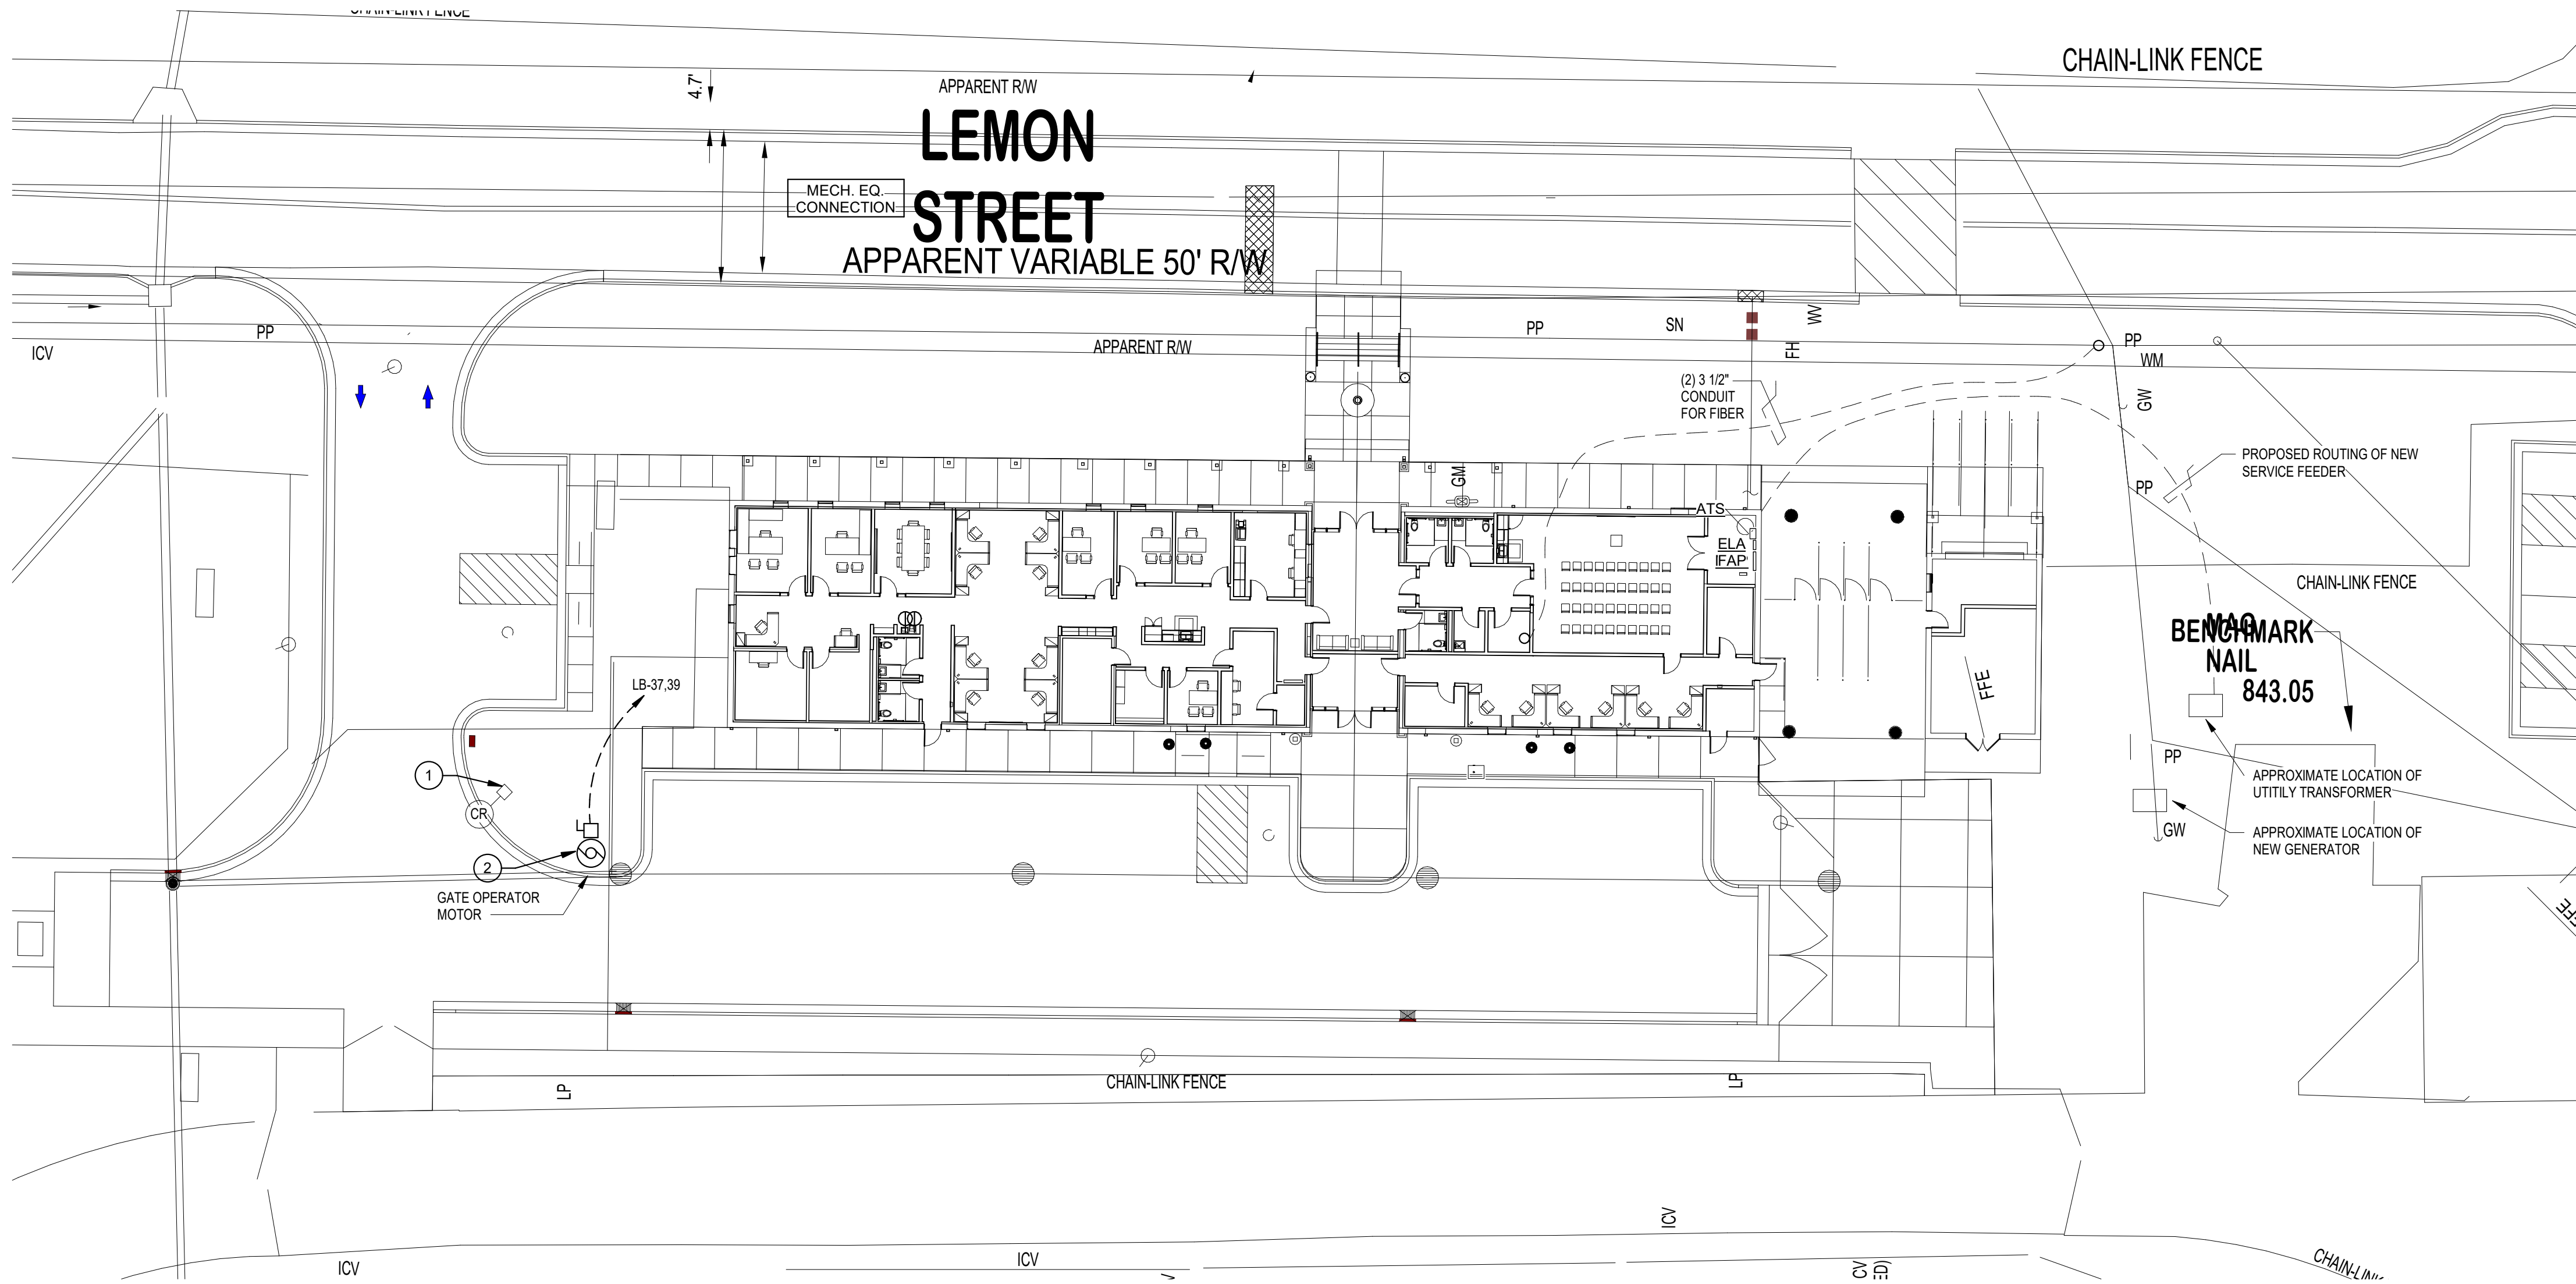

ELECTRICAL SITE PLAN
SCALE: 1" = 20'-0"

GENERAL PARKING LOT AND DRIVEWAY LIGHTING NOTE

UTILITY COMPANY SHALL DEVELOP SITE LIGHTING PROPOSAL, INCLUDING A POINT-BY-POINT FOOTCANDLE ANALYSIS. PROPOSAL SHALL BE SUBMITTED TO OWNER FOR HIS REVIEW AND ACCEPTANCE.

DEMOLITION NOTES: (THIS SHEET ONLY)


- REMOVE ELECTRICAL SYSTEMS INCLUDING OUTLETS, PANELS, RACEWAY, FEEDER AND BRACH CIRCUIT IN ITS ENTIRETY.
- REMOVE ELECTRICAL LOW VOLTAGE SYSTEM INCLUDING DATA, FIRE ALARM, INTERCOM ETC. PANELS RACEWAY CABLING IN ITS ENTIRETY.
- REMOVE ELECTRICAL LIGHTING INCLUDING LIGHT FIXTURES, SWITCHES, CONTROLS, PANEL AND BRACH CIRCUIT IN ITS ENTIRETY.

NOTES: (THIS SHEET ONLY)

- PROVIDE GOOSENECK PAD MOUNT PEDESTAL BY VIKING (MODEL # VE-GNP) AND SURFACE BOXES BY VIKING (IF VE-SX) OR EQUAL FOR CARD READERS. PROVIDE 12" SQUARE CONCRETE PAD FLUSH WITH GROUND AND ALL MOUNTING HARDWARE FOR CIVL PROVIDED CARD READERS. COORDINATE EXACT LOCATION WITH THE OWNER.
- PROVIDE 30A/2P HEAVY DUTY DISCONNECT IN NEMA 3R ENCLOSURE FOR GATE OPERATOR MOTOR. COORDINATE EXACT LOCATION WITH THE GATE MOTOR INSTALLER. MAKE ALL CONNECTIONS. PROVIDE AND MOUNT TO STANCHION.

NOTES: (THIS SHEET ONLY)

- CONTRACTOR SHALL INSTALL EXTERNAL SURGE SUPPRESSION DEVICE WITHIN 2 FEET OF PANELBOARD.
- BERTHOLD GENERATOR CONNECTION CABINET W/ ENGINE START-STOP TERMINAL STRIP #W04-SS-M-3-6-13.
- MANUAL TRANSFER SWITCH DOUBLE THROW, 60A/3P/NEMA1.
- CONTRACTOR SHALL BOND THE NEUTRAL AND THE GROUND ONLY IN PANELBOARD MDP.
- GENERAL: SEE RESPECTIVE SPECIFICATION SECTIONS FOR GENERATOR AND ATS SIZING AND ELECTRICAL CHARACTERISTICS.

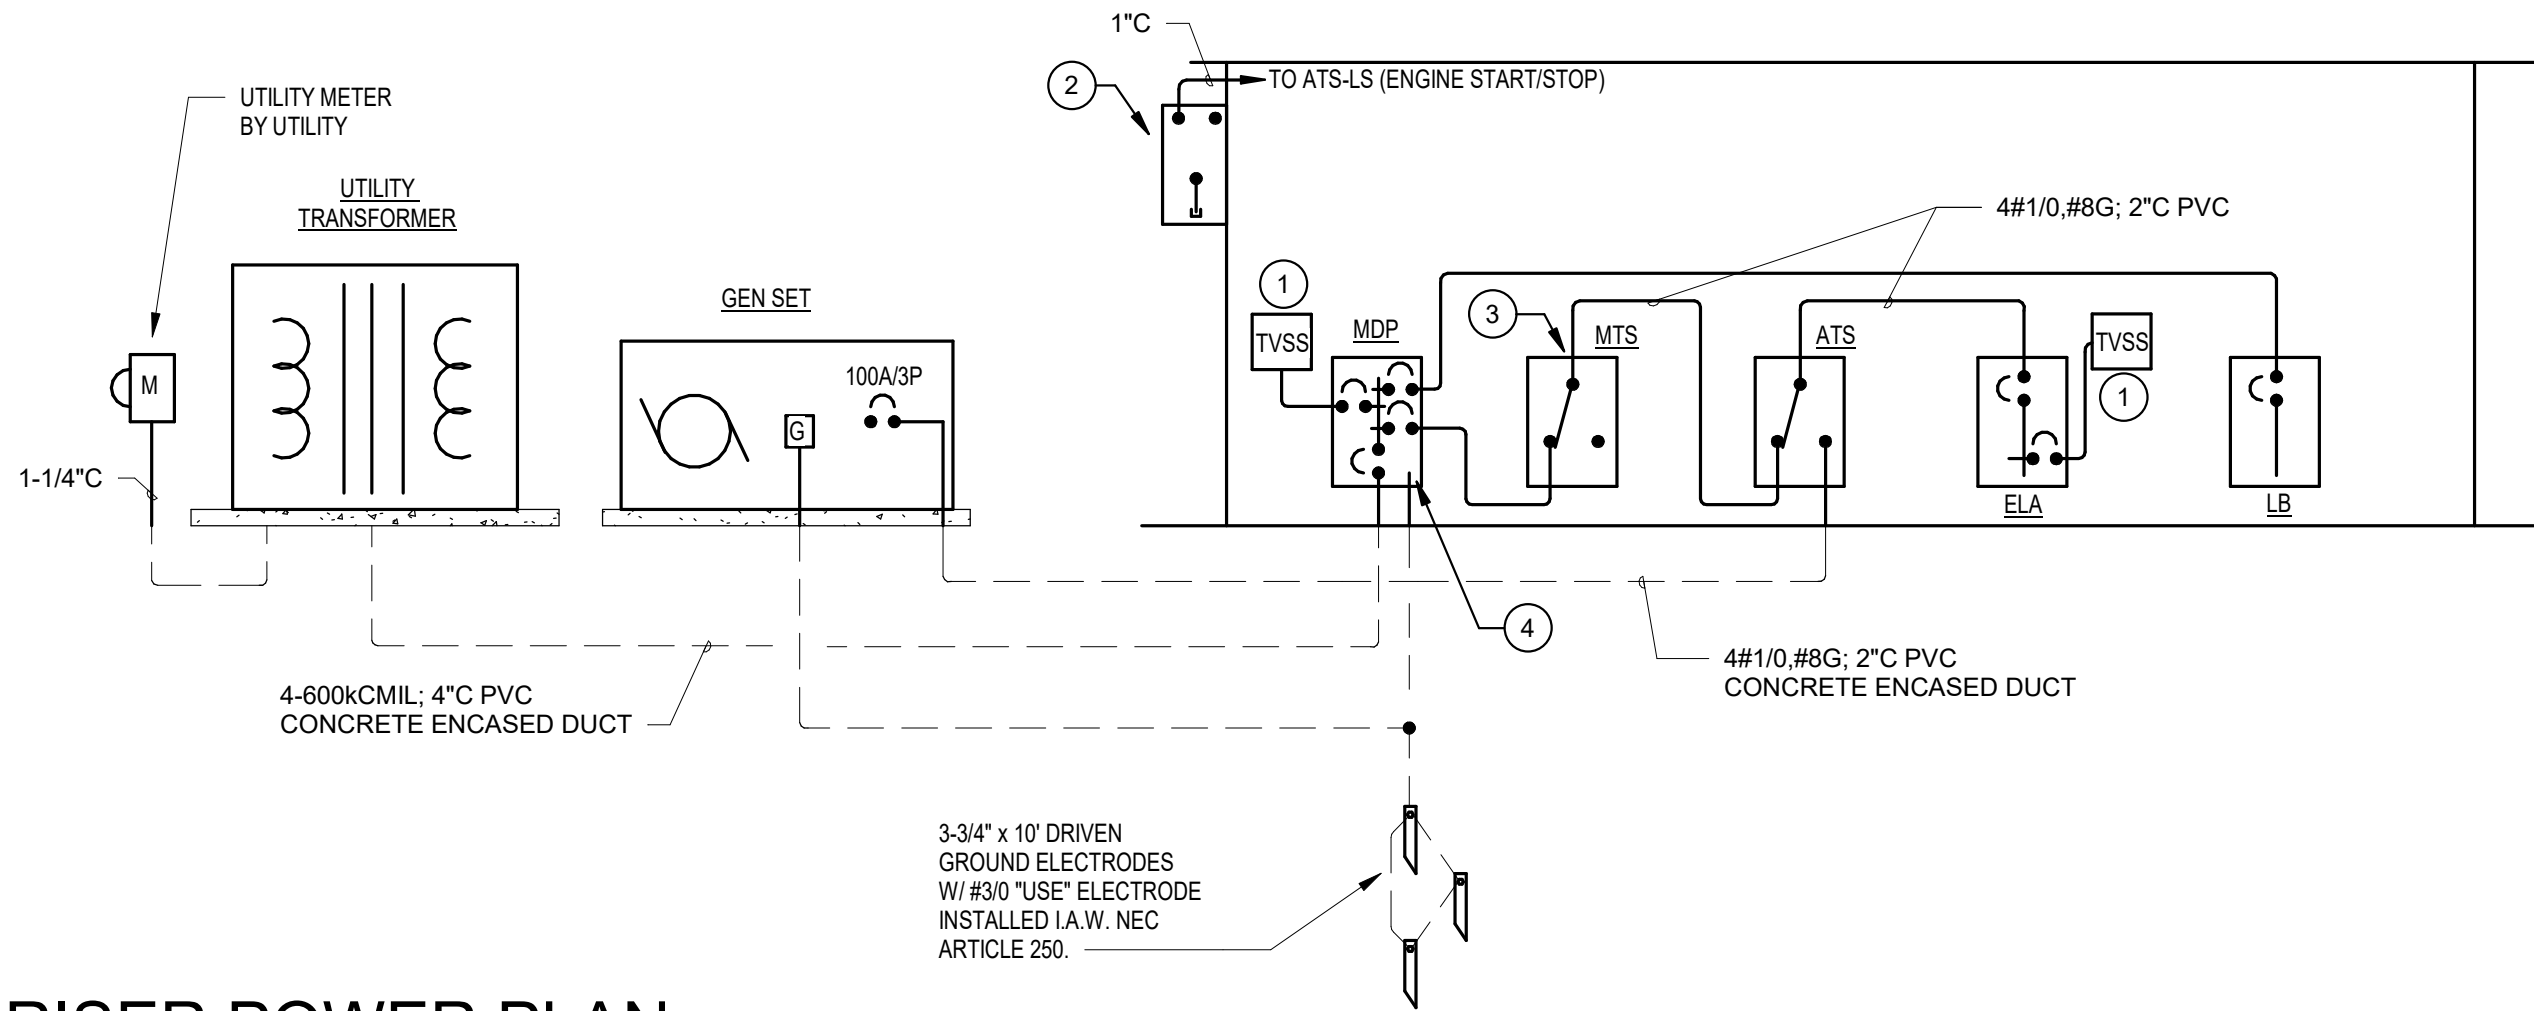

RISER POWER PLAN
SCALE: 12" = 1'-0"




HCS - SRO Offices - Warhawk Fieldhouse

Modifications

47 LEMON STREET MCDONOUGH, GA 30253

BID SET

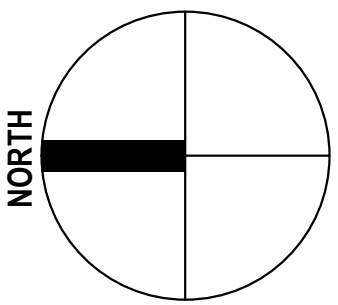

CLIENT		
HENRY COUNTY SCHOOLS		
DATE	PROJECT NUMBER	
06 / 18 / 2026	250306	
DRAWING HISTORY		
No.	Description	Date
CHECKED BY: NHO		
DRAWN BY: CTS		

ELECTRICAL SITE
PLAN

E001