



ARCHITECT

STAMP INVALID UNLESS SIGNED

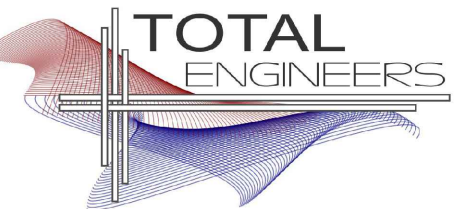

169 New Street, Macon, GA 31201  
(478) 741-4632 T.E. project # 25-007  
www.totalengineers.com  
GA COA NO # PEF009195 EXP: 06/30/2026

CONSULTANT

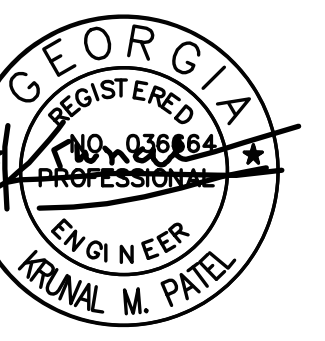

STAMP INVALID UNLESS SIGNED



10641 HIGHWAY 36  
COVINGTON, GA 30014  
770.786.3031

PLUMBING PLAN - SEWER

**Retrofit & Renovations for  
Madison Methodist Church  
Phase 2: Party Barn**  
1091 Confederate Highway  
Madison, Georgia 30650

JOB NO.: 02601  
DRAWN BY: KMP & MGT  
CHECKED BY: KMP

DESCRIPTION: SCH-REVIEW-P2

DATE: 12.15.25

DESCRIPTION: DD-REVIEW

DATE: 00.00.26

DESCRIPTION: CD-REVIEW

DATE: 00.00.26

DESCRIPTION: BID-CONSTRUCTION

DATE: 00.00.26

REVISIONS:

1 00.00.26

2

3

4

5

6


7

THESE DRAWINGS ARE THE PROPERTY OF GMARCHITECT AND ARE NOT TO BE REPRODUCED OR HELD WITHOUT PERMISSION AND CREDIT.  
COPYRIGHT © 2026

SHEET

**P1.0**

OF

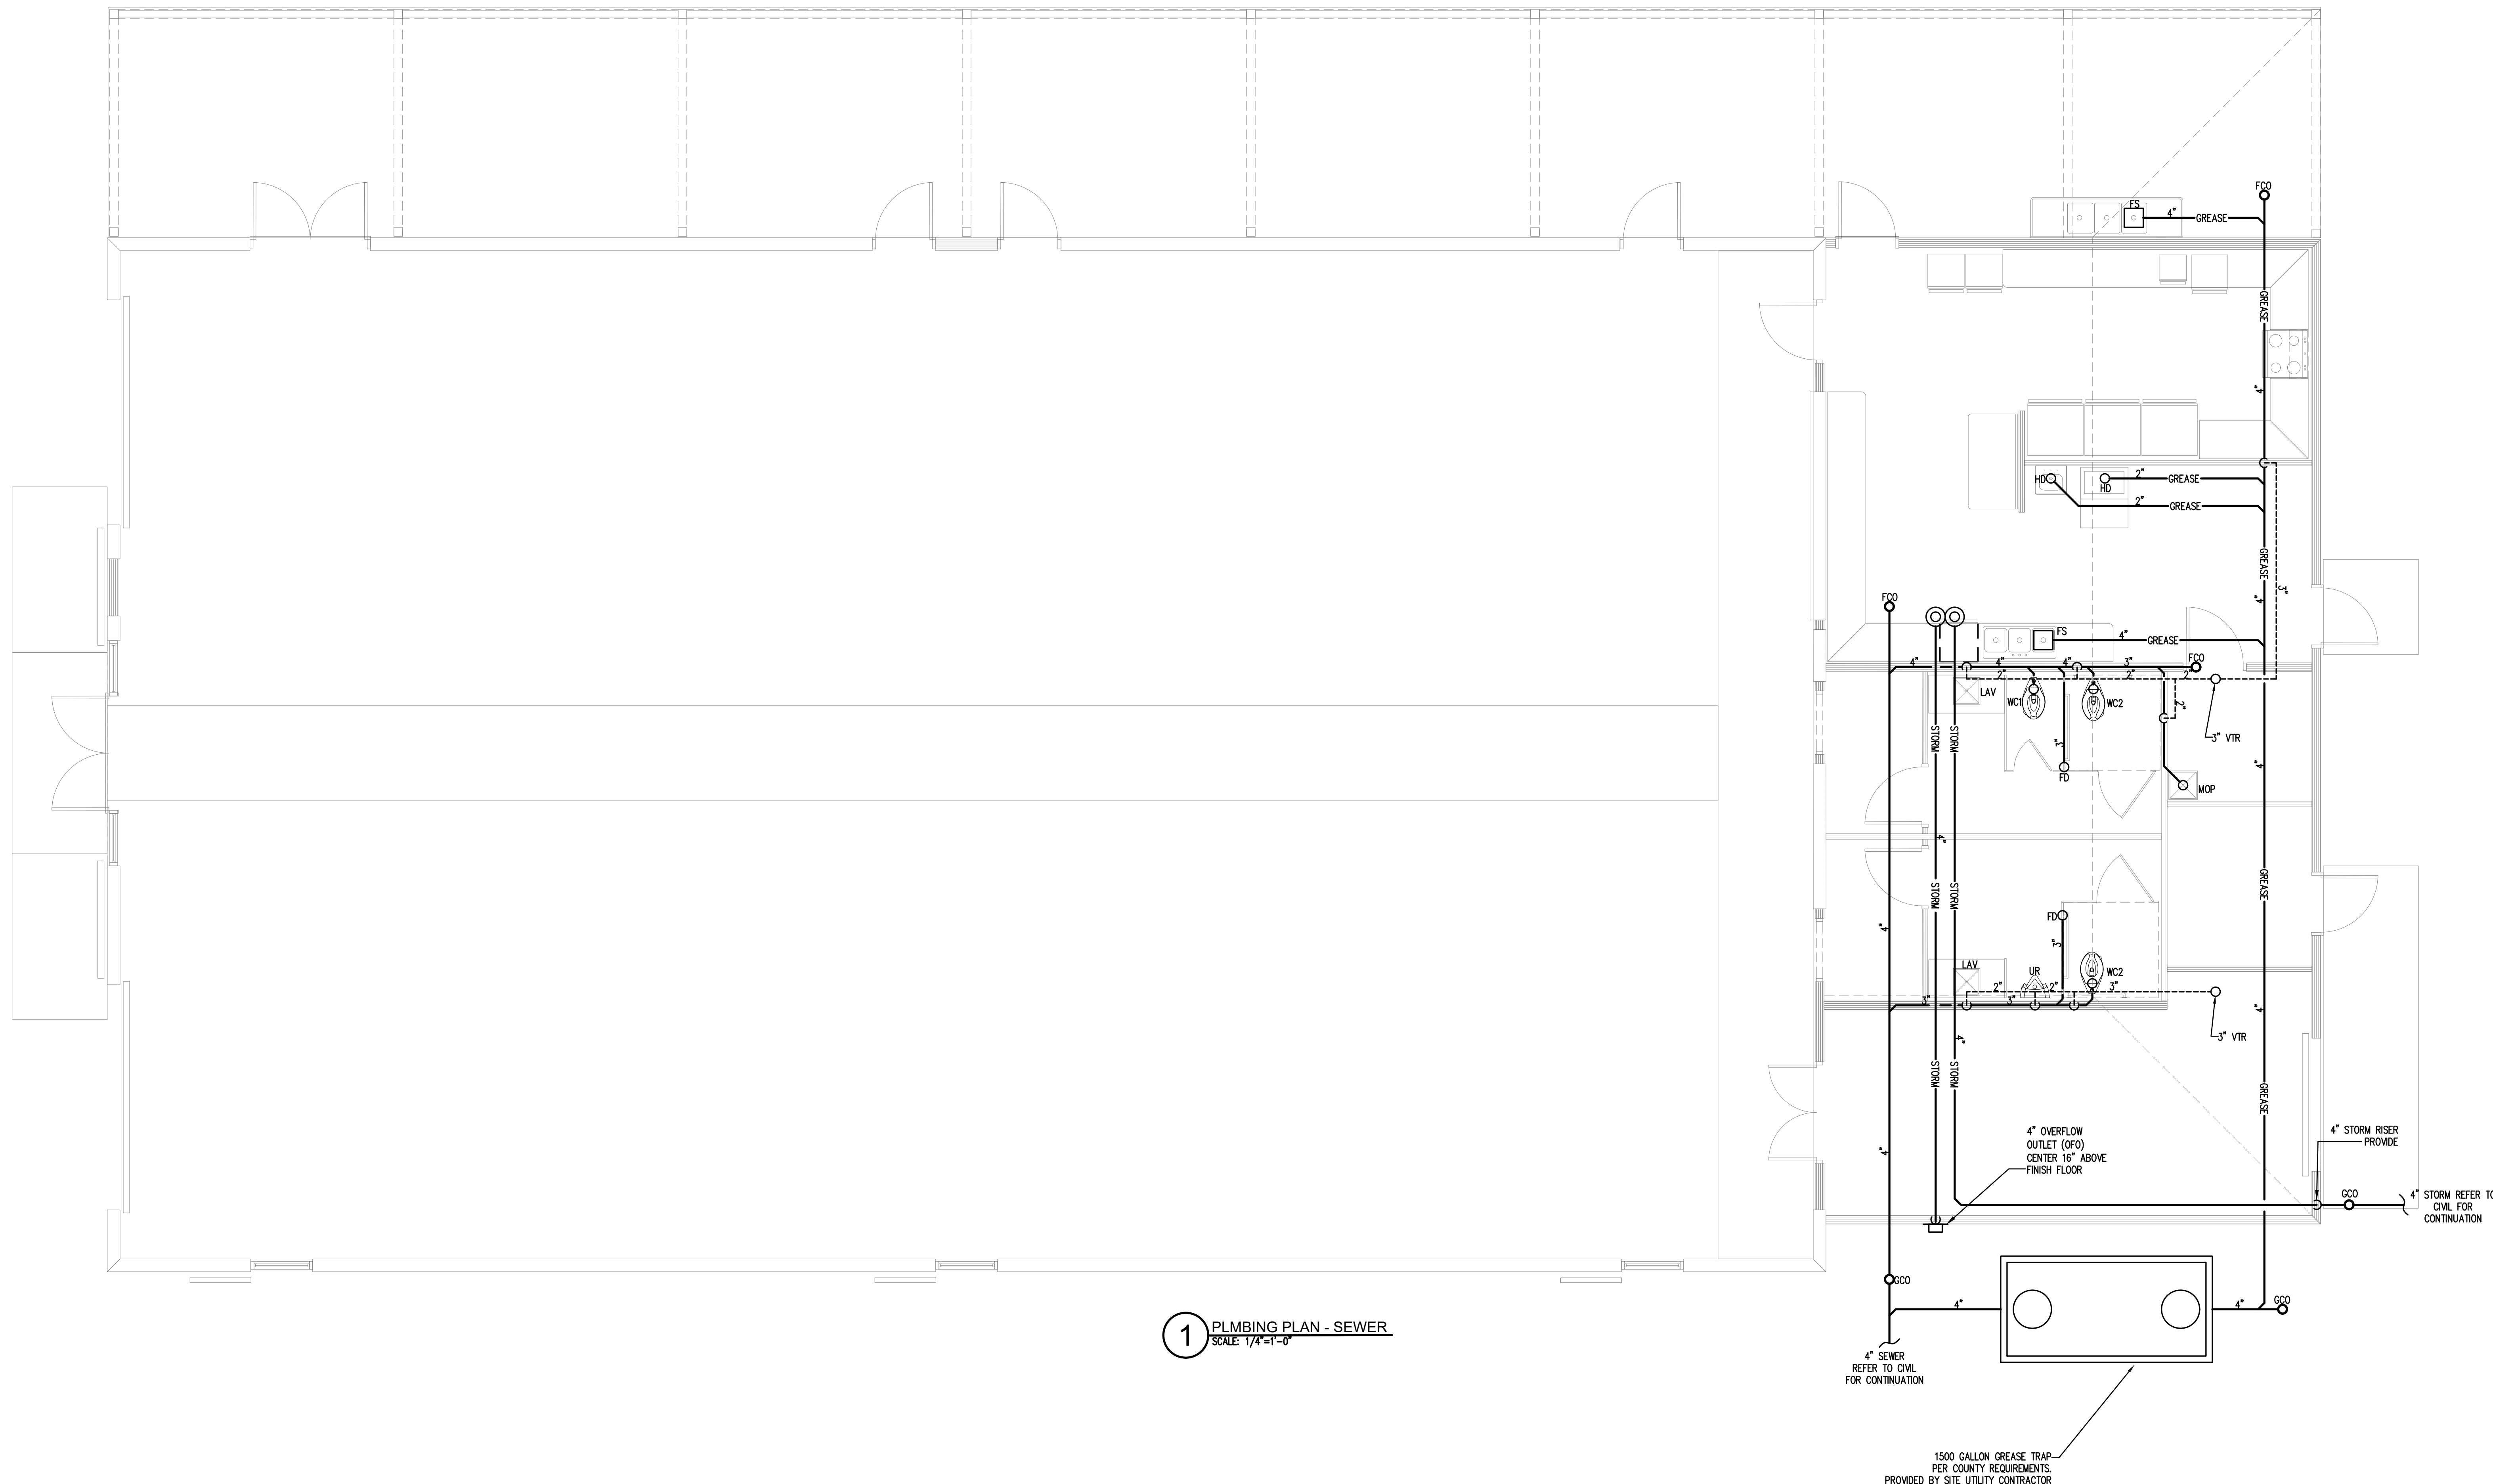

**1** PLUMBING PLAN - SEWER  
SCALE: 1/4"=1'-0"

1500 GALLON GREASE TRAP  
PER COUNTY REQUIREMENTS.  
PROVIDED BY SITE UTILITY CONTRACTOR