



ARCHITECT

STAMP INVALID UNLESS SIGNED

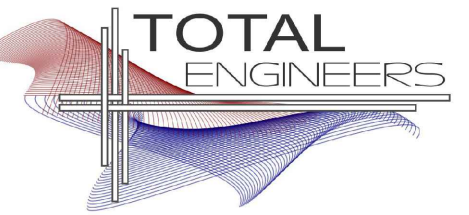

169 New Street, Macon, GA 31201
(478)741-4632 T.E. project # 25-007
www.totalengineers.com
GA COA NO # PEF009195 EXP: 06/30/2026

CONSULTANT

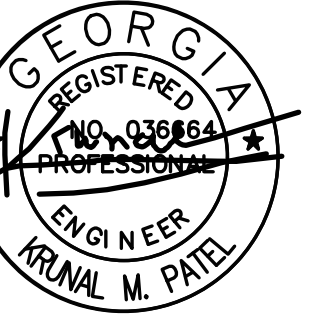

STAMP INVALID UNLESS SIGNED



10641 HIGHWAY 36
COVINGTON, GA 30014
770.786.3031

PLUMBING PLAN - WATER

Retrofit & Renovations for Madison Methodist Church Phase 2: Party Barn

Madison, Georgia 30650
1091 Confederate Highway

JOB NO.: 02601

DRAWN BY: KMP & MGT

CHECKED BY: KMP

DESCRIPTION: SCH-REVIEW-P2

DATE: 12.15.25

DESCRIPTION: DD-REVIEW

DATE: 00.00.26

DESCRIPTION: CD-REVIEW

DATE: 00.00.26

DESCRIPTION: BID-CONSTRUCTION

DATE: 00.00.26

REVISIONS:


1	00.00.26
2	
3	
4	
5	
6	
7	

THESE DRAWINGS ARE THE PROPERTY OF GMARCHITECT AND ARE NOT TO BE REPRODUCED OR HELD WITHOUT PERMISSION AND CREDIT.
COPYRIGHT © 2026

SHEET

P1.1

OF

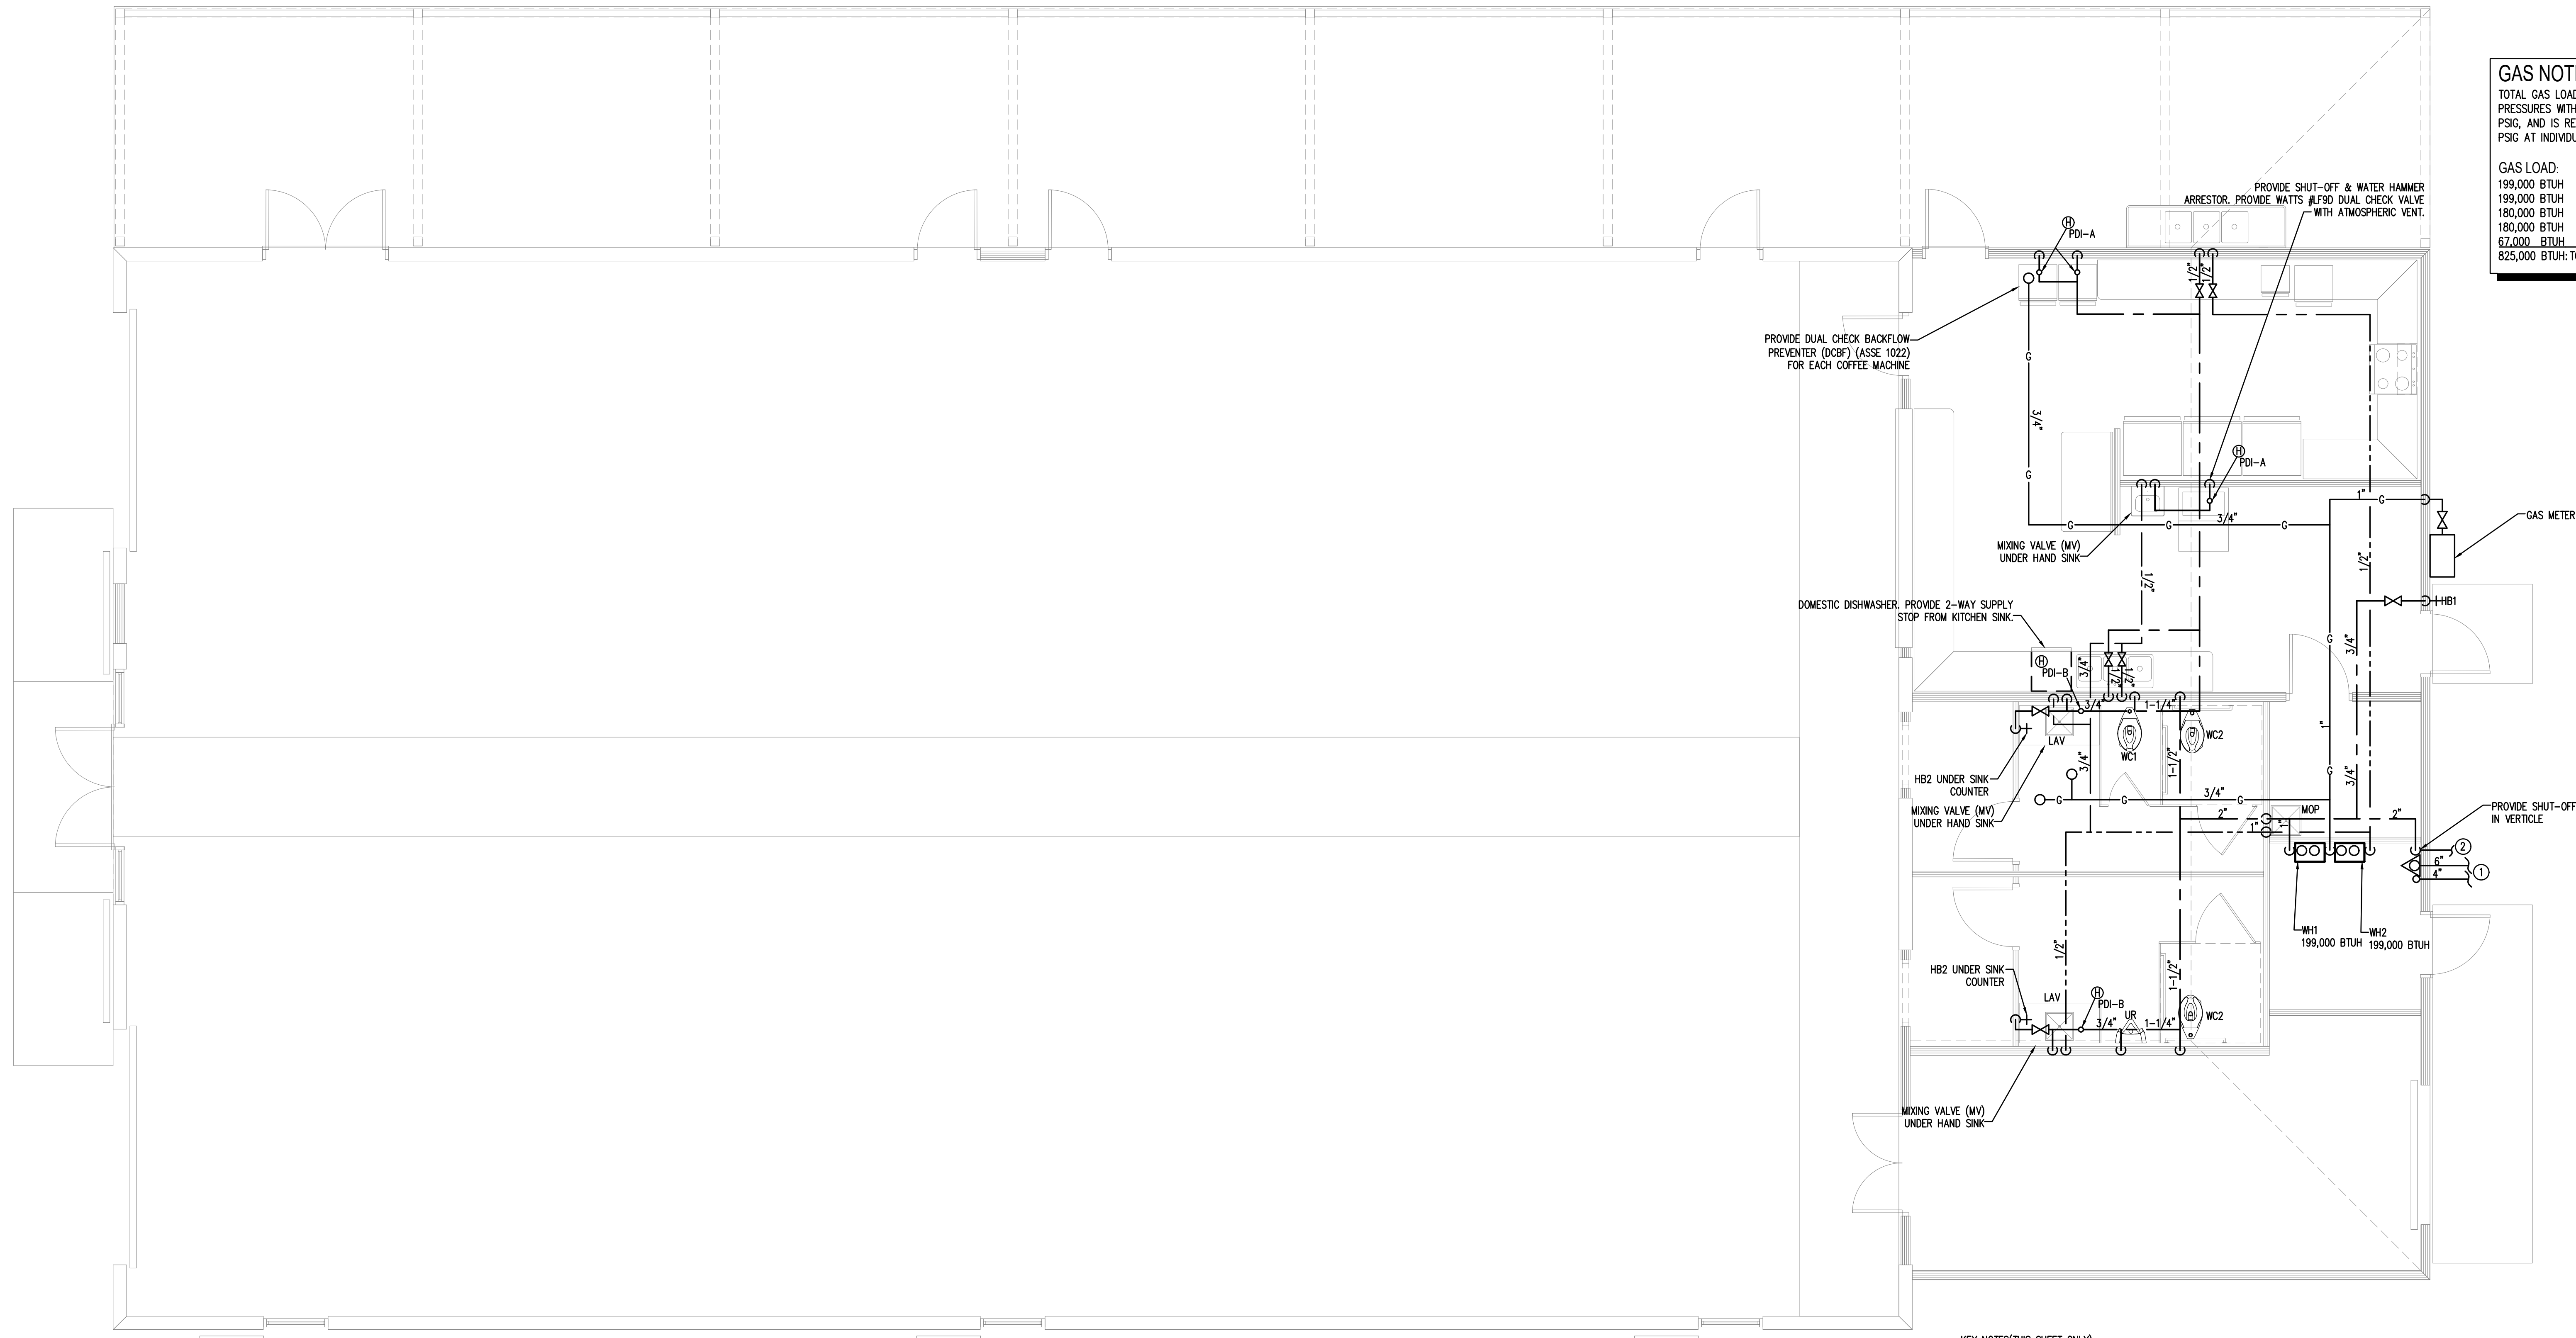

GAS NOTES:
 TOTAL GAS LOAD IS 825,000 BTUH. NATURAL GAS SYSTEM PRESSURES WITHIN BUILDING: PRIMARY PRESSURE IS 2.0 PSIG, AND IS REDUCED TO SECONDARY PRESSURE OF 0.5 PSIG AT INDIVIDUAL POINTS OF USE.

GAS LOAD:

199,000 BTUH	WH1 WATER HEATER
199,000 BTUH	WH2 WATER HEATER
180,000 BTUH	RTU-1
180,000 BTUH	RTU-2
67,000 BTUH	RTU-3
825,000 BTUH	TOTAL GAS LOAD

KEY NOTES (THIS SHEET ONLY):
 ① 6" FIRE SPRINKLER FROM CITY SUPPLY & 4" FIRE TO REMOTE F.D.C. REFER TO CIVIL FOR CONTINUATION.
 ② 2" WATER REFER TO CIVIL FOR CONTINUATION.

1 PLUMBING PLAN - WATER
 SCALE: 1/4"=1'-0"