




1 CONDENSATE DRAIN FOR ROOF TOP
SCALE: N.T.S.

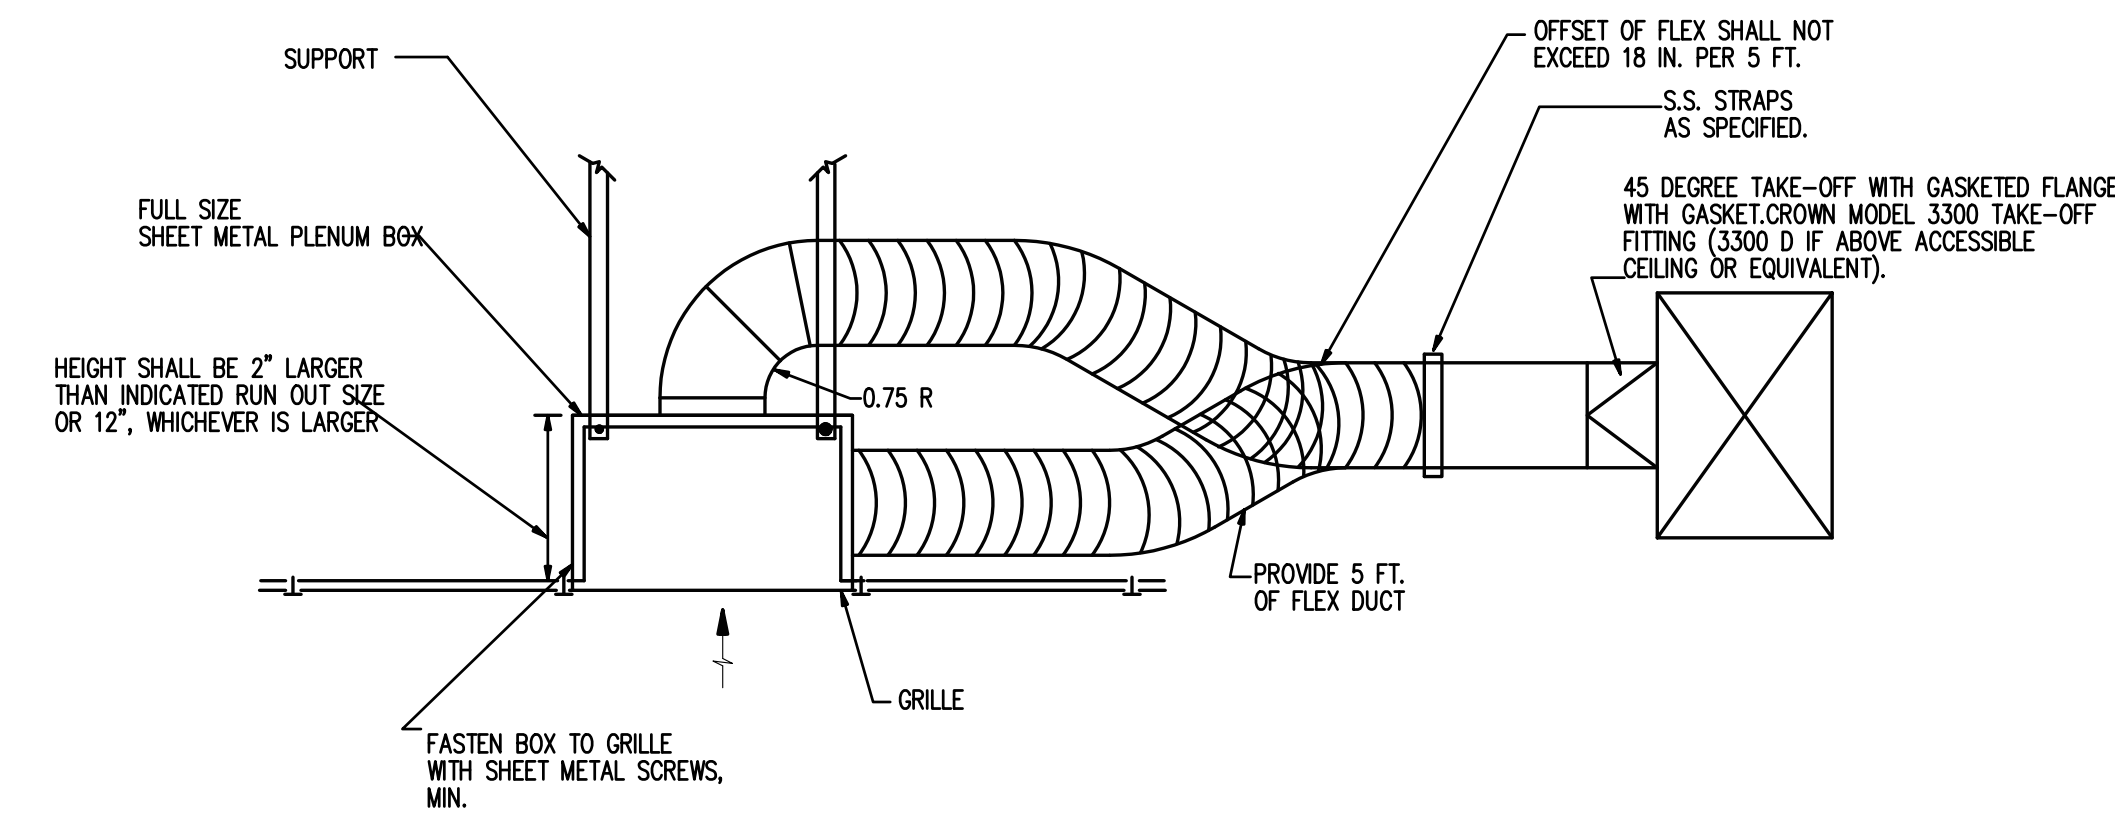


2 TYPICAL GRILLE WITH LINED PLENUM DETAIL
SCALE: N.T.S.

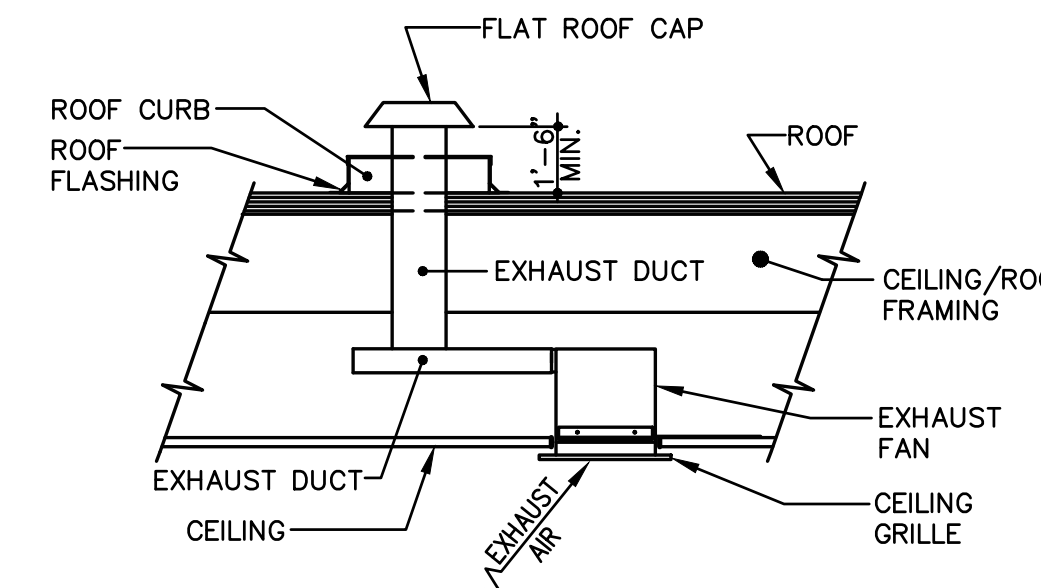


3 CEILING EXHAUST FAN DETAIL
SCALE: N.T.S.

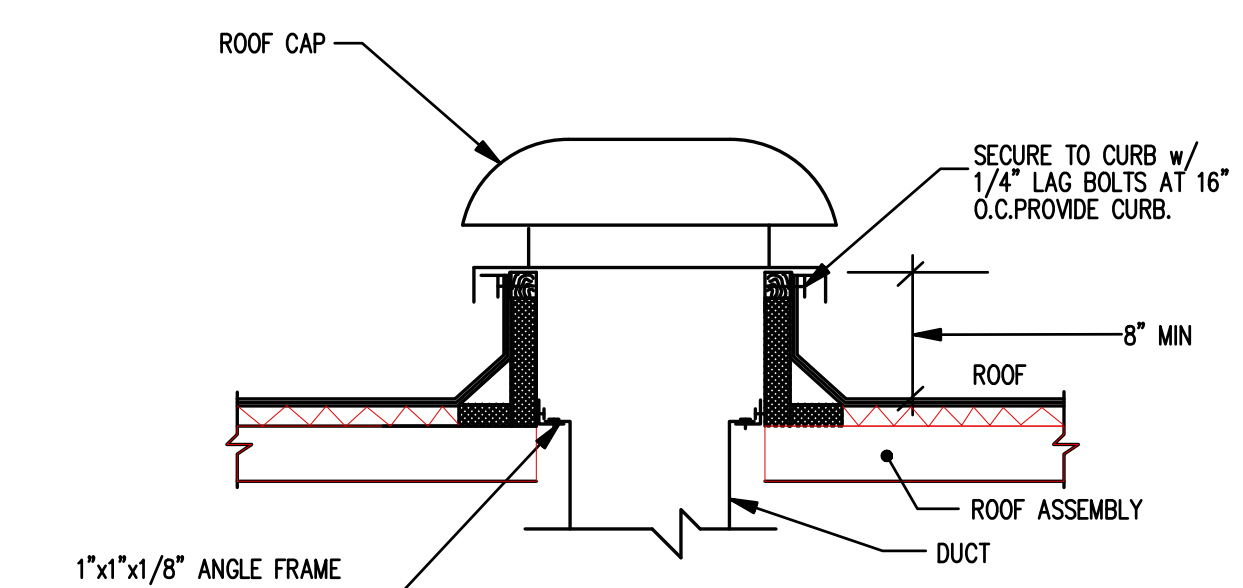


4 ROOF CAP DETAIL
SCALE: N.T.S.

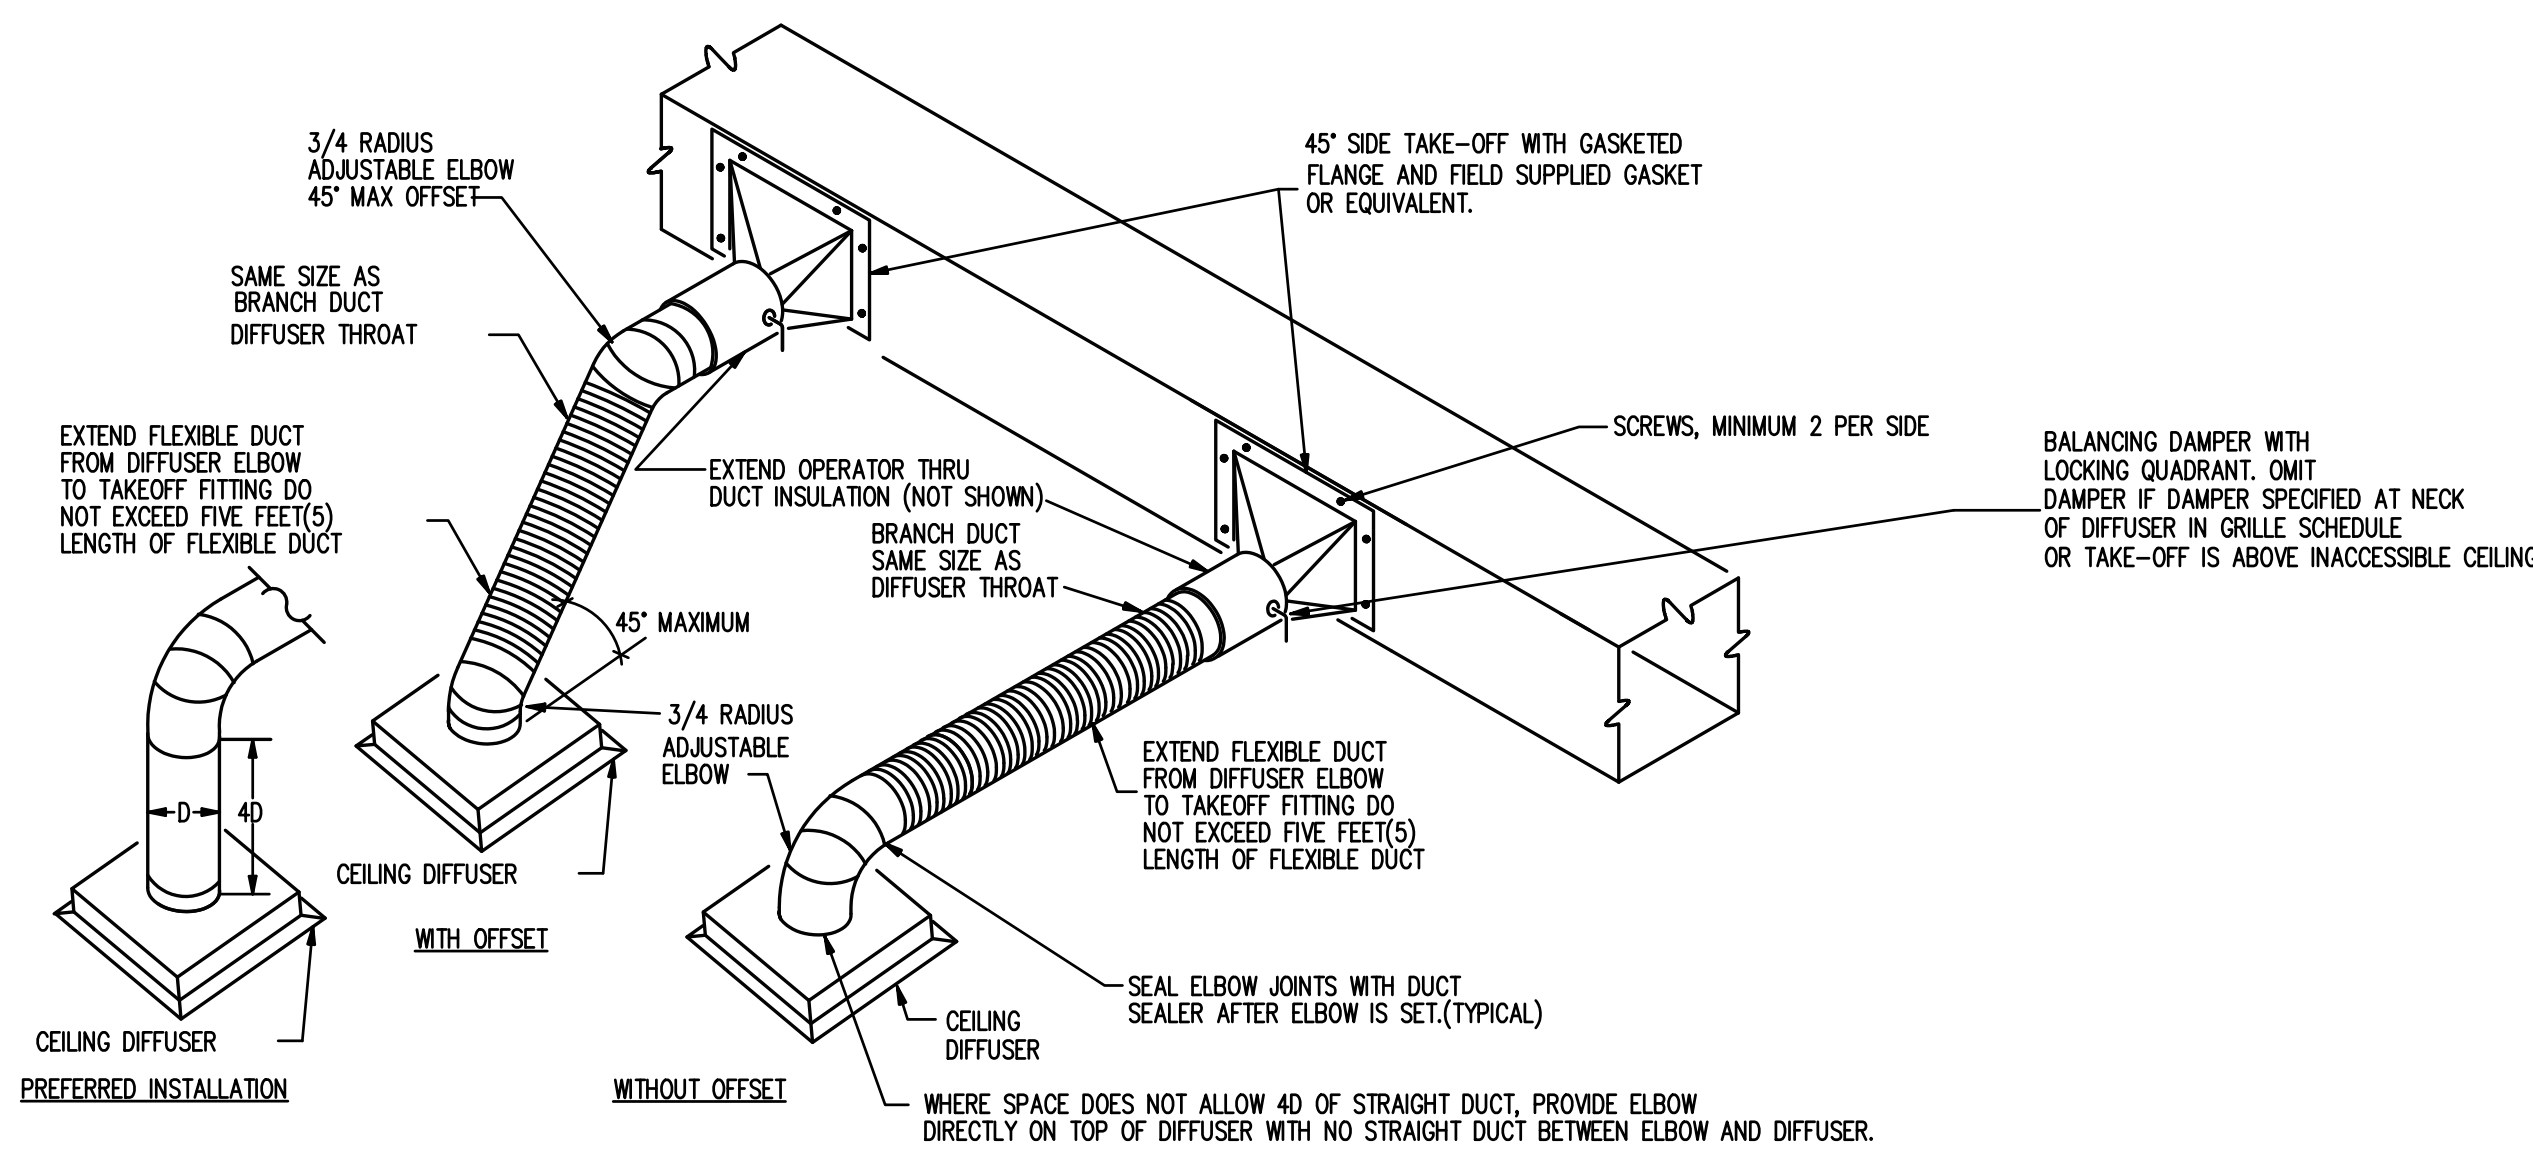


5 DIFFUSER RUN OUT DETAIL
SCALE: N.T.S.

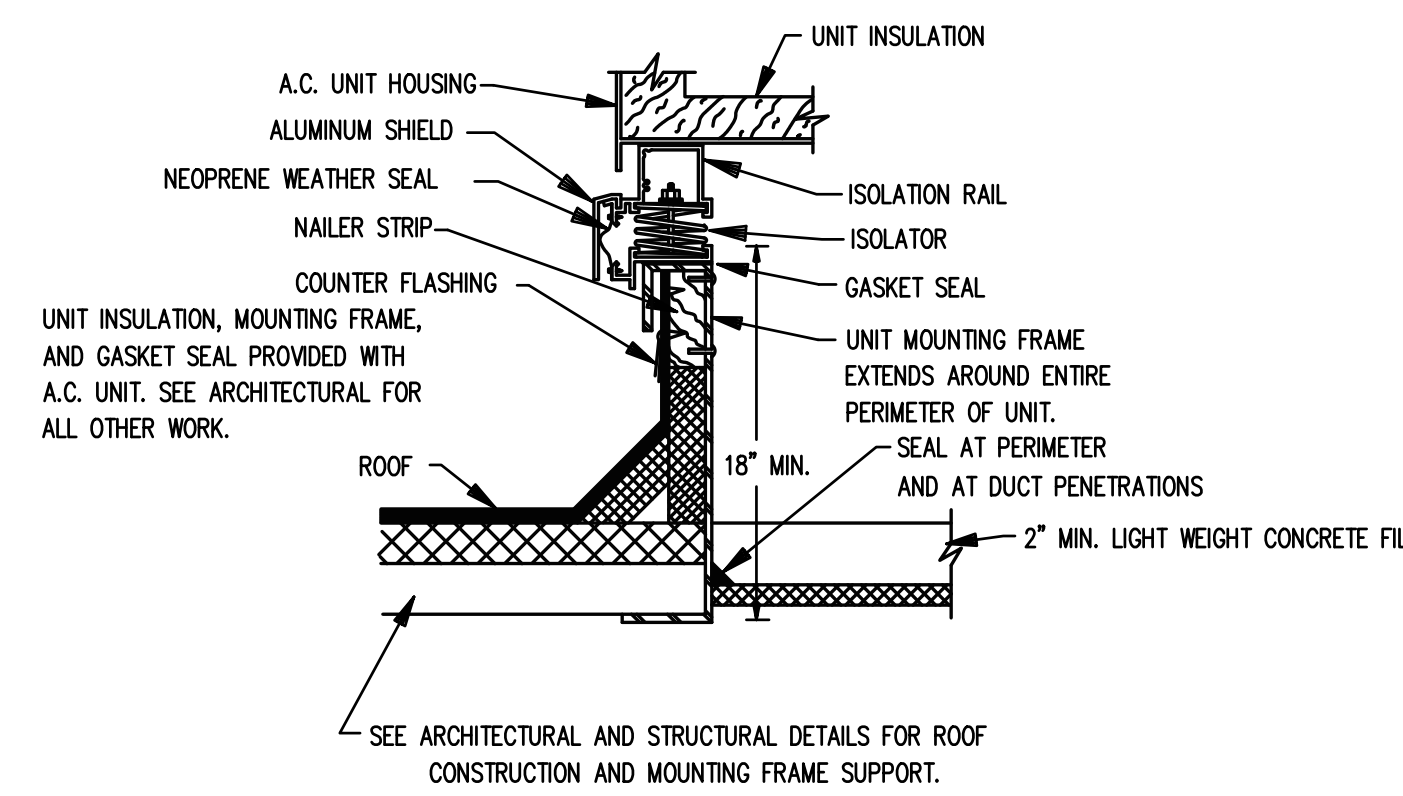


6 ROOFTOP UNIT CURB WITH VIBRATION ISOLATION - DETAIL
SCALE: N.T.S.

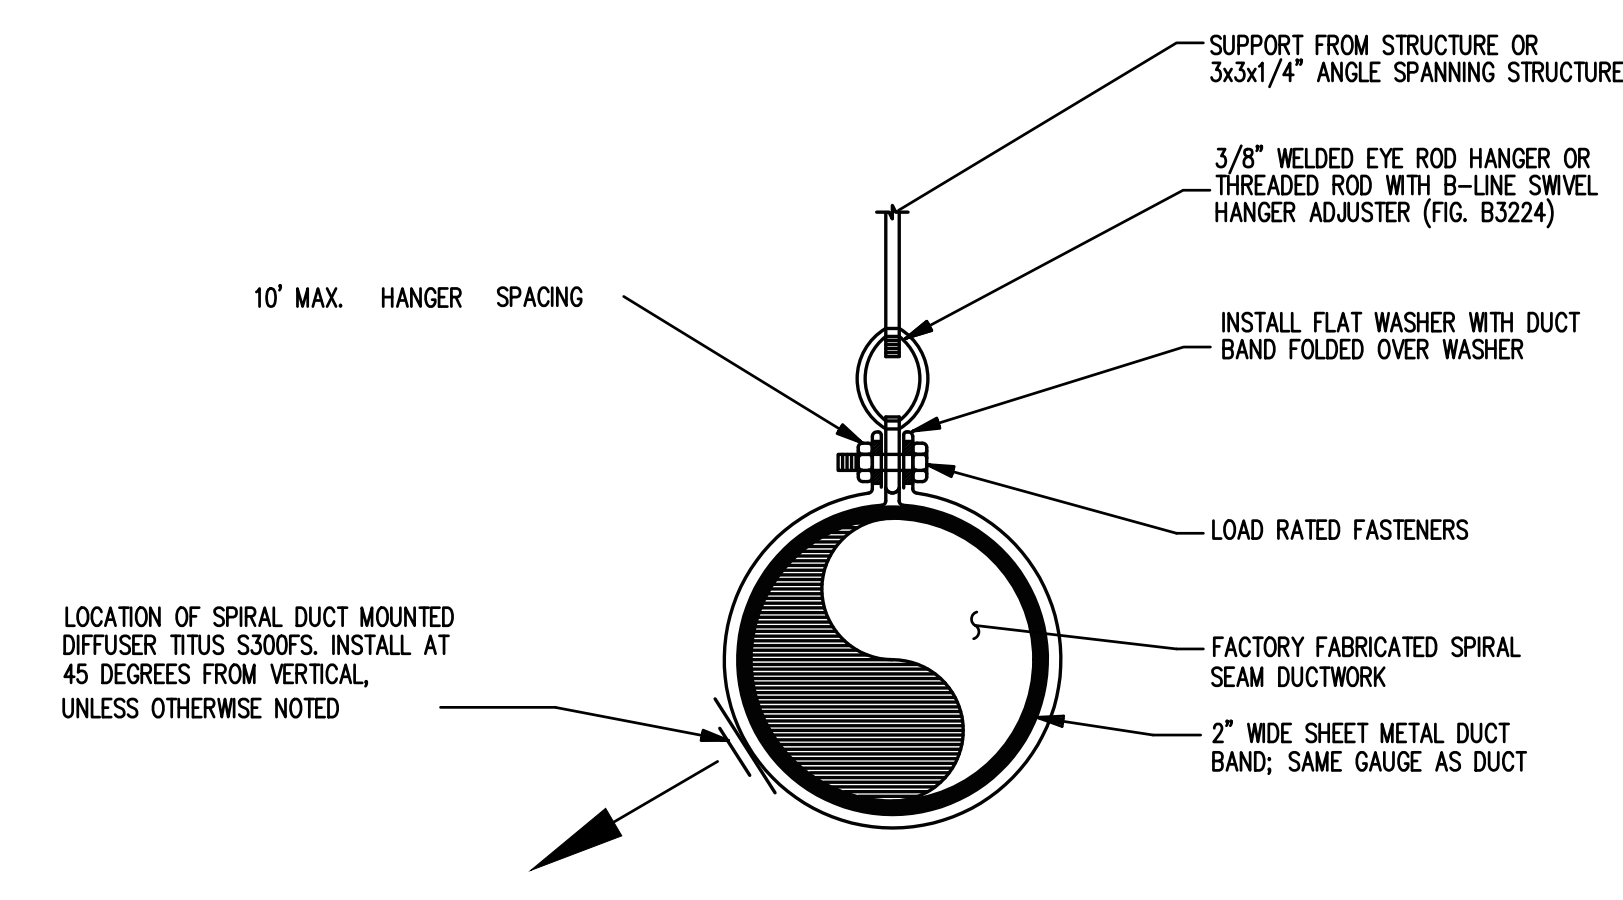

7 DUCT SUPPORT IN EXPOSED AREA
SCALE: N.T.S.

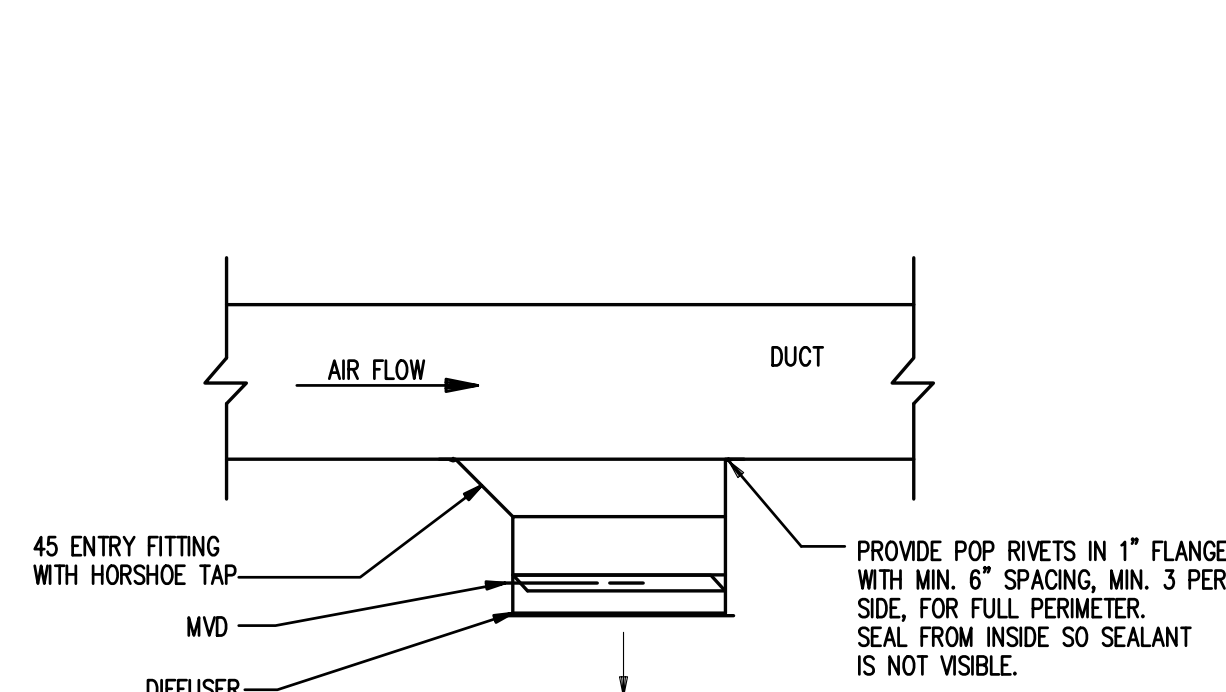

8 DUCT MOUNTED DIFFUSER DETAIL
SCALE: N.T.S.

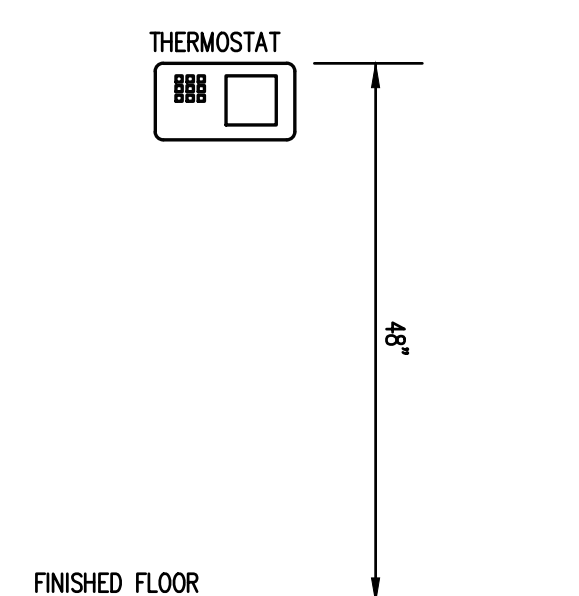

9 T-STAT DETAIL
SCALE: N.T.S.

MECHANICAL DETAILS

JOB NO.:	02601
DRAWN BY:	KMP & MGT
CHECKED BY:	KMP
DATE:	12.15.25
DESCRIPTION:	SCH-REVIEW-P2
DATE:	00.00.26
DESCRIPTION:	DD-REVIEW
DATE:	00.00.26
DESCRIPTION:	CD-REVIEW
DATE:	00.00.26
DESCRIPTION:	BID-CONSTRUCTION
DATE:	00.00.26
REVISIONS:	
1	00.00.26
2	
3	
4	
5	
6	
7	