

169 New Street, Macon, GA  
31201 (478)741-4632 - T.E.  
project # 25-115  
www.totalengineers.com  
GA COA NO # PEF009195  
EXP: 06/30/2026



10641 HIGHWAY 36  
COVINGTON, GA 30014  
770.786.3031

MECHANICAL FLOOR PLAN  
**Retrofit & Renovations for  
Madison Methodist Church  
Phase 2: Party Barn**  
1091 Confederate Highway Madison, Georgia 30650

JOB NO.: 02601  
DRAWN BY: KMP & MGT  
CHECKED BY: KMP

DESCRIPTION: SCH-REVIEW-P2

DATE: 12.15.26

DESCRIPTION: DD-REVIEW

DATE: 00.00.26

DESCRIPTION: CD-REVIEW

DATE: 00.00.26

DESCRIPTION: BID-CONSTRUCTION

DATE: 03.10.26

NO.	DESCRIPTION	DATE
1	00.00.26	
2		
3		
4		
5		
6		
7		



THESE DRAWINGS ARE THE PROPERTY OF GMARCHIT AND ARE NOT TO BE REPRODUCED OR HELD WITHOUT PERMISSION AND CREDIT.  
COPYRIGHT (C) 2026

SHEET

**M1.1**

OF

 NEW WORK NOTES - M1.1	
#	NOTE TEXT
1	DUCT UP TO RTU-3 ON ROOF. TRANSITION TO RTU OPENING SIZE AT UNDER SIDE OF ROOF. RTU3 DUCTS DO NOT NEED LINER.
2	TOP OF THERMOSTAT SHALL BE AT 48" AFF. PROVIDE BREATHABLE CLEAR PLASTIC, TAMPER PROOF AND LOCKABLE THERMOSTAT COVER.
3	TYPICAL MANUAL VOLUME DAMPER.
4	6" Ø EXHAUST DUCT UP TO ROOF CAP.
5	7" Ø EXHAUST DUCT UP TO ROOF CAP.
6	8" Ø EXHAUST DUCT UP TO ROOF CAP.
7	ALL VISIBLE EXPOSED DUCTWORK IN THE ENTIRE BUILDING SHALL BE ROUND SPIRAL DUCT. PROVIDE PAINT GRIP FINISH. PAINT DUCT PER ARCHITECTURAL'S INSTRUCTIONS.
8	PROVIDE DOUBLE WALL SPIRAL ELBOW.
9	REFER TO SHEET M1.2 FOR CONTINUATION.

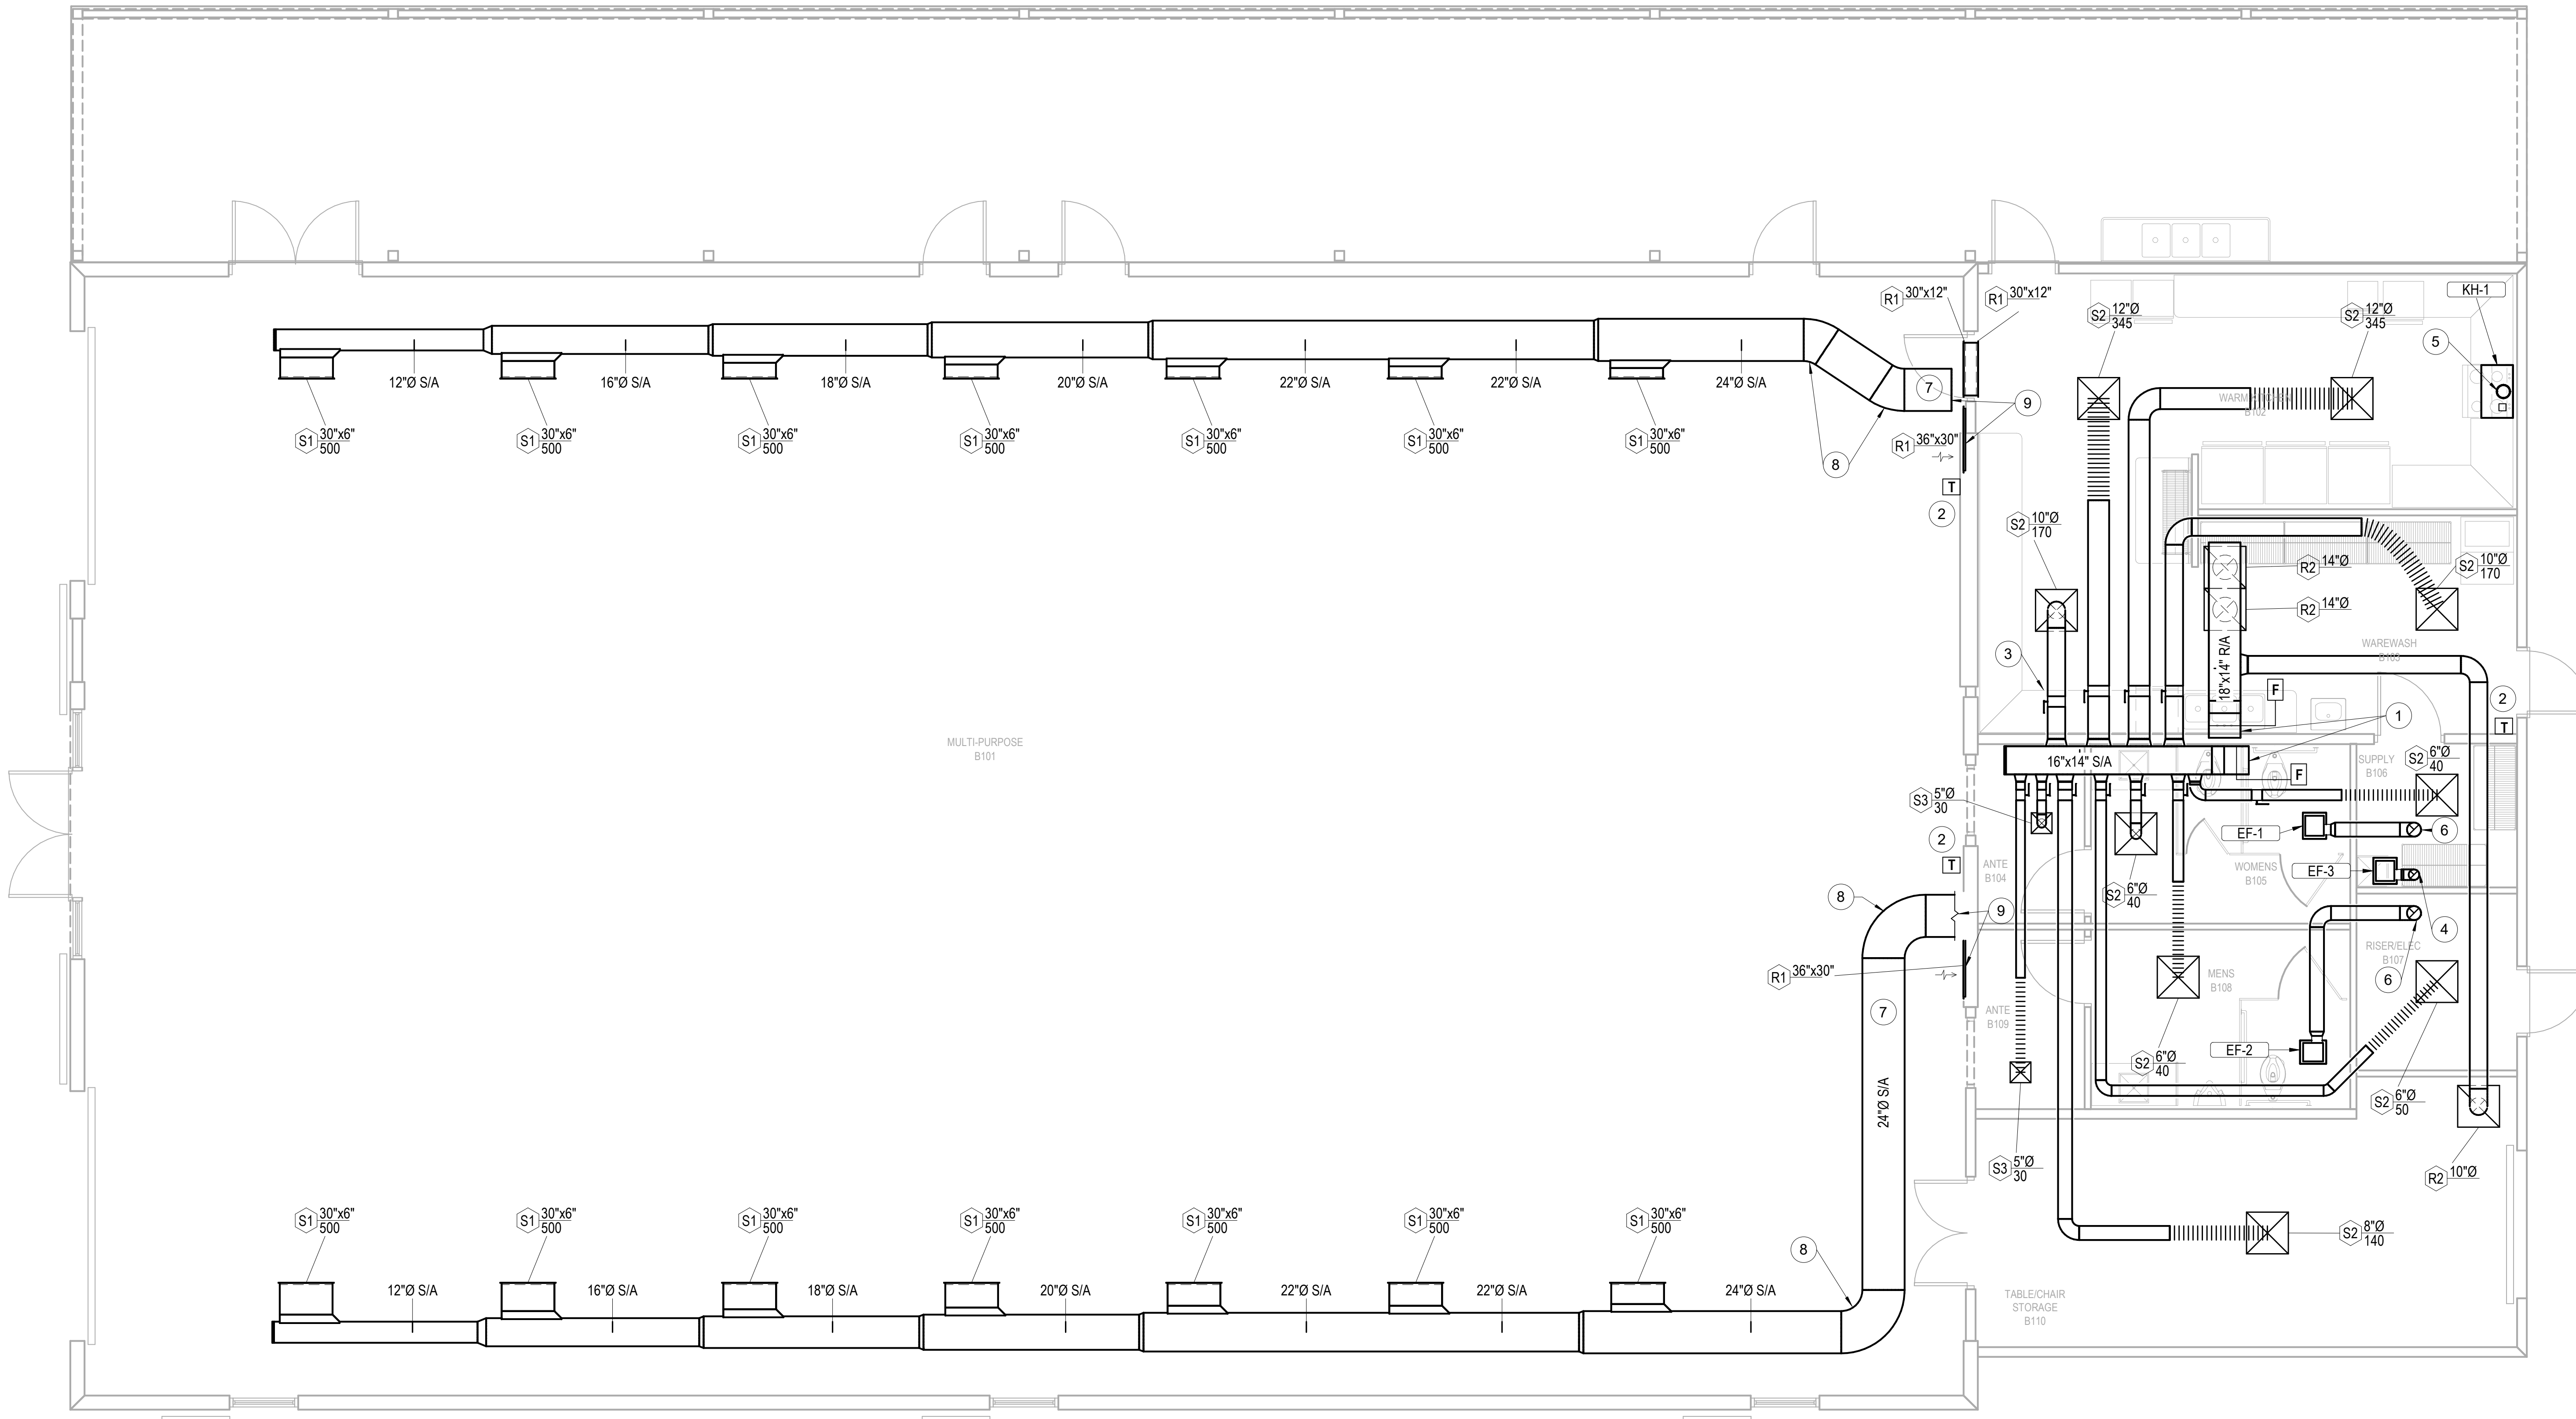

1 MECHANICAL FLOOR PLAN  
M1.1  
1/4" = 1'-0"