

NEW WORK NOTES - M1.2	
#	NOTE TEXT
1	OUTDOOR AIR INTAKE OPENINGS OF RTU SHALL BE LOCATED A MINIMUM OF 10 FEET HORIZONTALLY FROM PLUMBING VTR AND EXHAUST ROOF CAPS. TYPICAL FOR ALL RTUs.
2	PROVIDE REQUIRED RTU SERVICE CLEARANCES PER MANUFACTURER'S INSTRUCTIONS. TYPICAL FOR ALL RTUs.
3	6' Ø EXHAUST AIR ROOF CAP. PAINT CAP TO MATCH ROOF.
4	8' Ø EXHAUST AIR ROOF CAP. PAINT CAP TO MATCH ROOF.
5	7' Ø EXHAUST AIR ROOF CAP. PAINT CAP TO MATCH ROOF.
6	REFER TO SHEET M1.1 FOR CONTINUATION.

GM
Architect
102 Sammy Court
WARNER ROBINS, GEORGIA 31088
gmarcb@outlook.com
(478)-365-8976

ARCHITECT

CONSULTANT

TOTAL ENGINEERS
169 New Street, Macon, GA
31201 (478)741-4632 - T.E.
project # 25-115
www.totalengineers.com
GA COA NO # PEF009195
EXP: 06/30/2026


SUNBELT BUILDERS
10641 HIGHWAY 36
COVINGTON, GA 30014
770.786.3031

MECHANICAL ROOF PLAN
**Retrofit & Renovations for
Madison Methodist Church
Phase 2: Party Barn**
1091 Confederate Highway Madison, Georgia 30650


JOB NO.:	02601
DRAWN BY:	KMP & MGT
CHECKED BY:	KMP
DESCRIPTION:	SCM-REVIEW-P2
DATE:	12.15.26
DESCRIPTION:	DD-REVIEW
DATE:	00.00.26
DESCRIPTION:	CD-REVIEW
DATE:	00.00.26
DESCRIPTION:	BID-CONSTRUCTION
DATE:	03.10.26
REVISIONS:	
1	00.00.26
2	
3	
4	
5	
6	
7	

THESE DRAWINGS ARE THE PROPERTY OF GMARCHIT AND ARE NOT TO BE REPRODUCED OR HELD WITHOUT PERMISSION AND CREDIT.
COPYRIGHT (C) 2026

SHEET
M1.2
OF

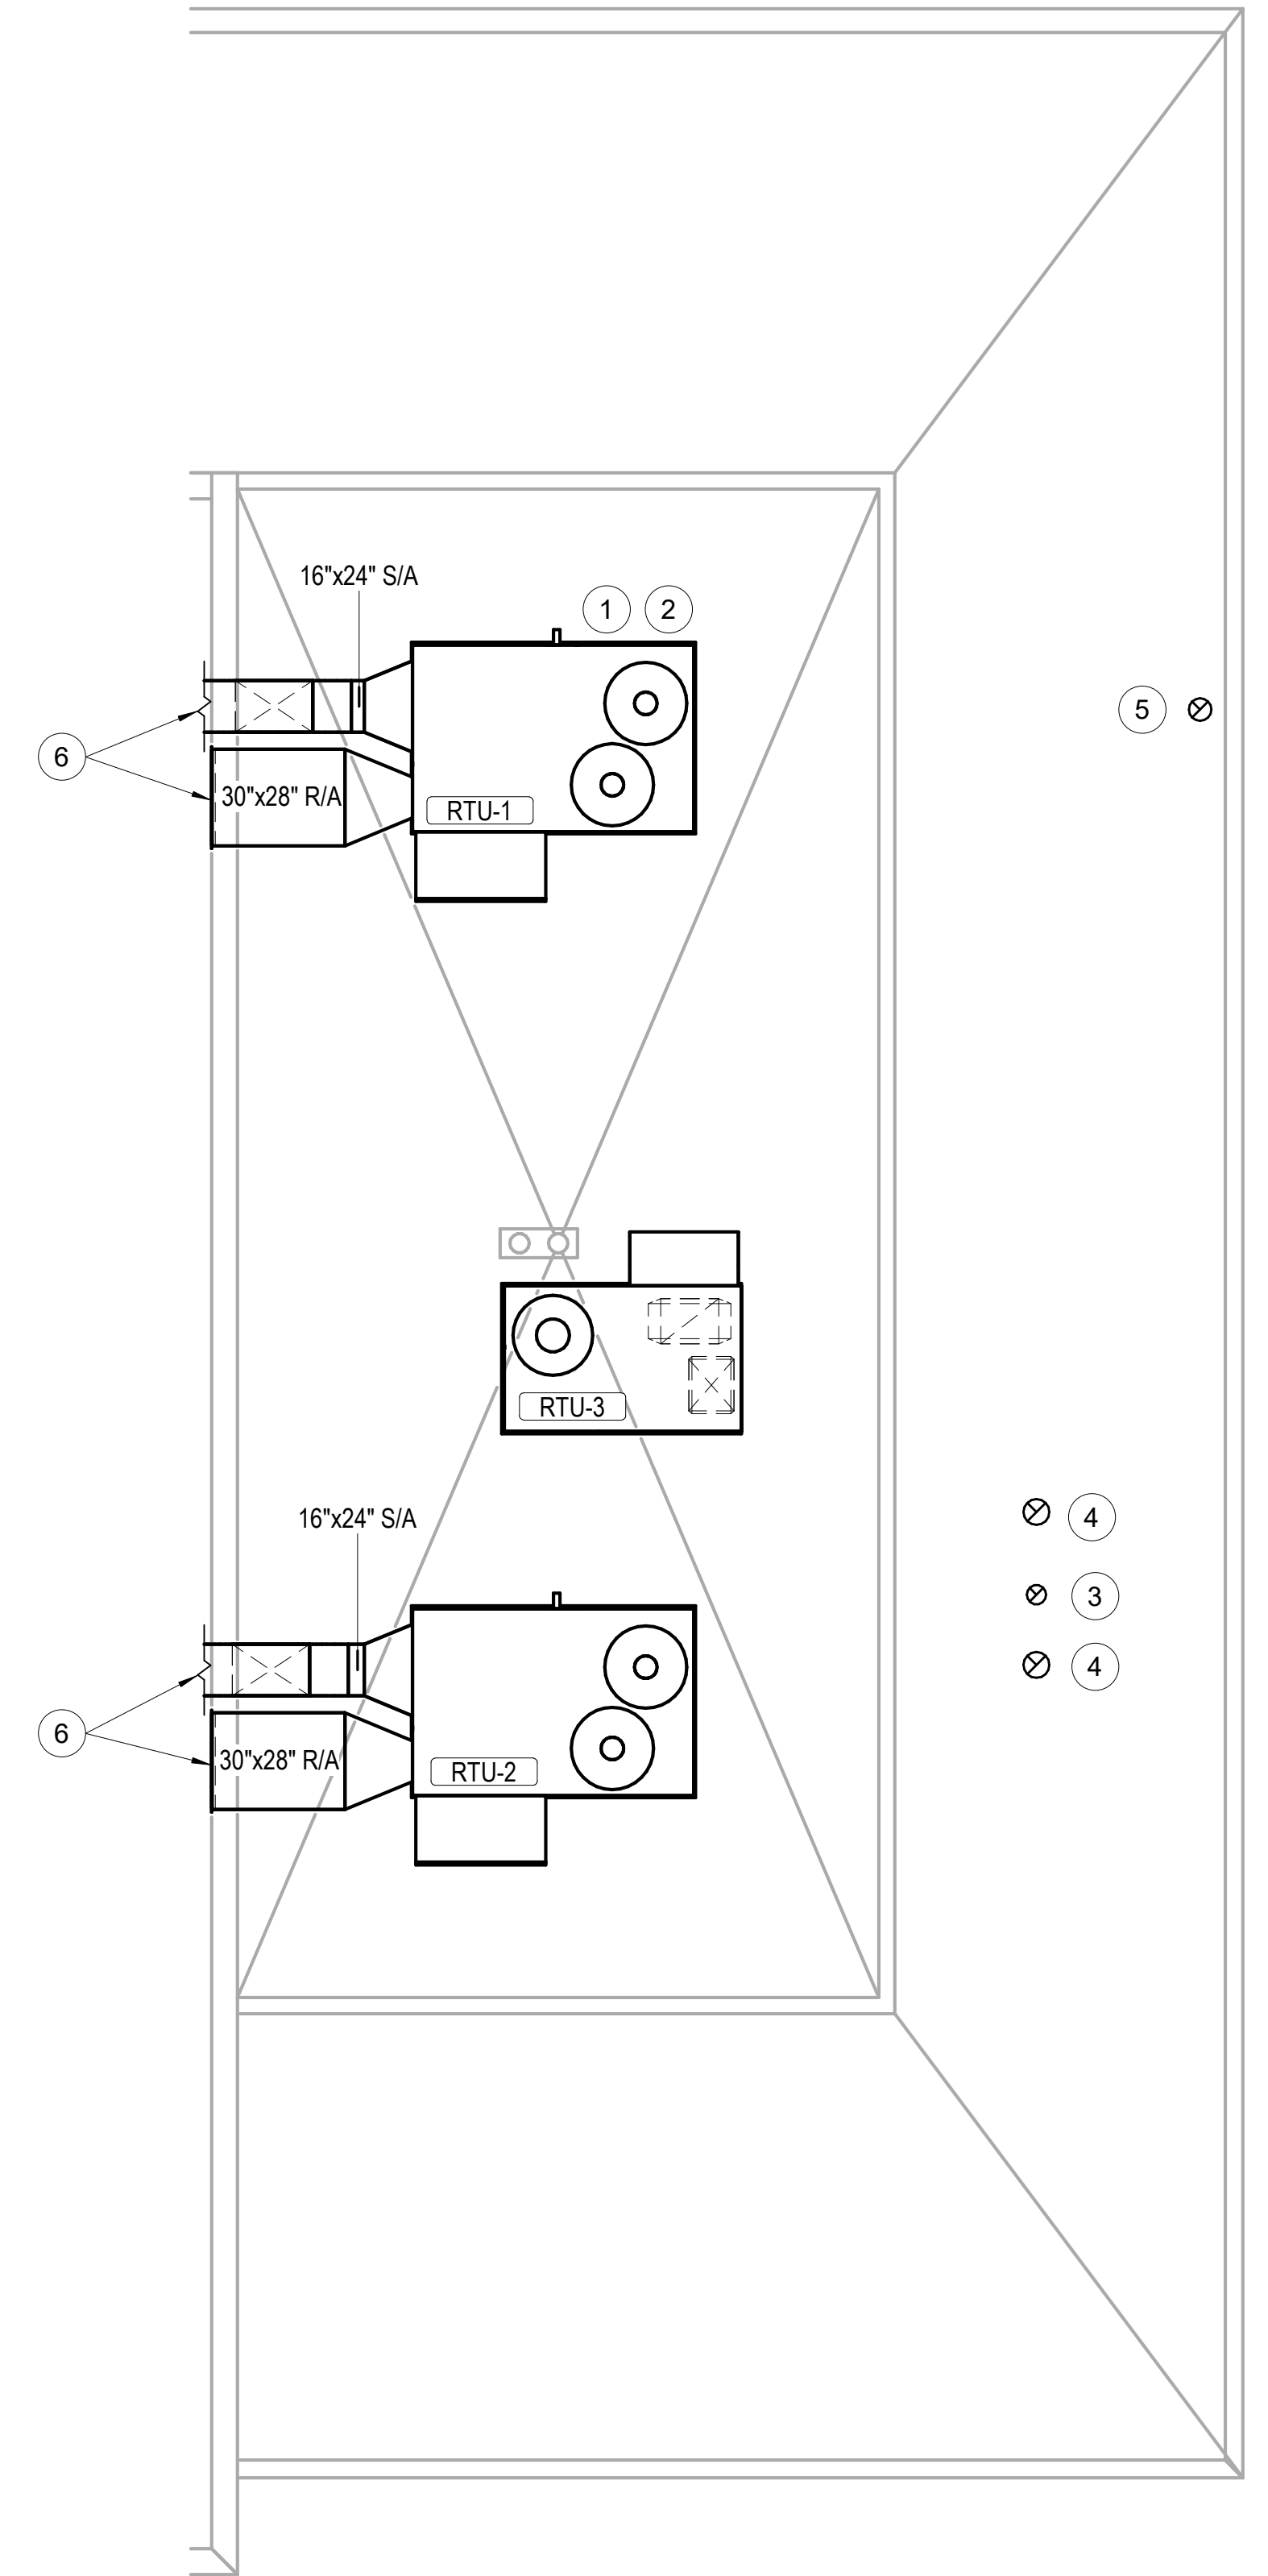

1 LEVEL 3 HVAC PLAN
M1.2 1/4" = 1'-0"
0 2 4 8

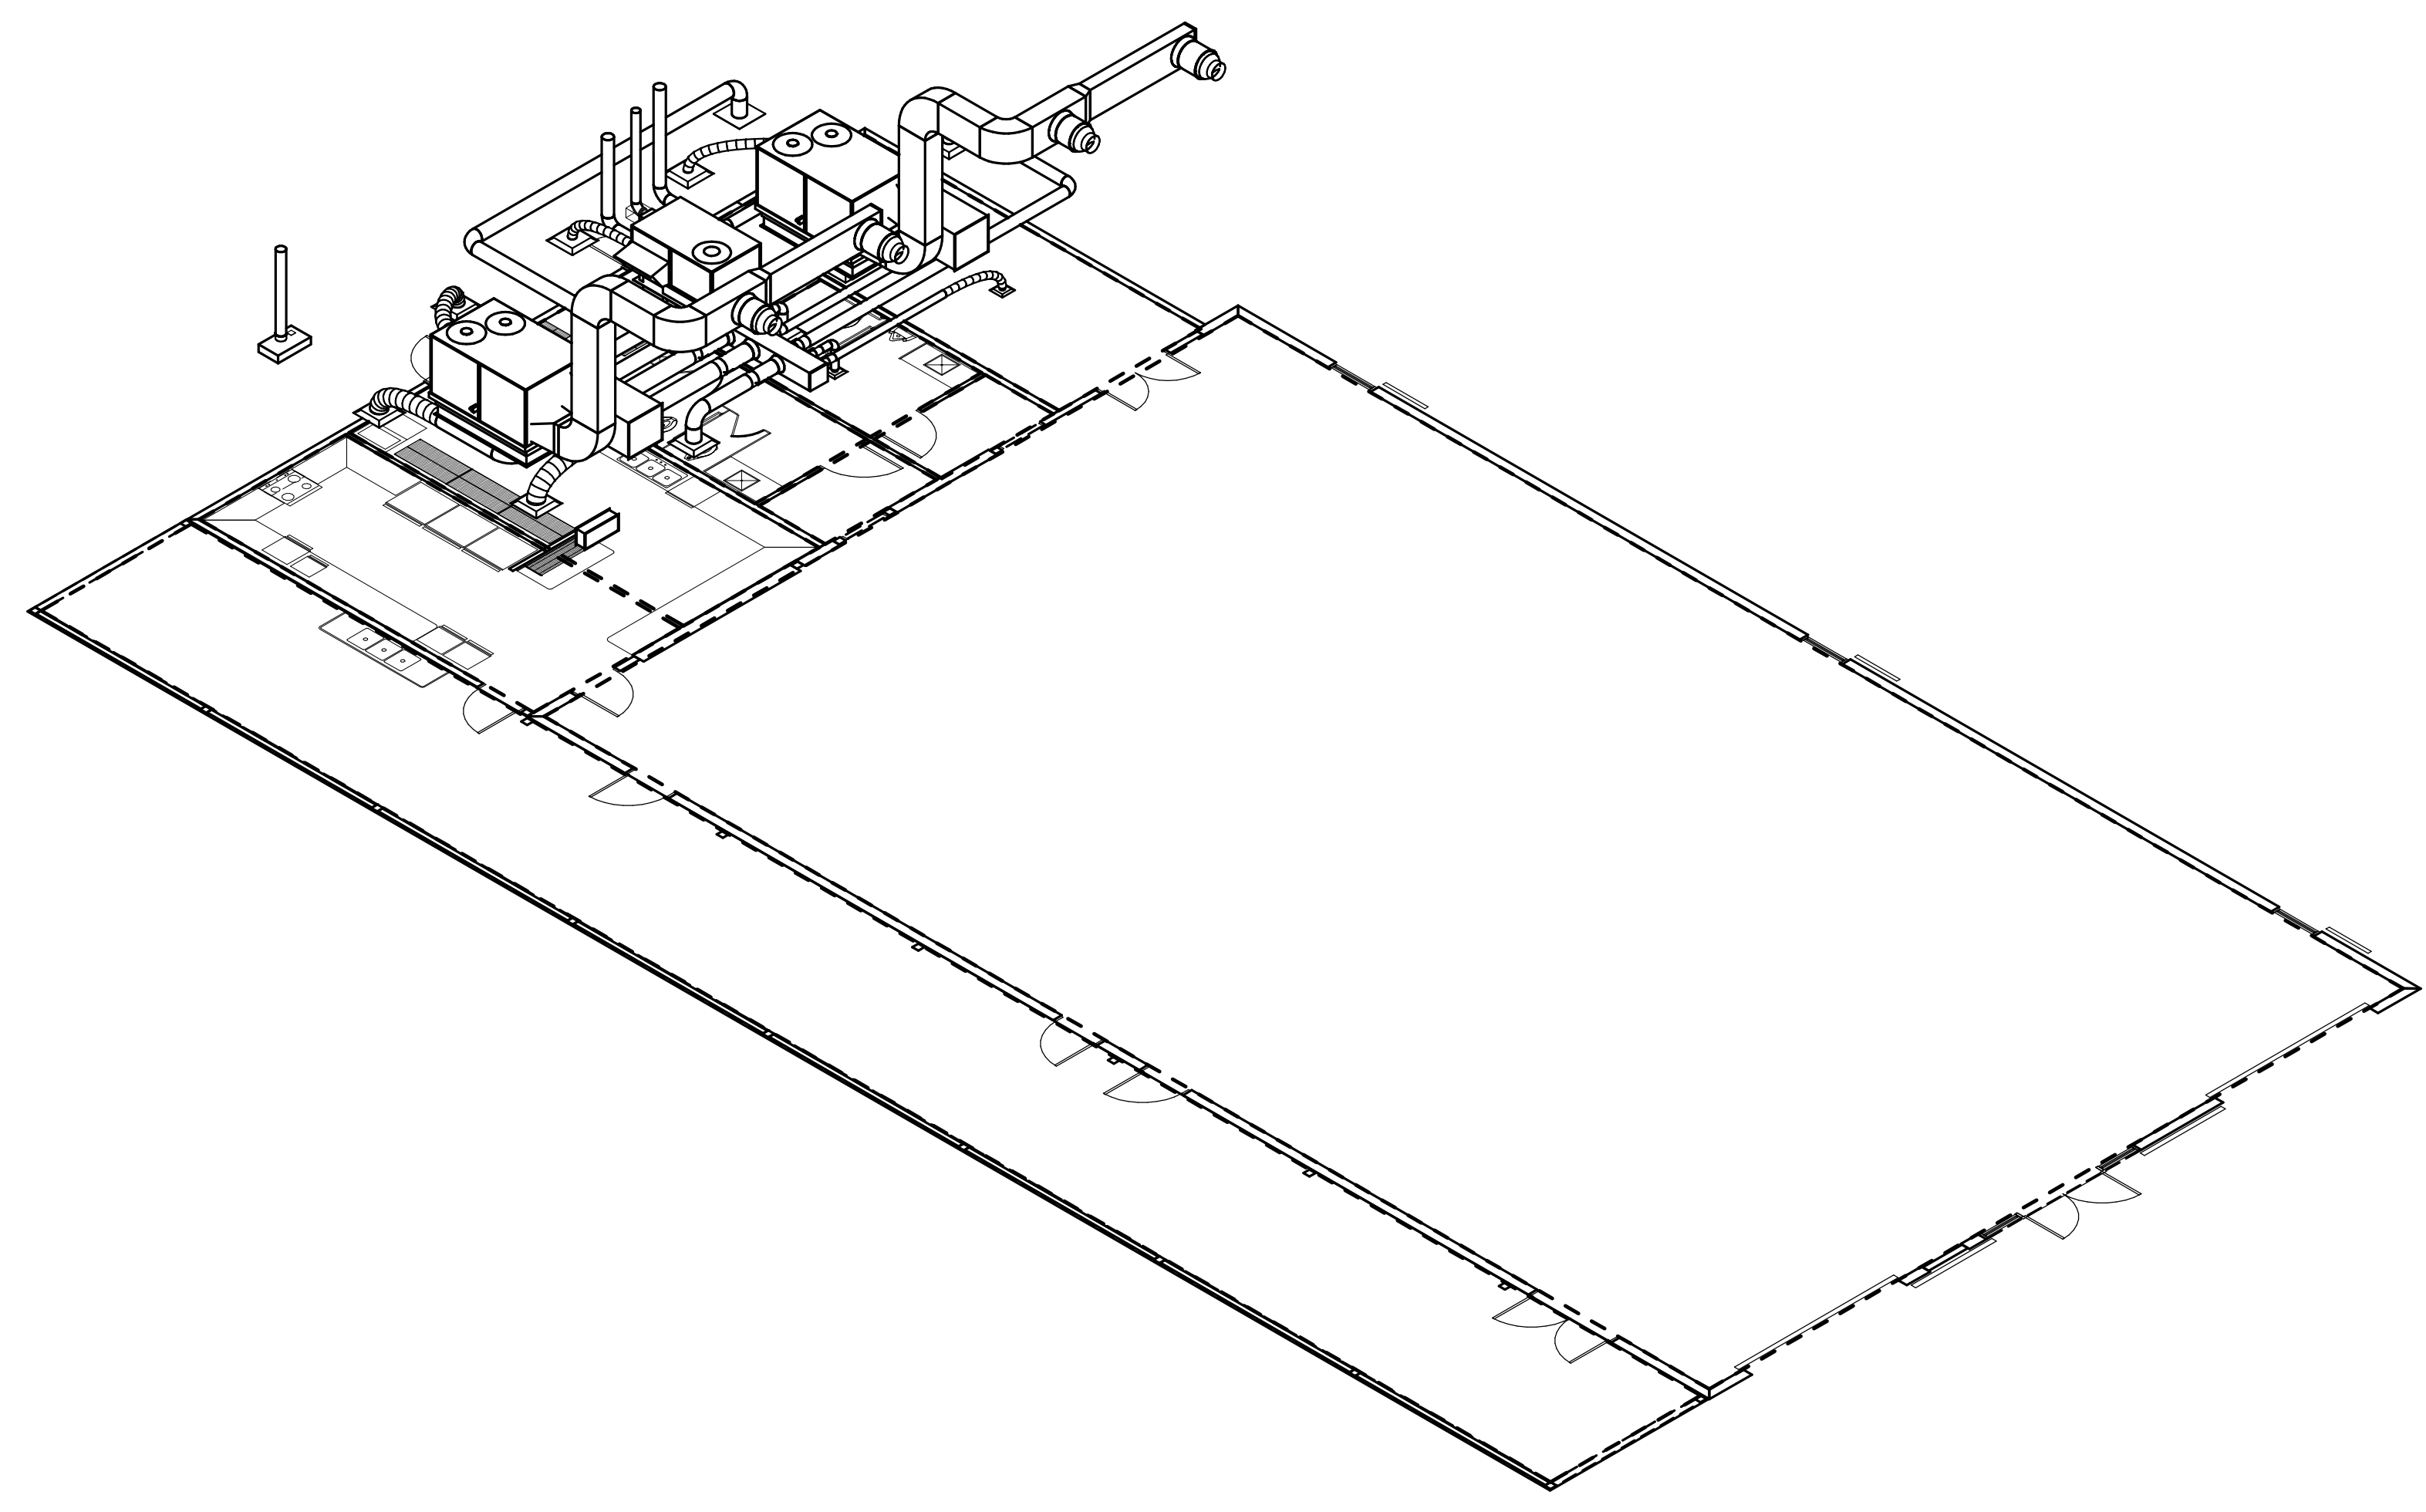

2 Isometric
M1.2 NOT TO SCALE