

ARCHITECT
CONSULTANT

STAMP INVALID UNLESS SIGNED

STAMP INVALID UNLESS SIGNED



EAST SIDE OF SANCTUARY PLUMBING PLAN

**Retrofit & Renovations for
Madison Methodist Church**
Madison, Georgia 30650
1091 Confederate Highway

JOB NO.:	02405
DRAWN BY:	JWK/KMP
CHECKED BY:	KMP
DESCRIPTION:	CD-REVIEW-DOCS
DATE:	12.02.24
DESCRIPTION:	DD-REVIEW
DATE:	00.00.24
DESCRIPTION:	CD-REVIEW
DATE:	12.02.24
DESCRIPTION:	BID-CONSTRUCTION
DATE:	00.00.24


REVISIONS:	
1	
2	
3	
4	
5	
6	
7	

THESE DRAWINGS ARE THE PROPERTY OF GMARCHITECT AND ARE NOT TO BE REPRODUCED OR HELD WITHOUT PERMISSION AND CREDIT.
COPYRIGHT © 2024

SHEET

P1.02

OF

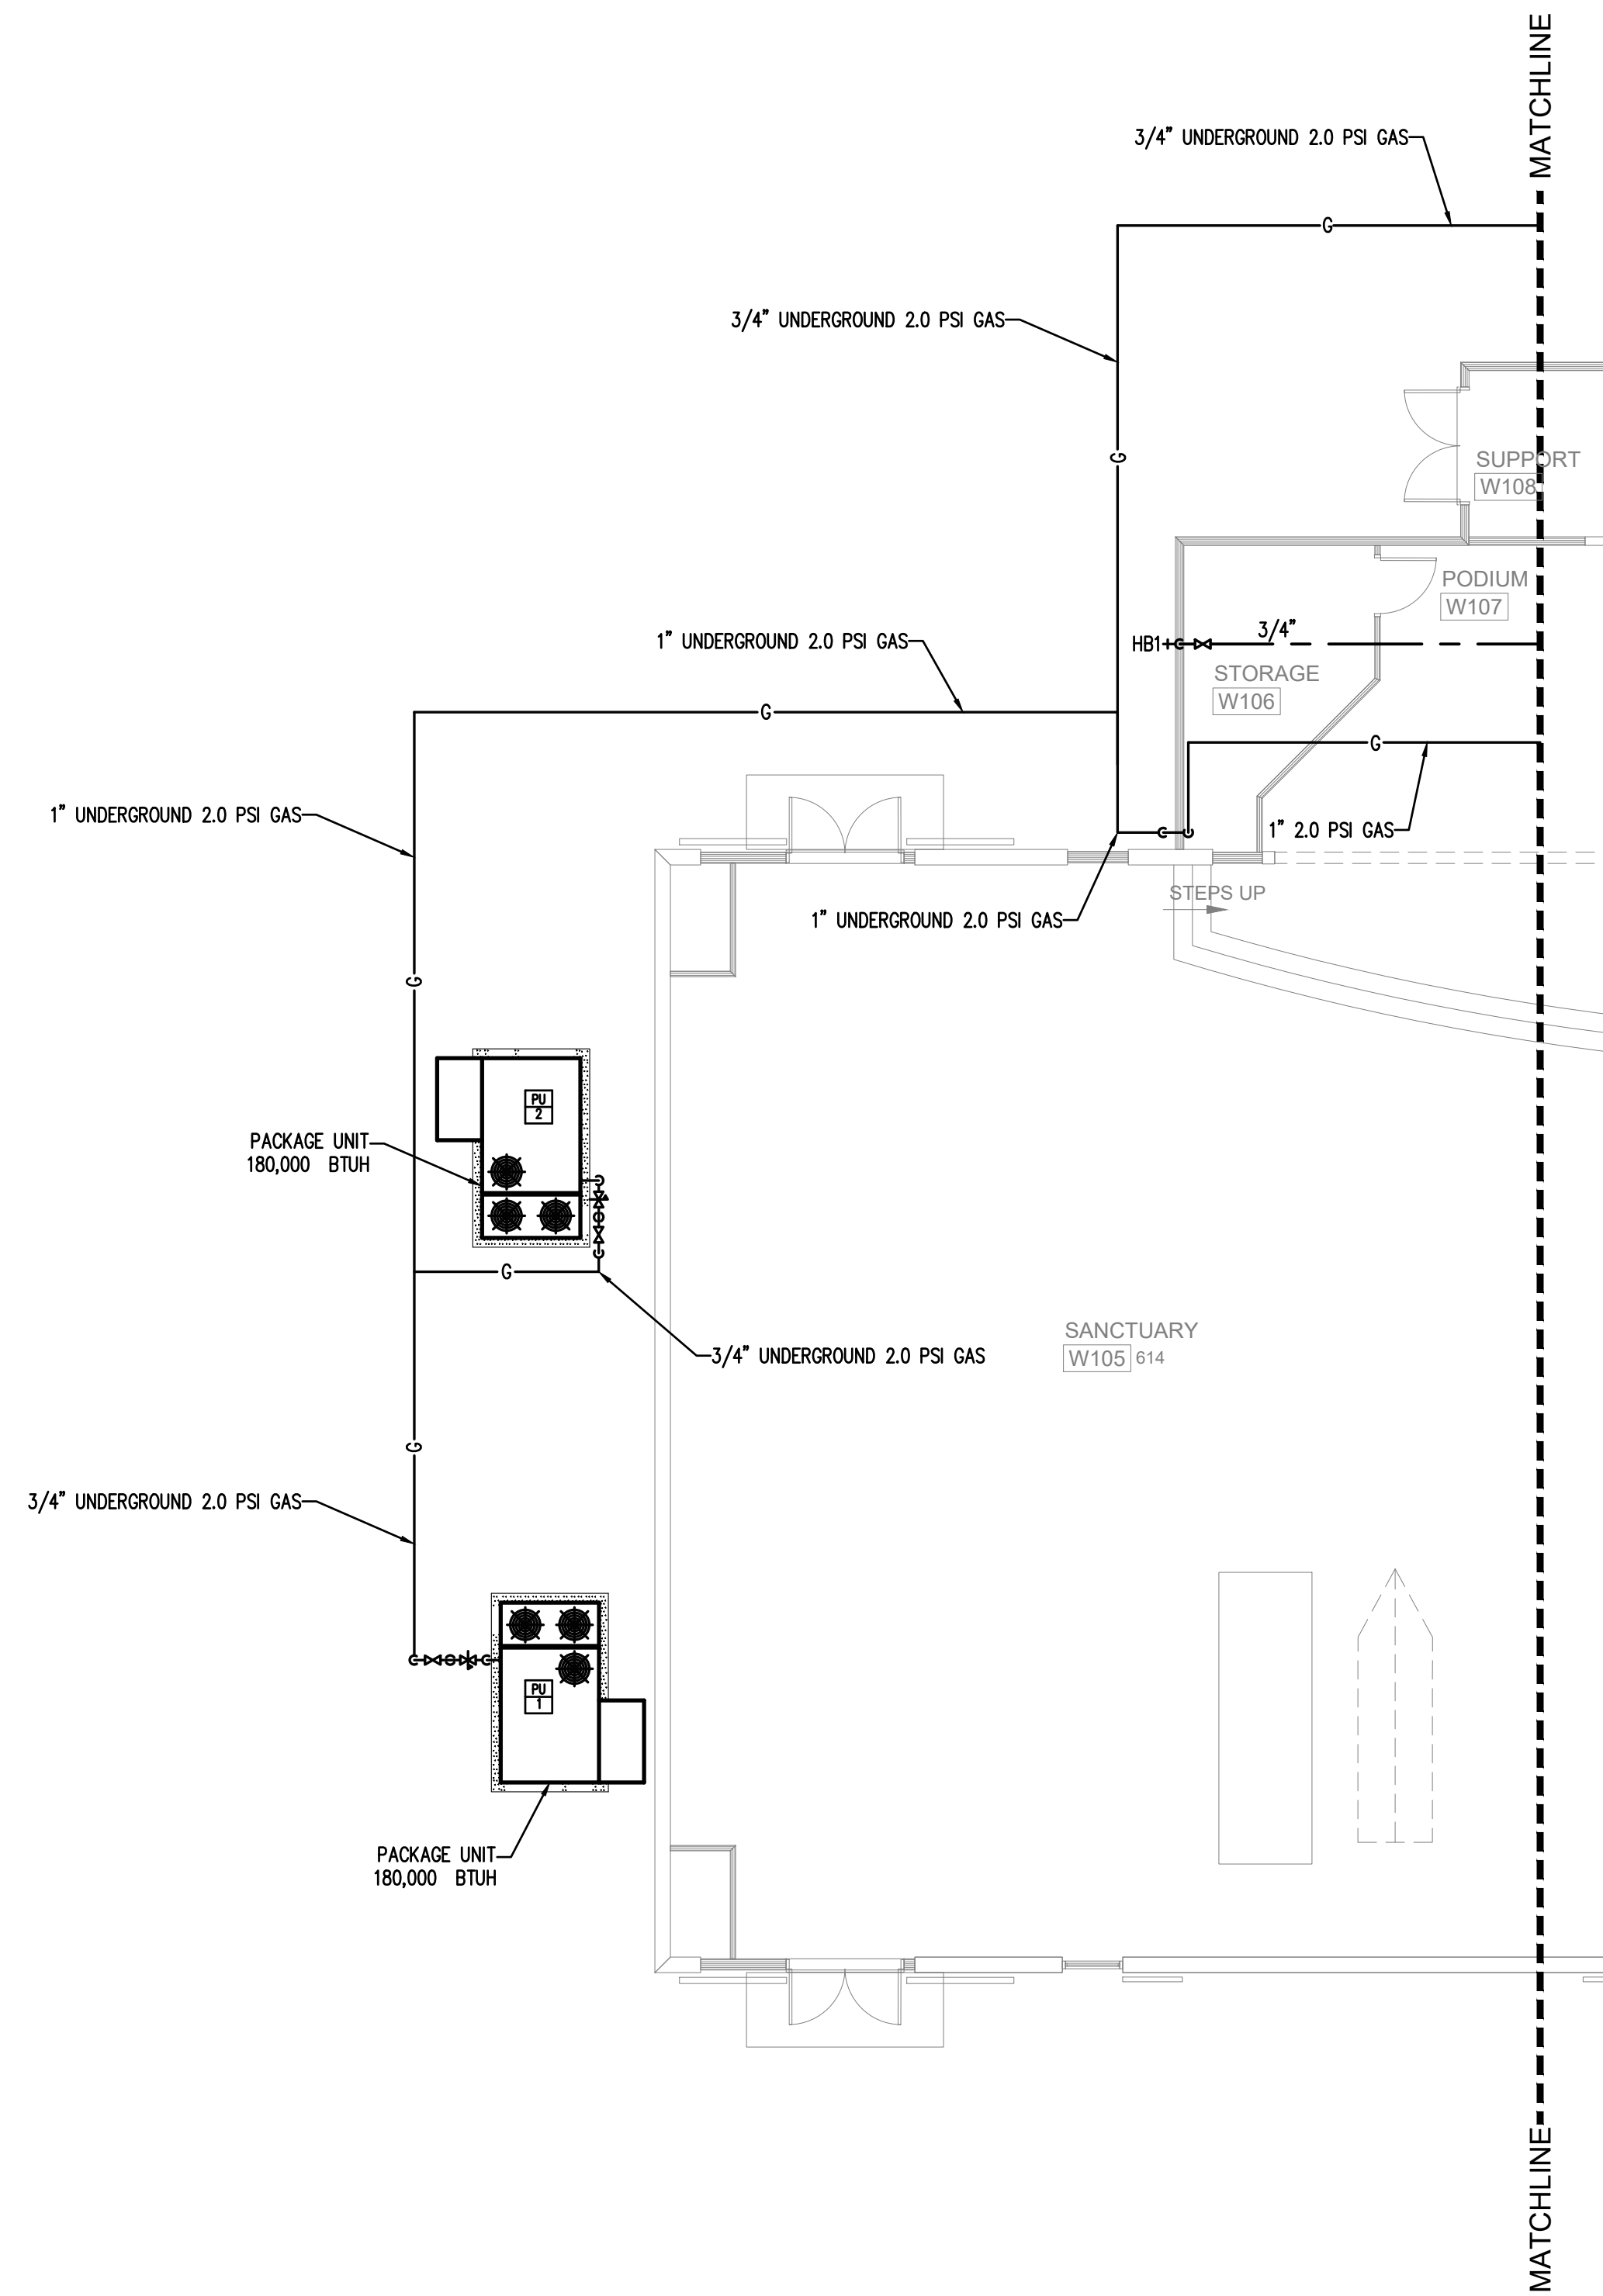

1 EAST SIDE OF SANCTUARY PLUMBING PLAN
SCALE: 1/8"=1'-0"

