




1 WORSHIP MEN'S RESTROOM
PLUMBING PLAN - SEWER
SCALE: 1/4"=1'-0"

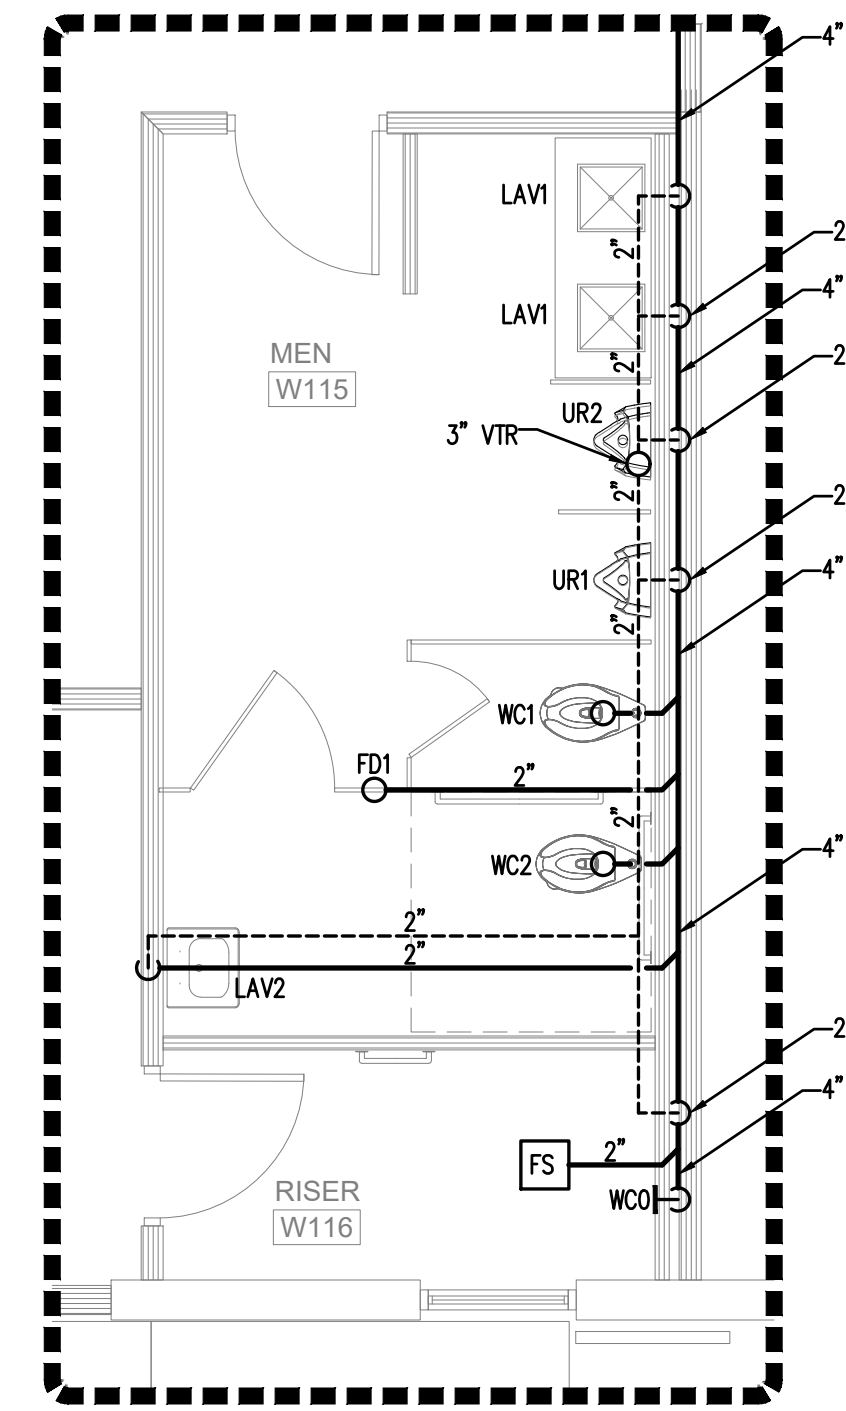


3 WORSHIP MEN'S RESTROOM
PLUMBING PLAN - SEWER
SCALE: 1/4"=1'-0"

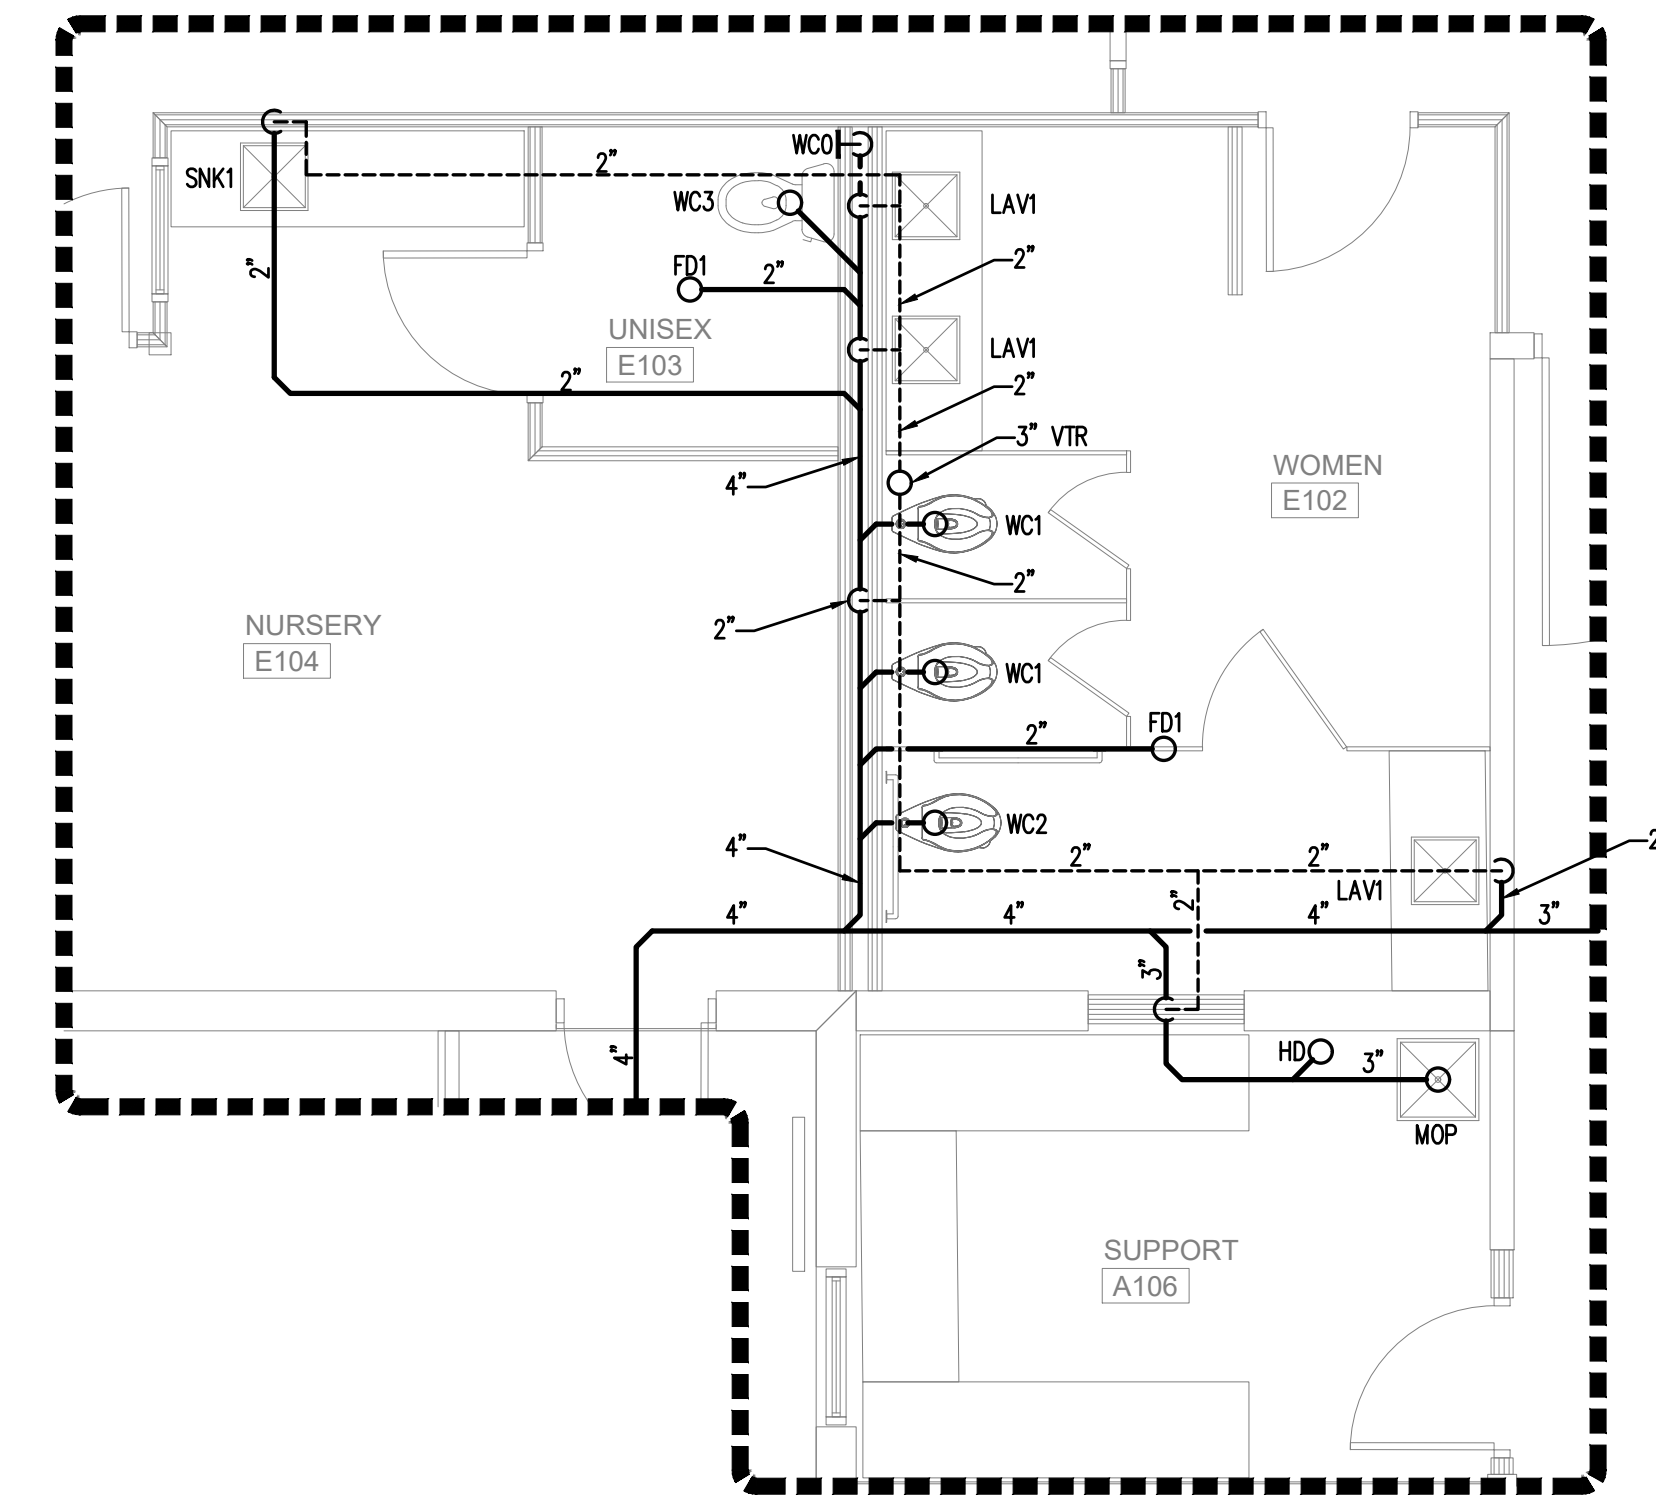


7 EDUCATION WOMEN'S RESTROOM
PLUMBING PLAN - SEWER
SCALE: 1/4"=1'-0"

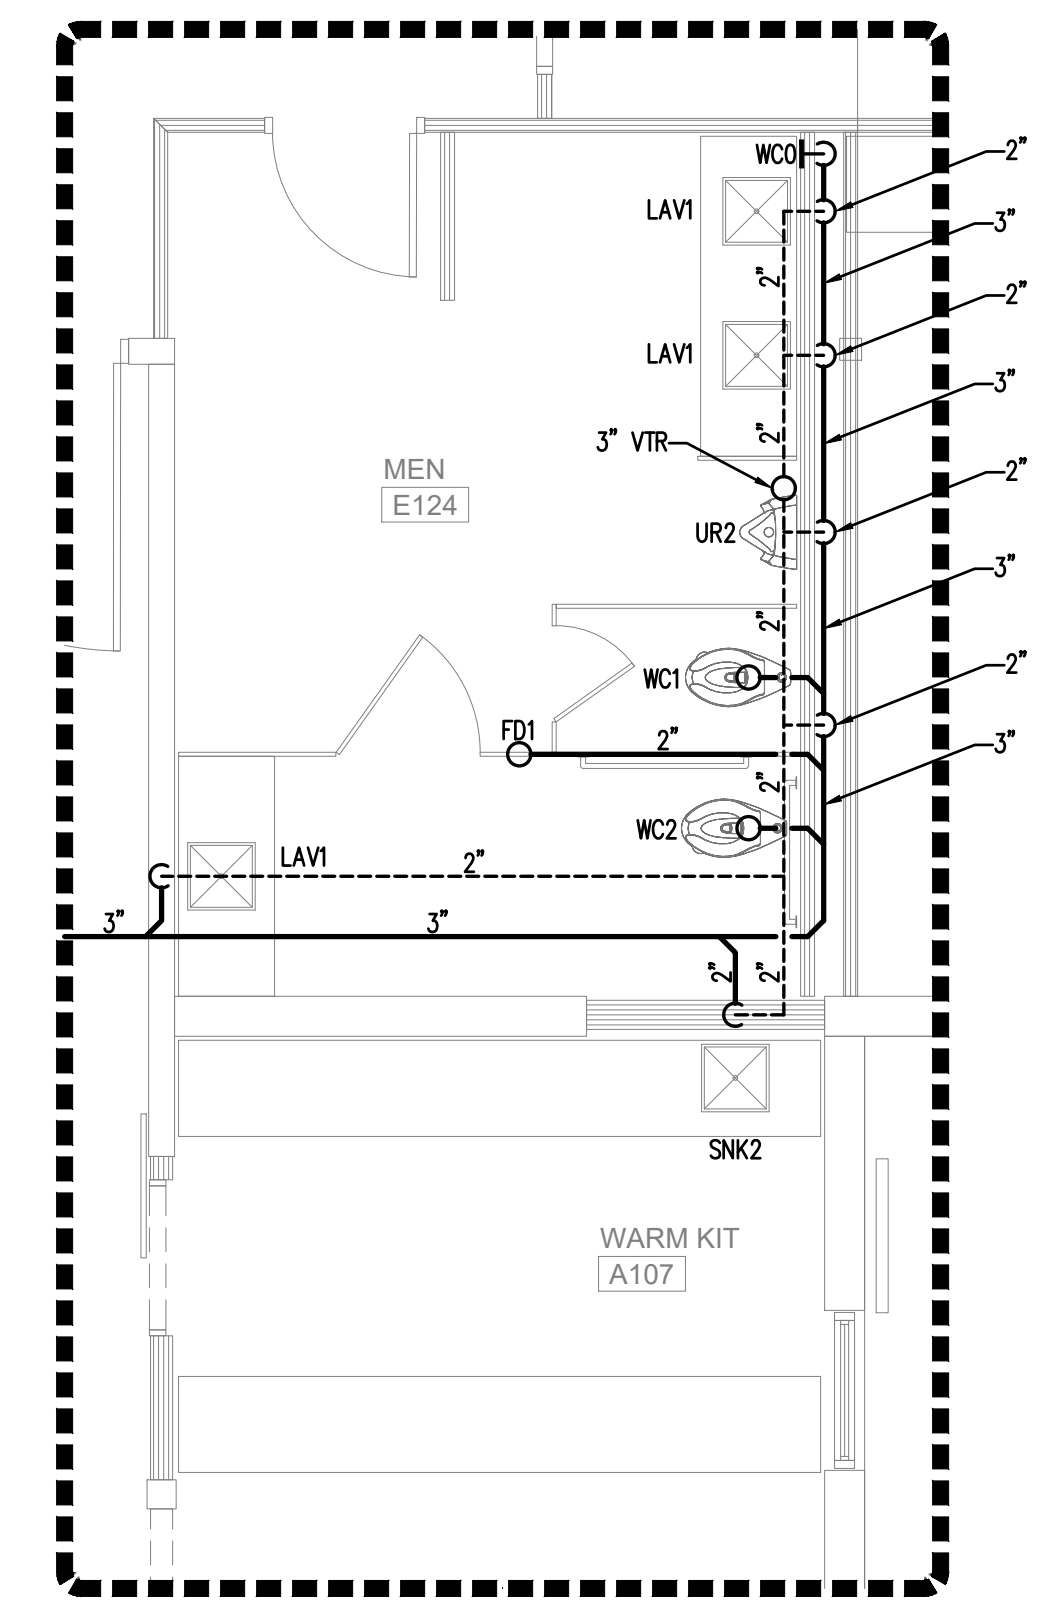


9 EDUCATION MEN'S RESTROOM
PLUMBING PLAN - SEWER
SCALE: 1/4"=1'-0"

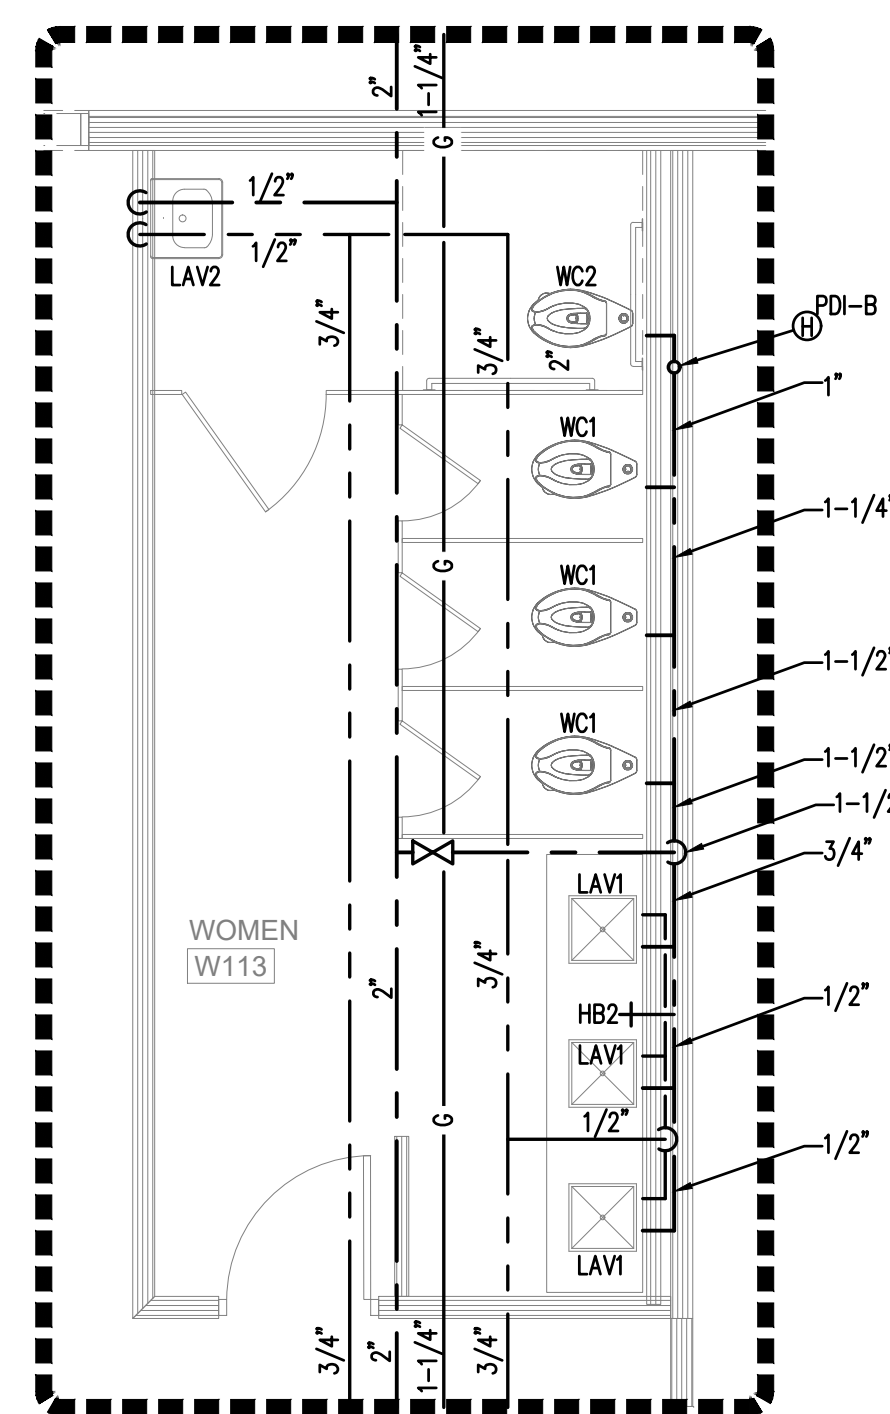


2 WORSHIP MEN'S RESTROOM
PLUMBING PLAN - WATER
SCALE: 1/4"=1'-0"

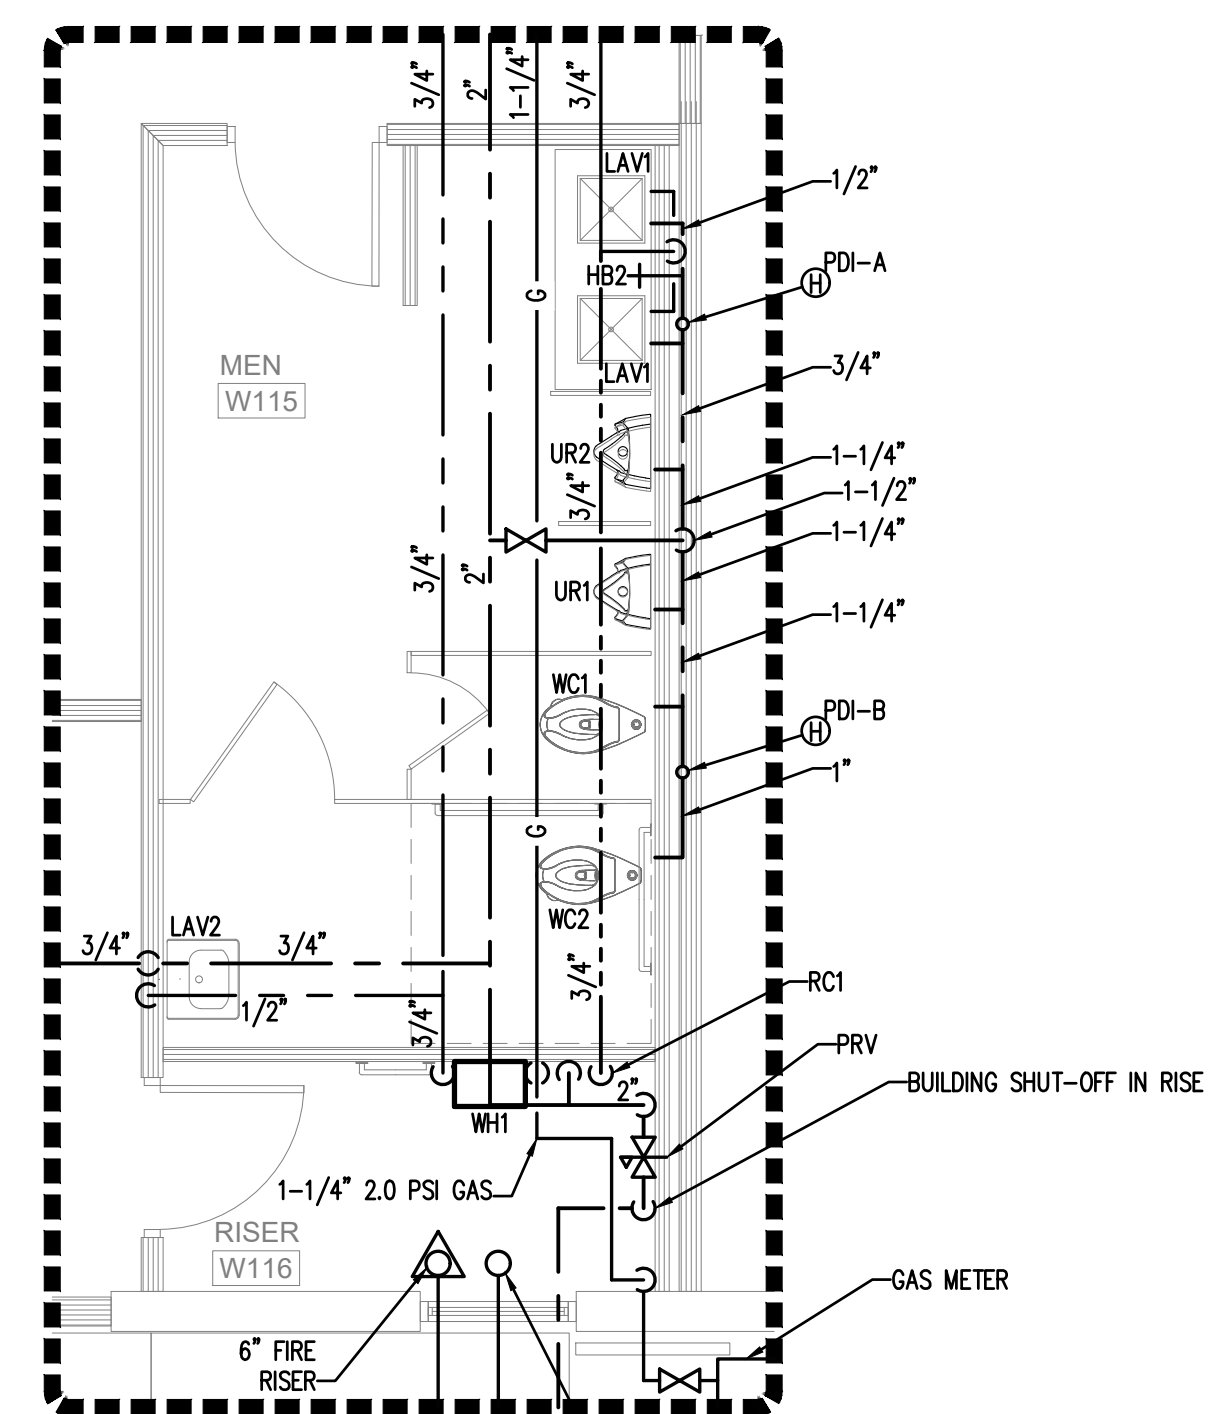


4 WORSHIP MEN'S RESTROOM
PLUMBING PLAN - WATER
SCALE: 1/4"=1'-0"

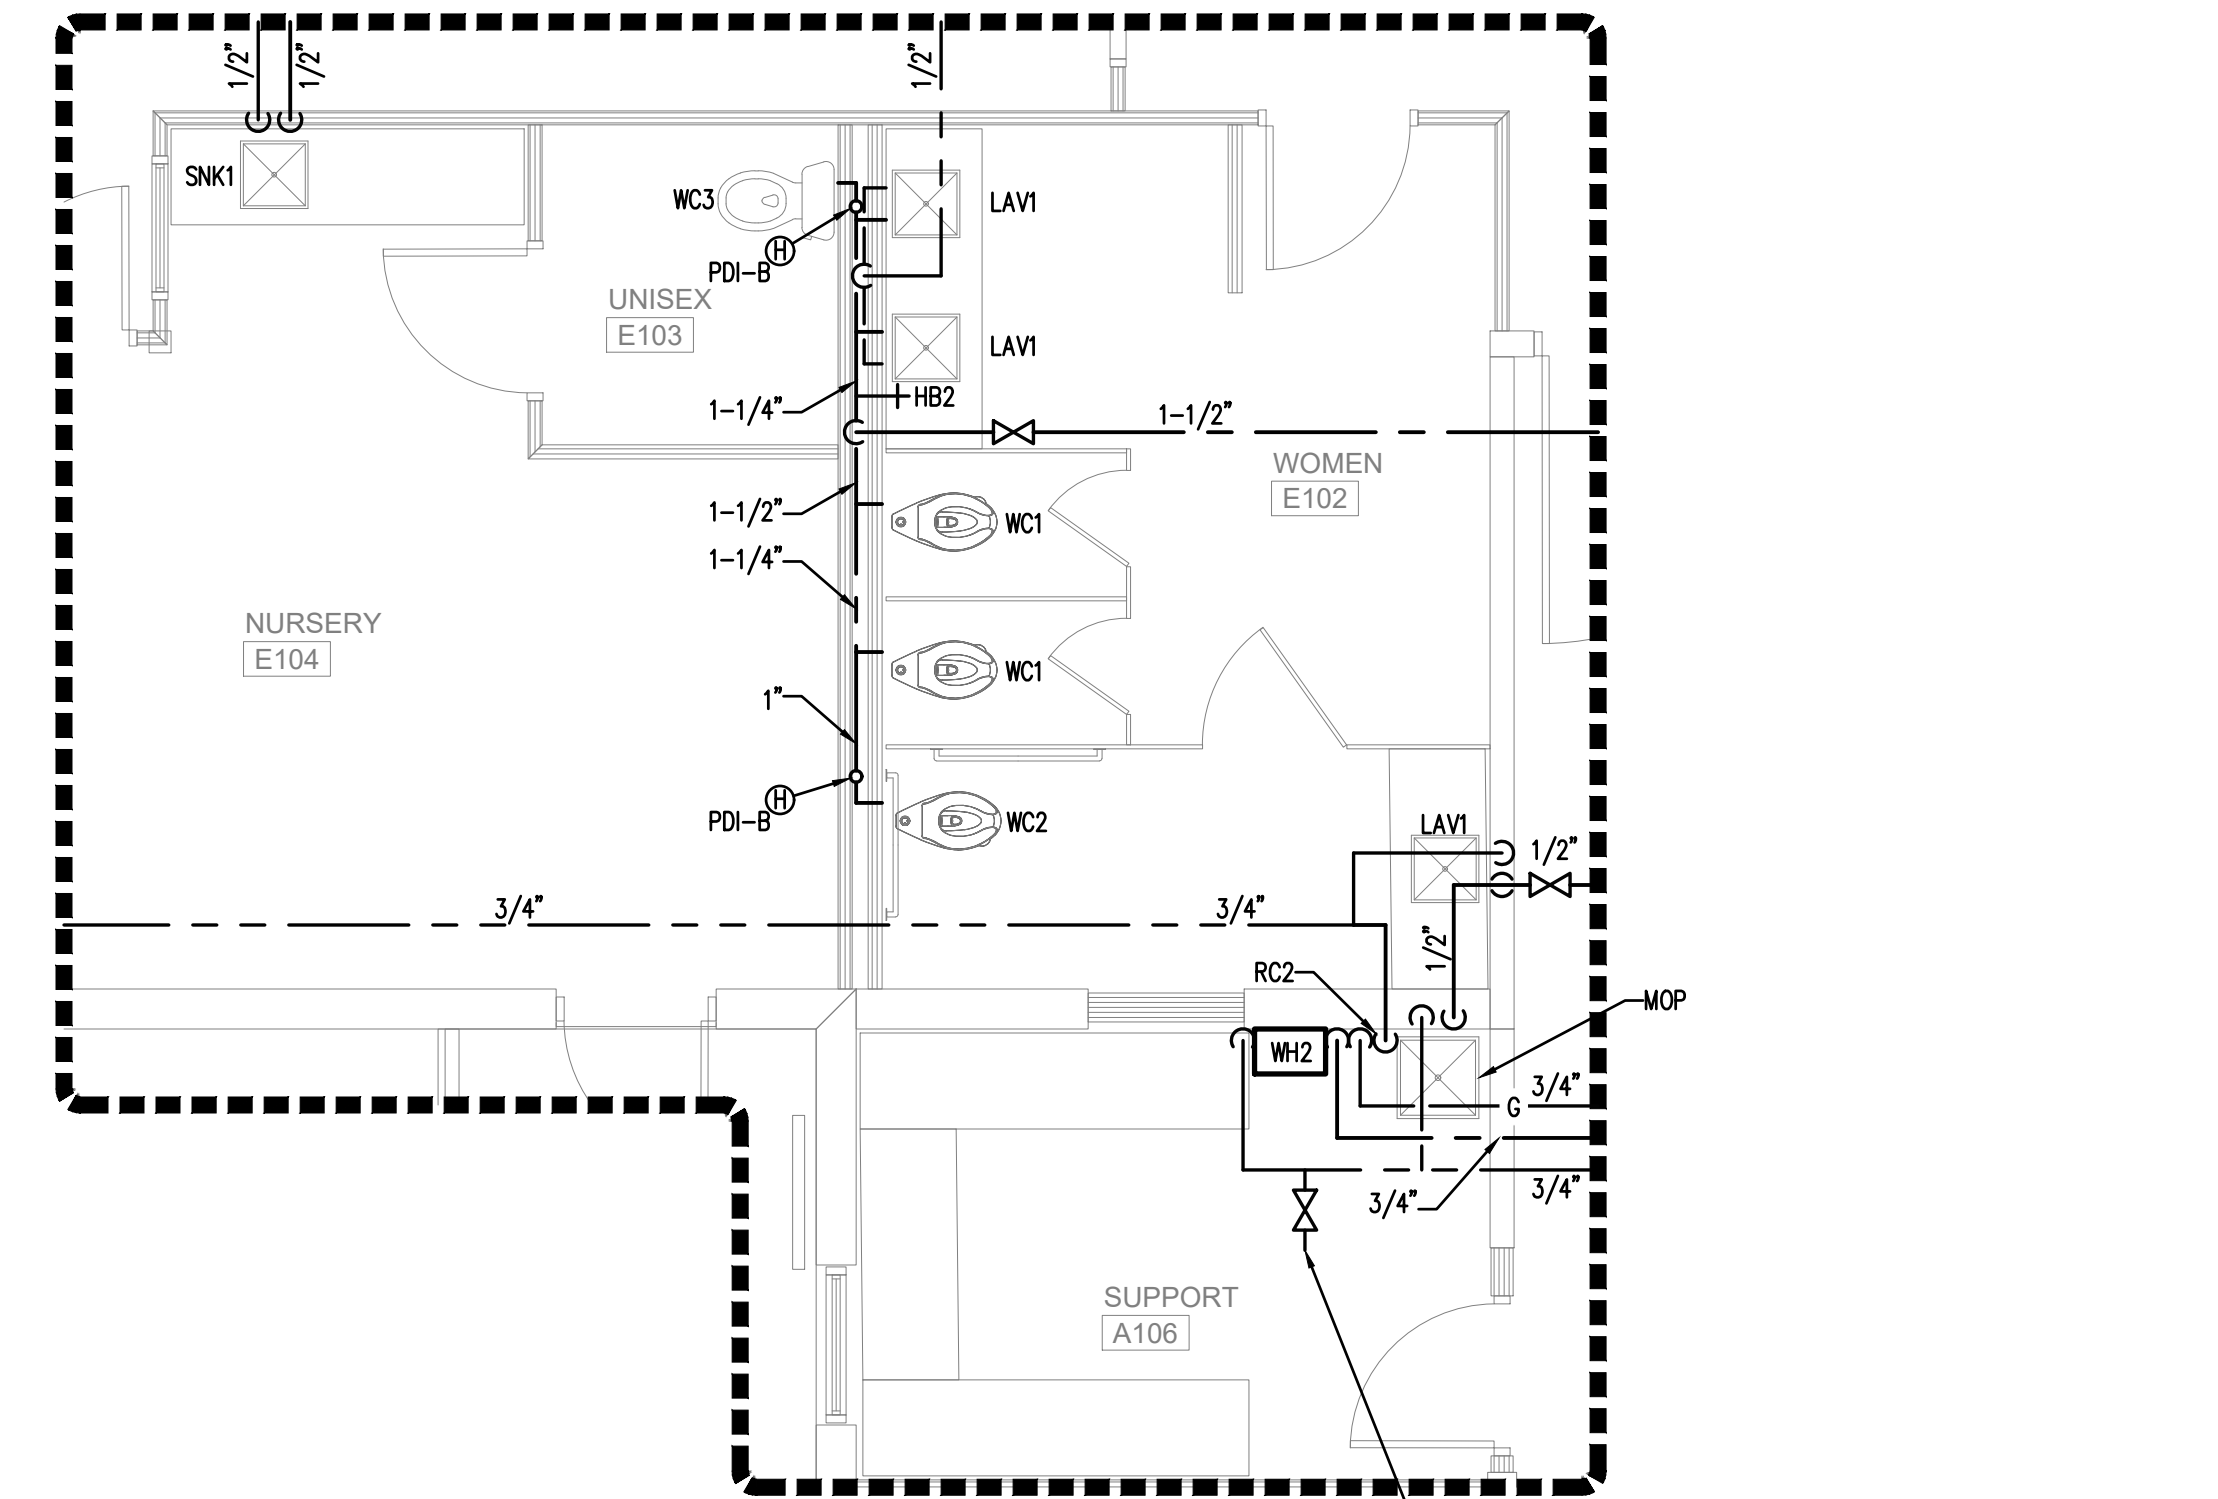


8 EDUCATION WOMEN'S RESTROOM
PLUMBING PLAN - WATER
SCALE: 1/4"=1'-0"

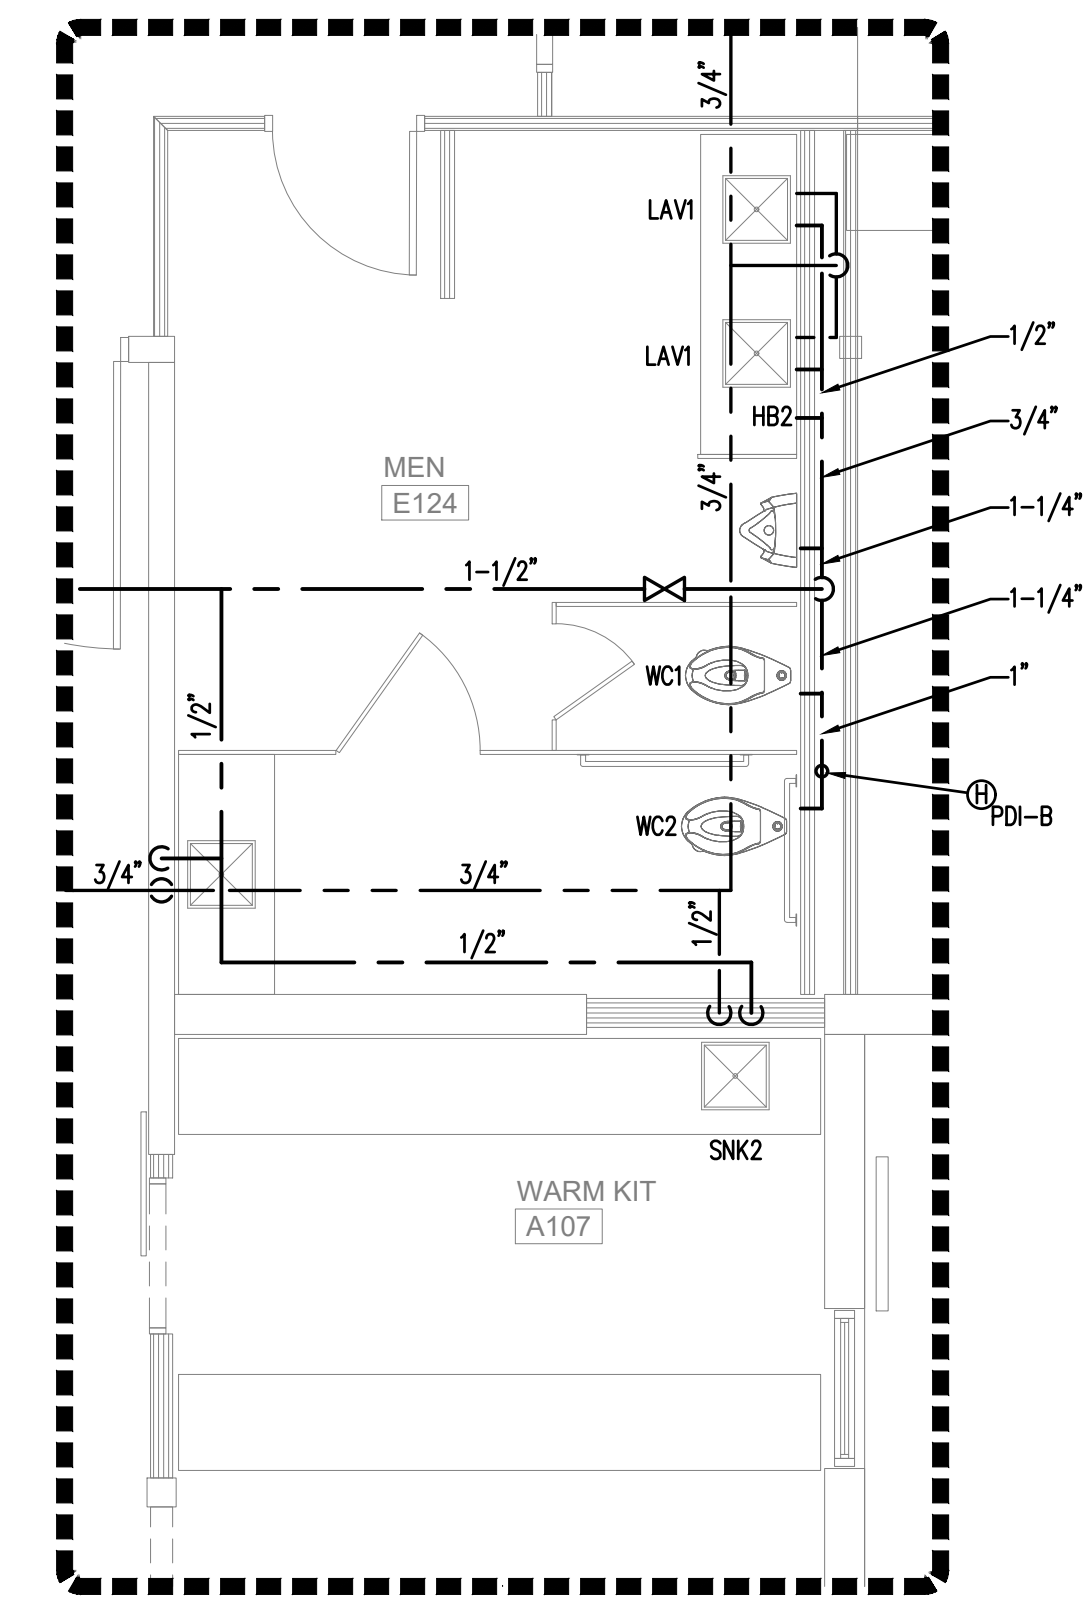

10 EDUCATION MEN'S RESTROOM
PLUMBING PLAN - WATER
SCALE: 1/4"=1'-0"

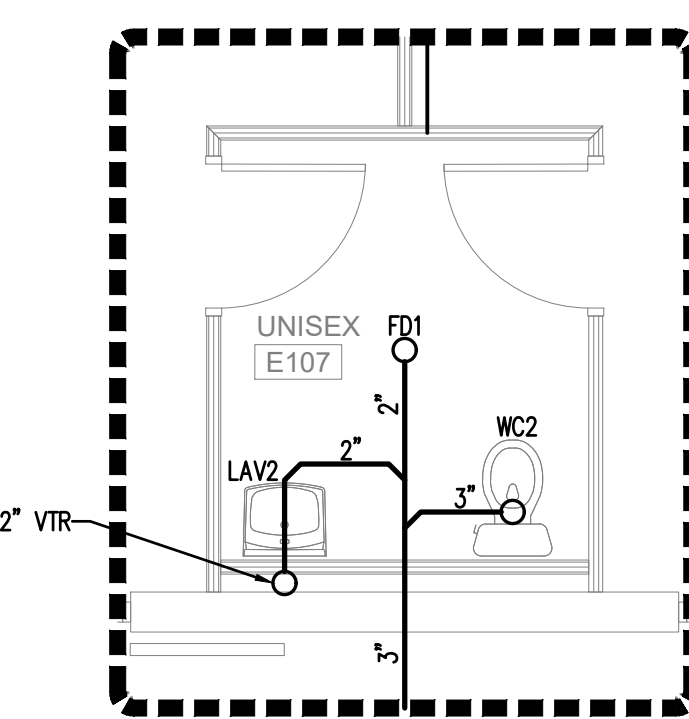

5 EDUCATION CLASSROOM RESTROOM
PLUMBING PLAN - SEWER
SCALE: 1/4"=1'-0"

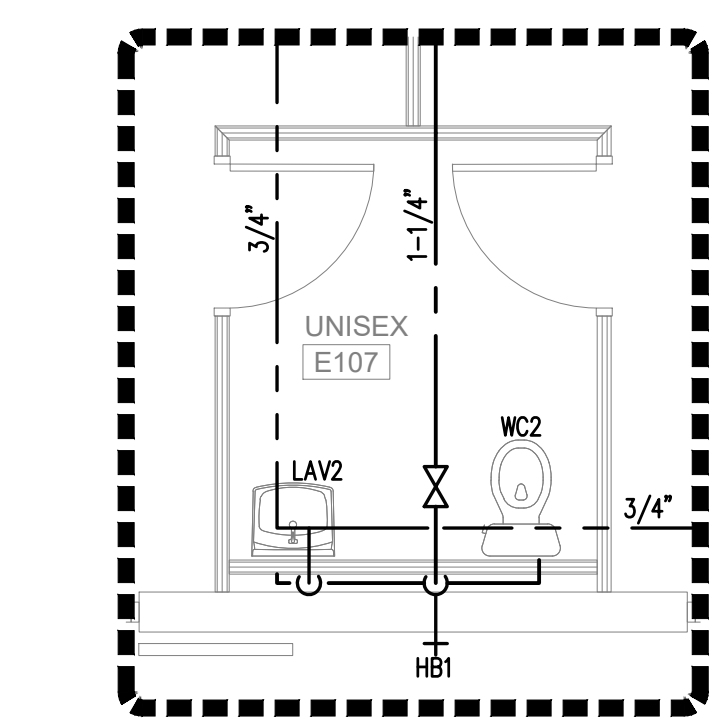

6 EDUCATION CLASSROOM RESTROOM
PLUMBING PLAN - WATER
SCALE: 1/4"=1'-0"

ARCHITECT

CONSULTANT

ENLARGED PLUMBING PLANS

**Retrofit & Renovations for
Madison Methodist Church**
Madison, Georgia 30650
1091 Confederate Highway

JOB NO.:	02405
DRAWN BY:	JWK/KMP
CHECKED BY:	KMP
DESCRIPTION:	CD-REVIEW-DOCS
DATE:	12.02.24
DESCRIPTION:	DD-REVIEW
DATE:	00.00.24
DESCRIPTION:	CD-REVIEW
DATE:	12.02.24
DESCRIPTION:	BID-CONSTRUCTION
DATE:	00.00.24
REVISIONS:	
1	
2	
3	
4	
5	
6	
7	
8	
9	
10	

THESE DRAWINGS ARE THE PROPERTY OF GMARCHITECT AND ARE NOT TO BE REPRODUCED OR HELD WITHOUT PERMISSION AND CREDIT.
COPYRIGHT © 2024

SHEET

OF