

**Retrofit & Renovations for
Madison Methodist Church**
1091 Confederate Highway
Madison, Georgia 30650

JOB NO.:	02405
DRAWN BY:	JWK/KMP
CHECKED BY:	KMP
DESCRIPTION:	CD-REVIEW-DOCS
DATE:	12.02.24
DESCRIPTION:	DD-REVIEW
DATE:	00.00.24
DESCRIPTION:	CD-REVIEW
DATE:	12.02.24
DESCRIPTION:	BID-CONSTRUCTION
DATE:	00.00.24


1	
2	
3	
4	
5	
6	
7	
8	
9	
10	

THESE DRAWINGS ARE THE PROPERTY OF GMARCHITECT AND ARE NOT TO BE REPRODUCED OR HELD WITHOUT PERMISSION AND CREDIT.
COPYRIGHT © 2024

SHEET

M1.01

OF

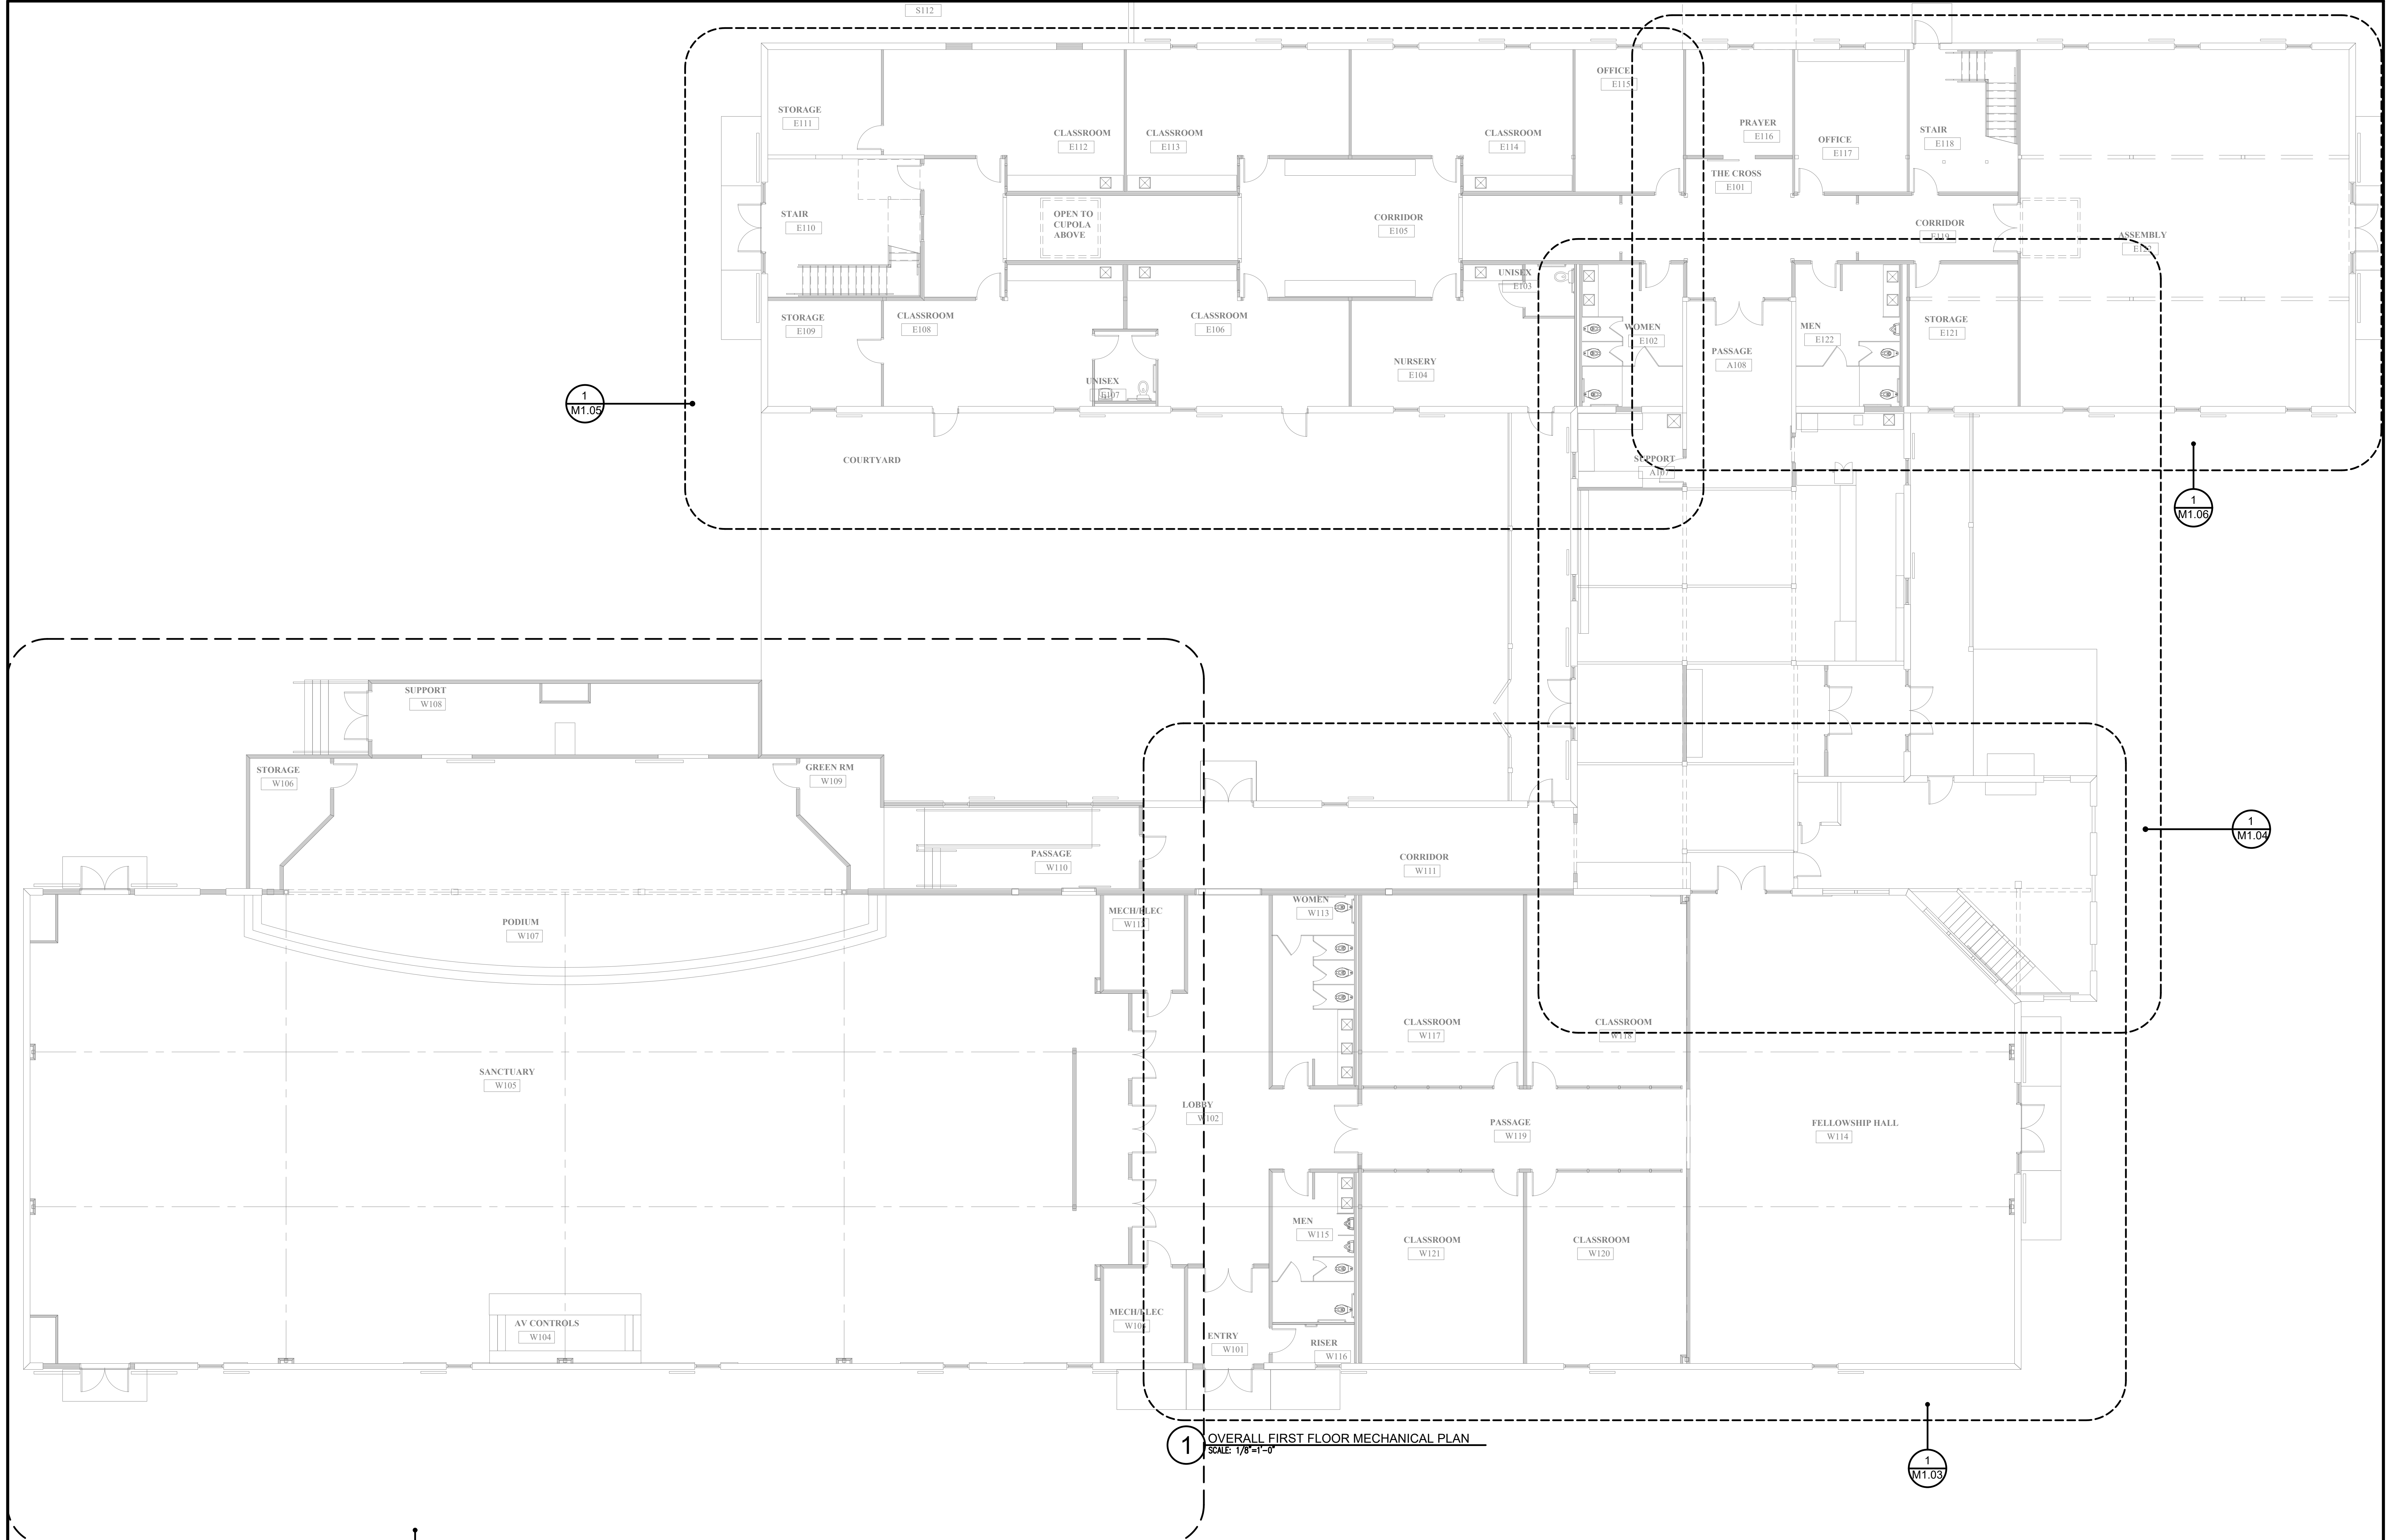

1 OVERALL FIRST FLOOR MECHANICAL PLAN
SCALE: 1/8"=1'-0"