

ARCHITECT

STAMP INVALID UNLESS SIGNED

CONSULTANT

STAMP INVALID UNLESS SIGNED

WORSHIP MECHANICAL PLAN-PHASE I

**Retrofit & Renovations for
Madison Methodist Church**
Madison, Georgia 30650
1091 Confederate Highway

JOB NO.: 02405
DRAWN BY: JWK/KMP
CHECKED BY: KMP

DESCRIPTION: CD-REVIEW-DOCS

DATE: 12.02.24

DESCRIPTION: DD-REVIEW

DATE: 00.00.24

DESCRIPTION: CD-REVIEW

DATE: 12.02.24

DESCRIPTION: BID-CONSTRUCTION

DATE: 00.00.24

NO.	DESCRIPTION
1	
2	
3	
4	
5	
6	
7	
8	
9	
10	

THESE DRAWINGS ARE THE PROPERTY OF GMARCHITECT AND ARE NOT TO BE REPRODUCED OR HELD WITHOUT PERMISSION AND CREDIT.
COPYRIGHT © 2024


SHEET

M1.02

OF

KEY NOTES (THIS SHEET ONLY):

- 1 UNIT ACCESS SPACE.
- 2 EXPOSED FABRIC SUPPLY AIR DUCTWORK. CONTRACTOR SHALL PROVIDE ROLLED EDGE AT FABRIC DUCT CONNECTION. REFER TO MANUFACTURER'S DETAIL AND SPECIFICATION FOR FURTHER INFORMATION. FABRIC DUCT LAYOUT BASIS: FRIBODA. DUCTWORK SHALL BE COORDINATED WITH MANUFACTURER. CONTRACTOR SHALL PROVIDE CORRECT AIRFLOW INFORMATION TO FABRIC DUCT MANUFACTURER TO CORRECTLY SIZE DUCT WORK PER MANUFACTURER'S CRITERIA. DUCTWORK SHALL BE NON-COLLAPSIBLE. REFER TO FABRIC DUCT SCHEDULE. LOCATE HIGH AT STRUCTURE. PROVIDE HIGH THROW DIFFUSERS. COORDINATE THE HEIGHT OF SPACE WITH MANUFACTURER.
- 3 STARTING POINT OF FABRIC DUCT WORK.
- 4 RETURN AIR GRILL AT 12" AFF. PROVIDE FULL SIZE LINED SHEET METAL PLENUM BEHIND GRILL.
- 5 NOT USED.
- 6 NOT USED.
- 7 REFER TO 1/M1.03 FOR CONTINUATION.
- 8 PROVIDE LINER FOR FIRST FIVE FEET OF BOTH SUPPLY AIR AND RETURN AIR DUCT LOCATED INSIDE BUILDING.
- 9 FIELD INSTALLED RELIEF DAMPER AIR HOOD ON RETURN AIR DUCT.
- 10 CONTRACTOR SHALL COORDINATE CEILING TYPE WITH THE INTERIOR DESIGNER AND ARCHITECTURAL DRAWINGS PRIOR TO ORDERING DIFFUSERS. DIFFUSERS SHALL BE COMPATIBLE WITH THE INTERIOR DESIGNER AND ARCHITECTURAL PLANS, AS THE RCP IS STILL IN PROGRESS. TYPICAL FOR ALL GRILLES, REGISTERS, DIFFUSERS, AND AIR NOZZLES.

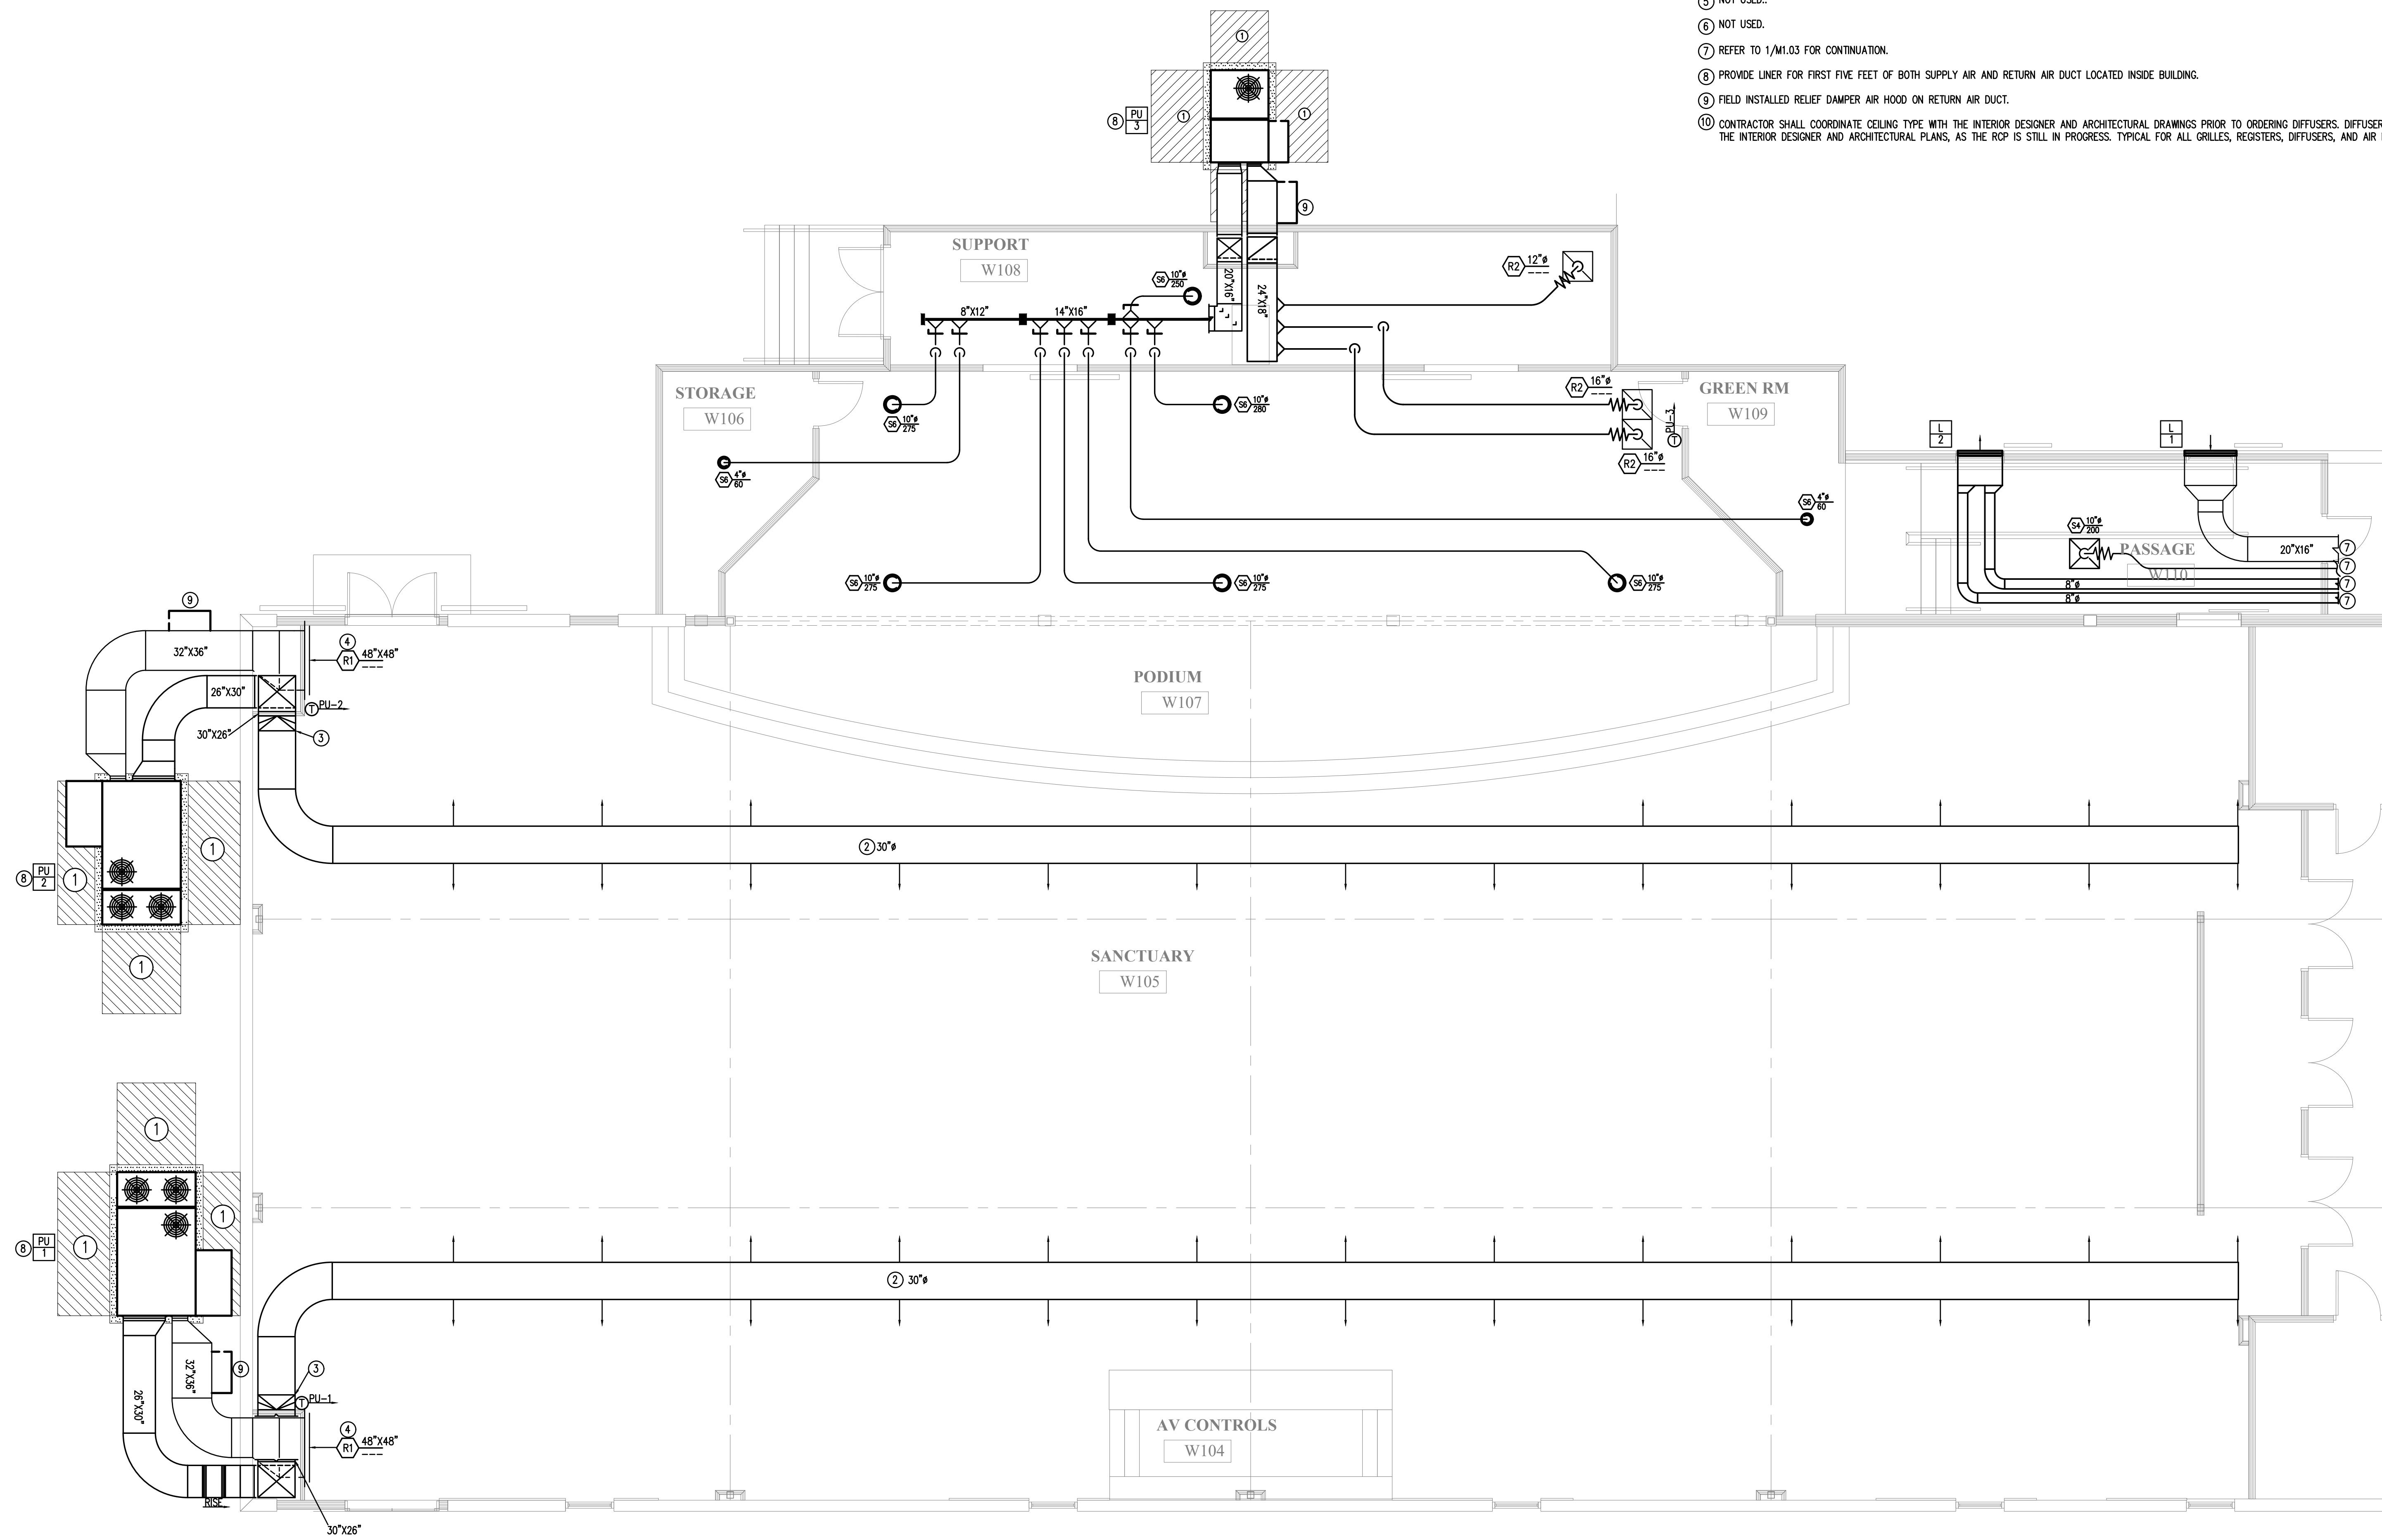

1 WORSHIP MECHANICAL PLAN - PHASE I
SCALE: 3/16"=1'-0"