


KEY NOTES (THIS SHEET ONLY):

- ① EXISTING MECHANICAL SYSTEM SERVING THIS AREA SHALL REMAIN AS IS. CONTRACTOR SHALL PROVIDE NEW GRILLS WHERE REQUIRED. CONTRACTOR SHALL RELOCATE GRILLS AS REQUIRED. CONTRACTOR SHALL REMOVE EXHAUST FANS FOR DEMOLITION BATHROOMS WITH ALL ITS ACCESSORIES AND CONTROLS.

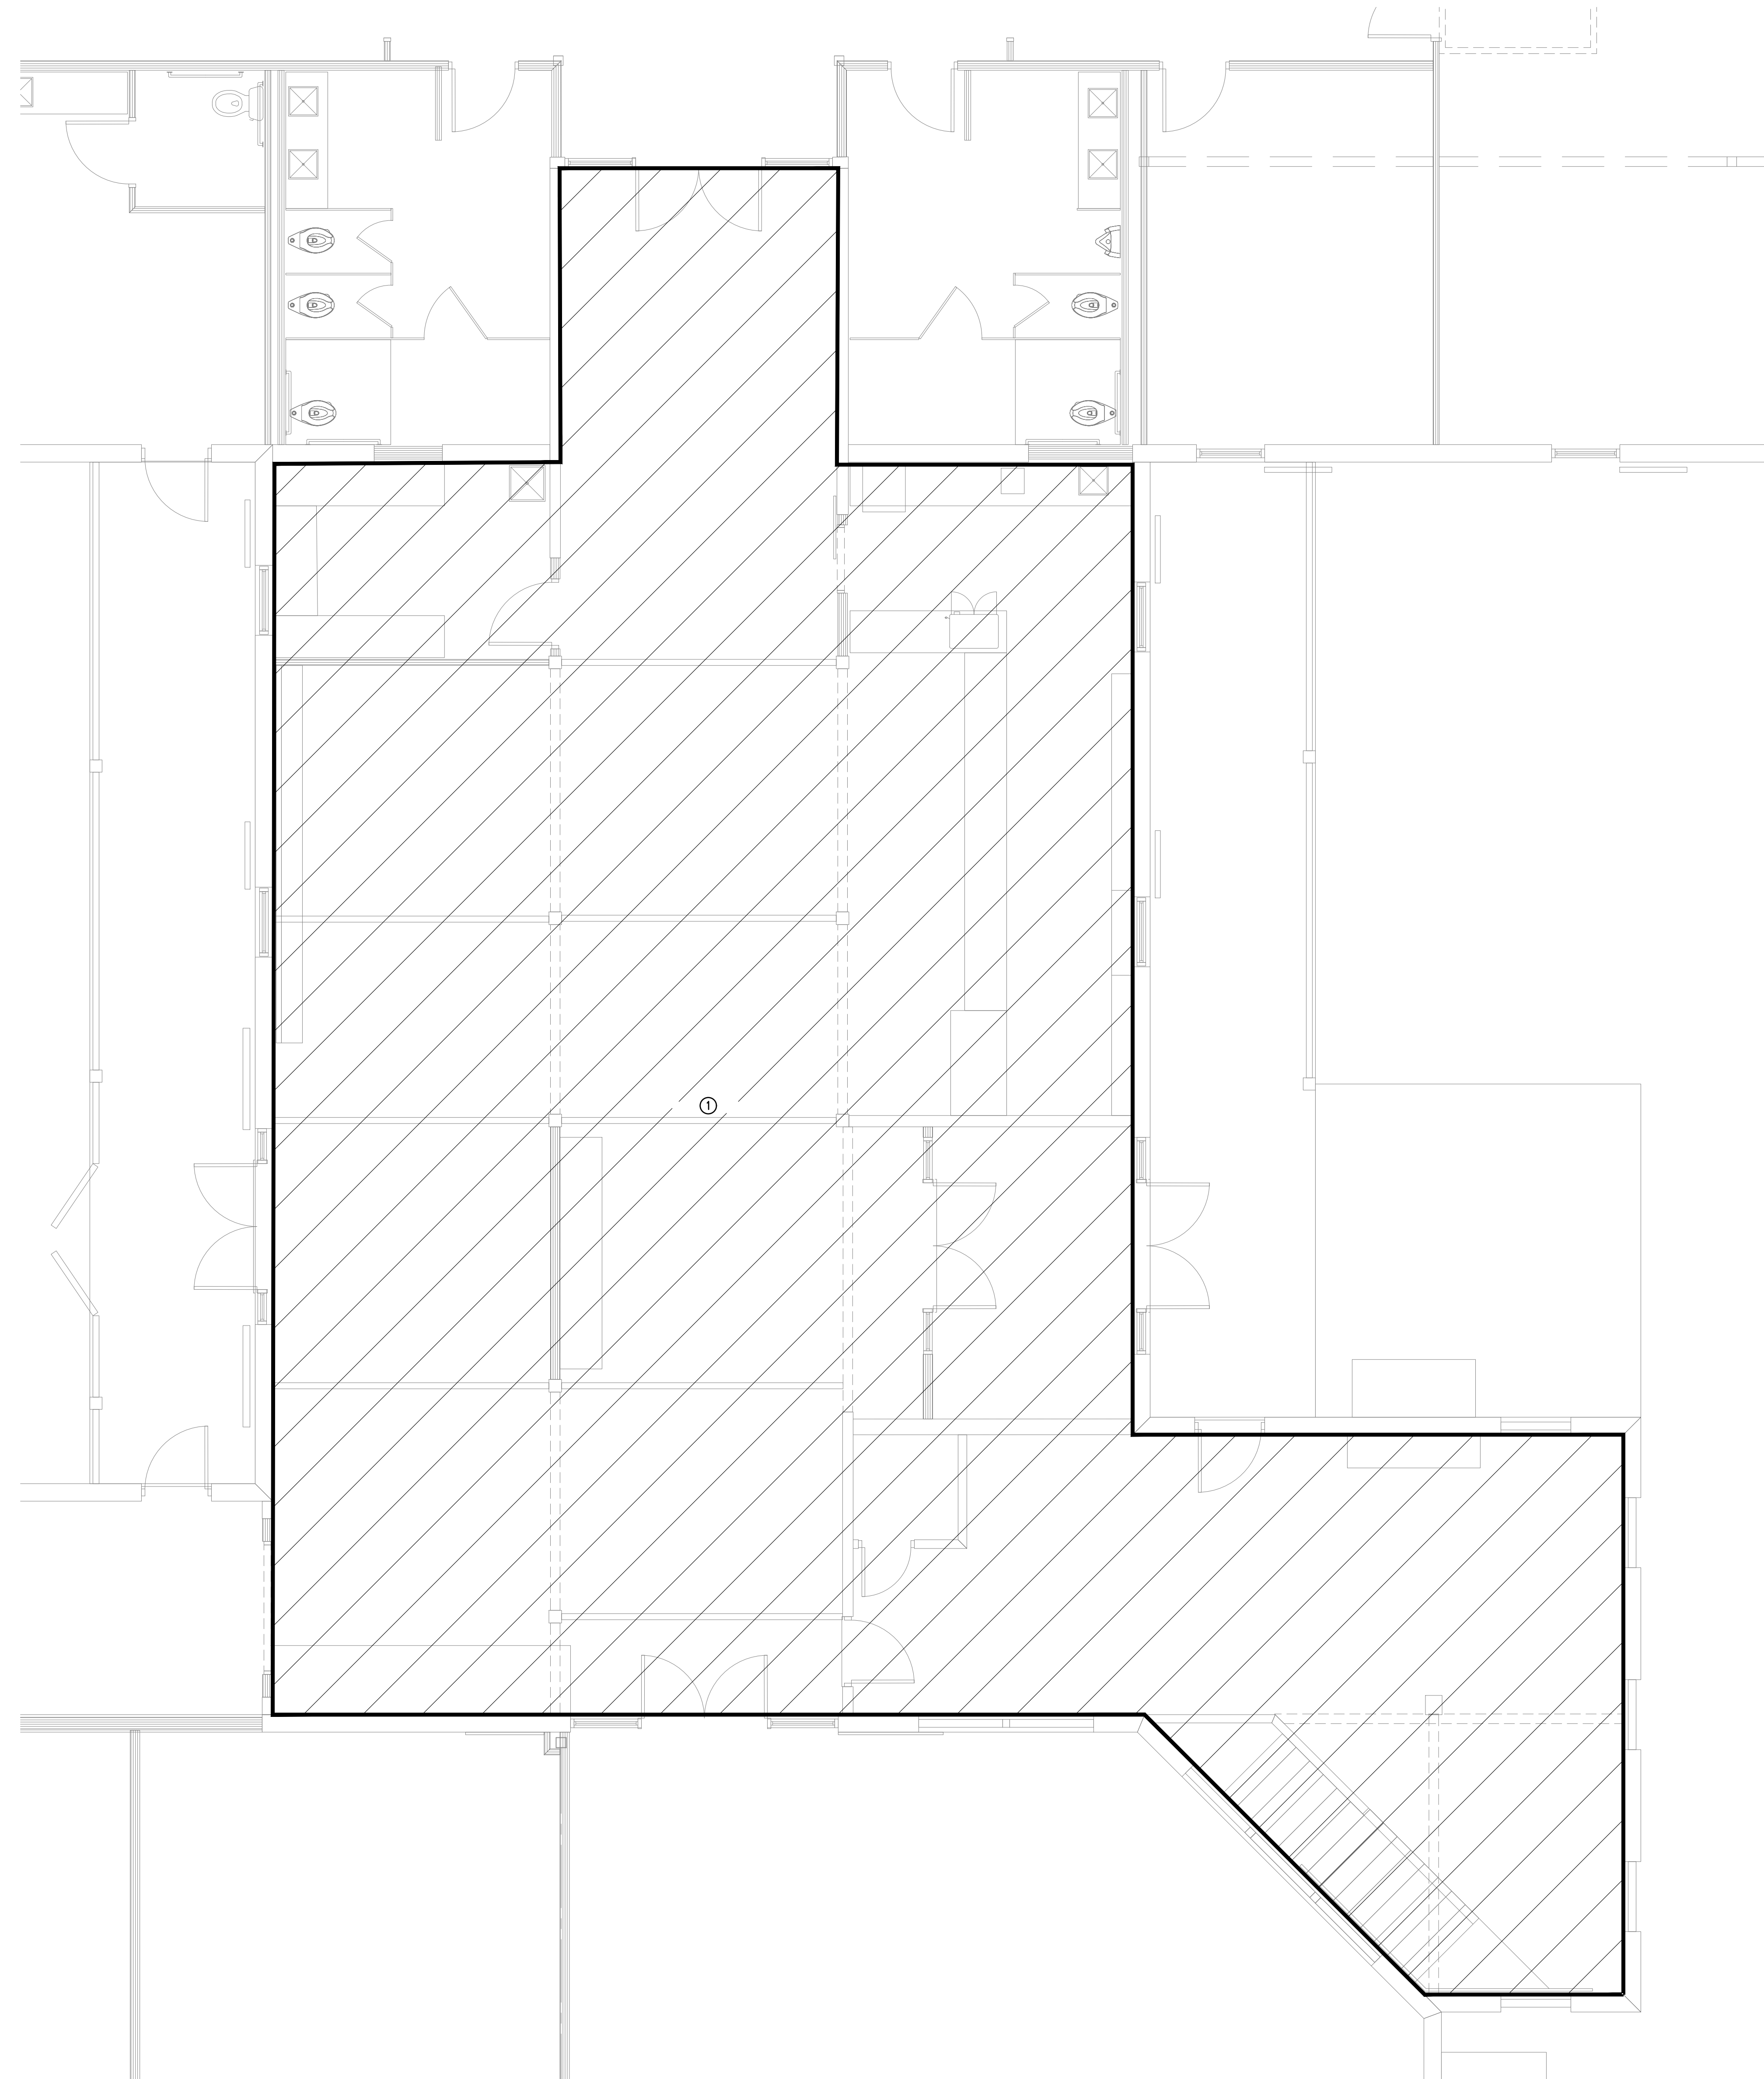

① GATHERING MECHANICAL PLAN - PHASE I  
SCALE: 1/4"=1'-0"