


Plot Date: 6/26/2026 8:48:03 AM Path: Autodeskt Docs\NCWSA Admin Bldg_V25\616202-NCWSA-PLBG_V25.rvt

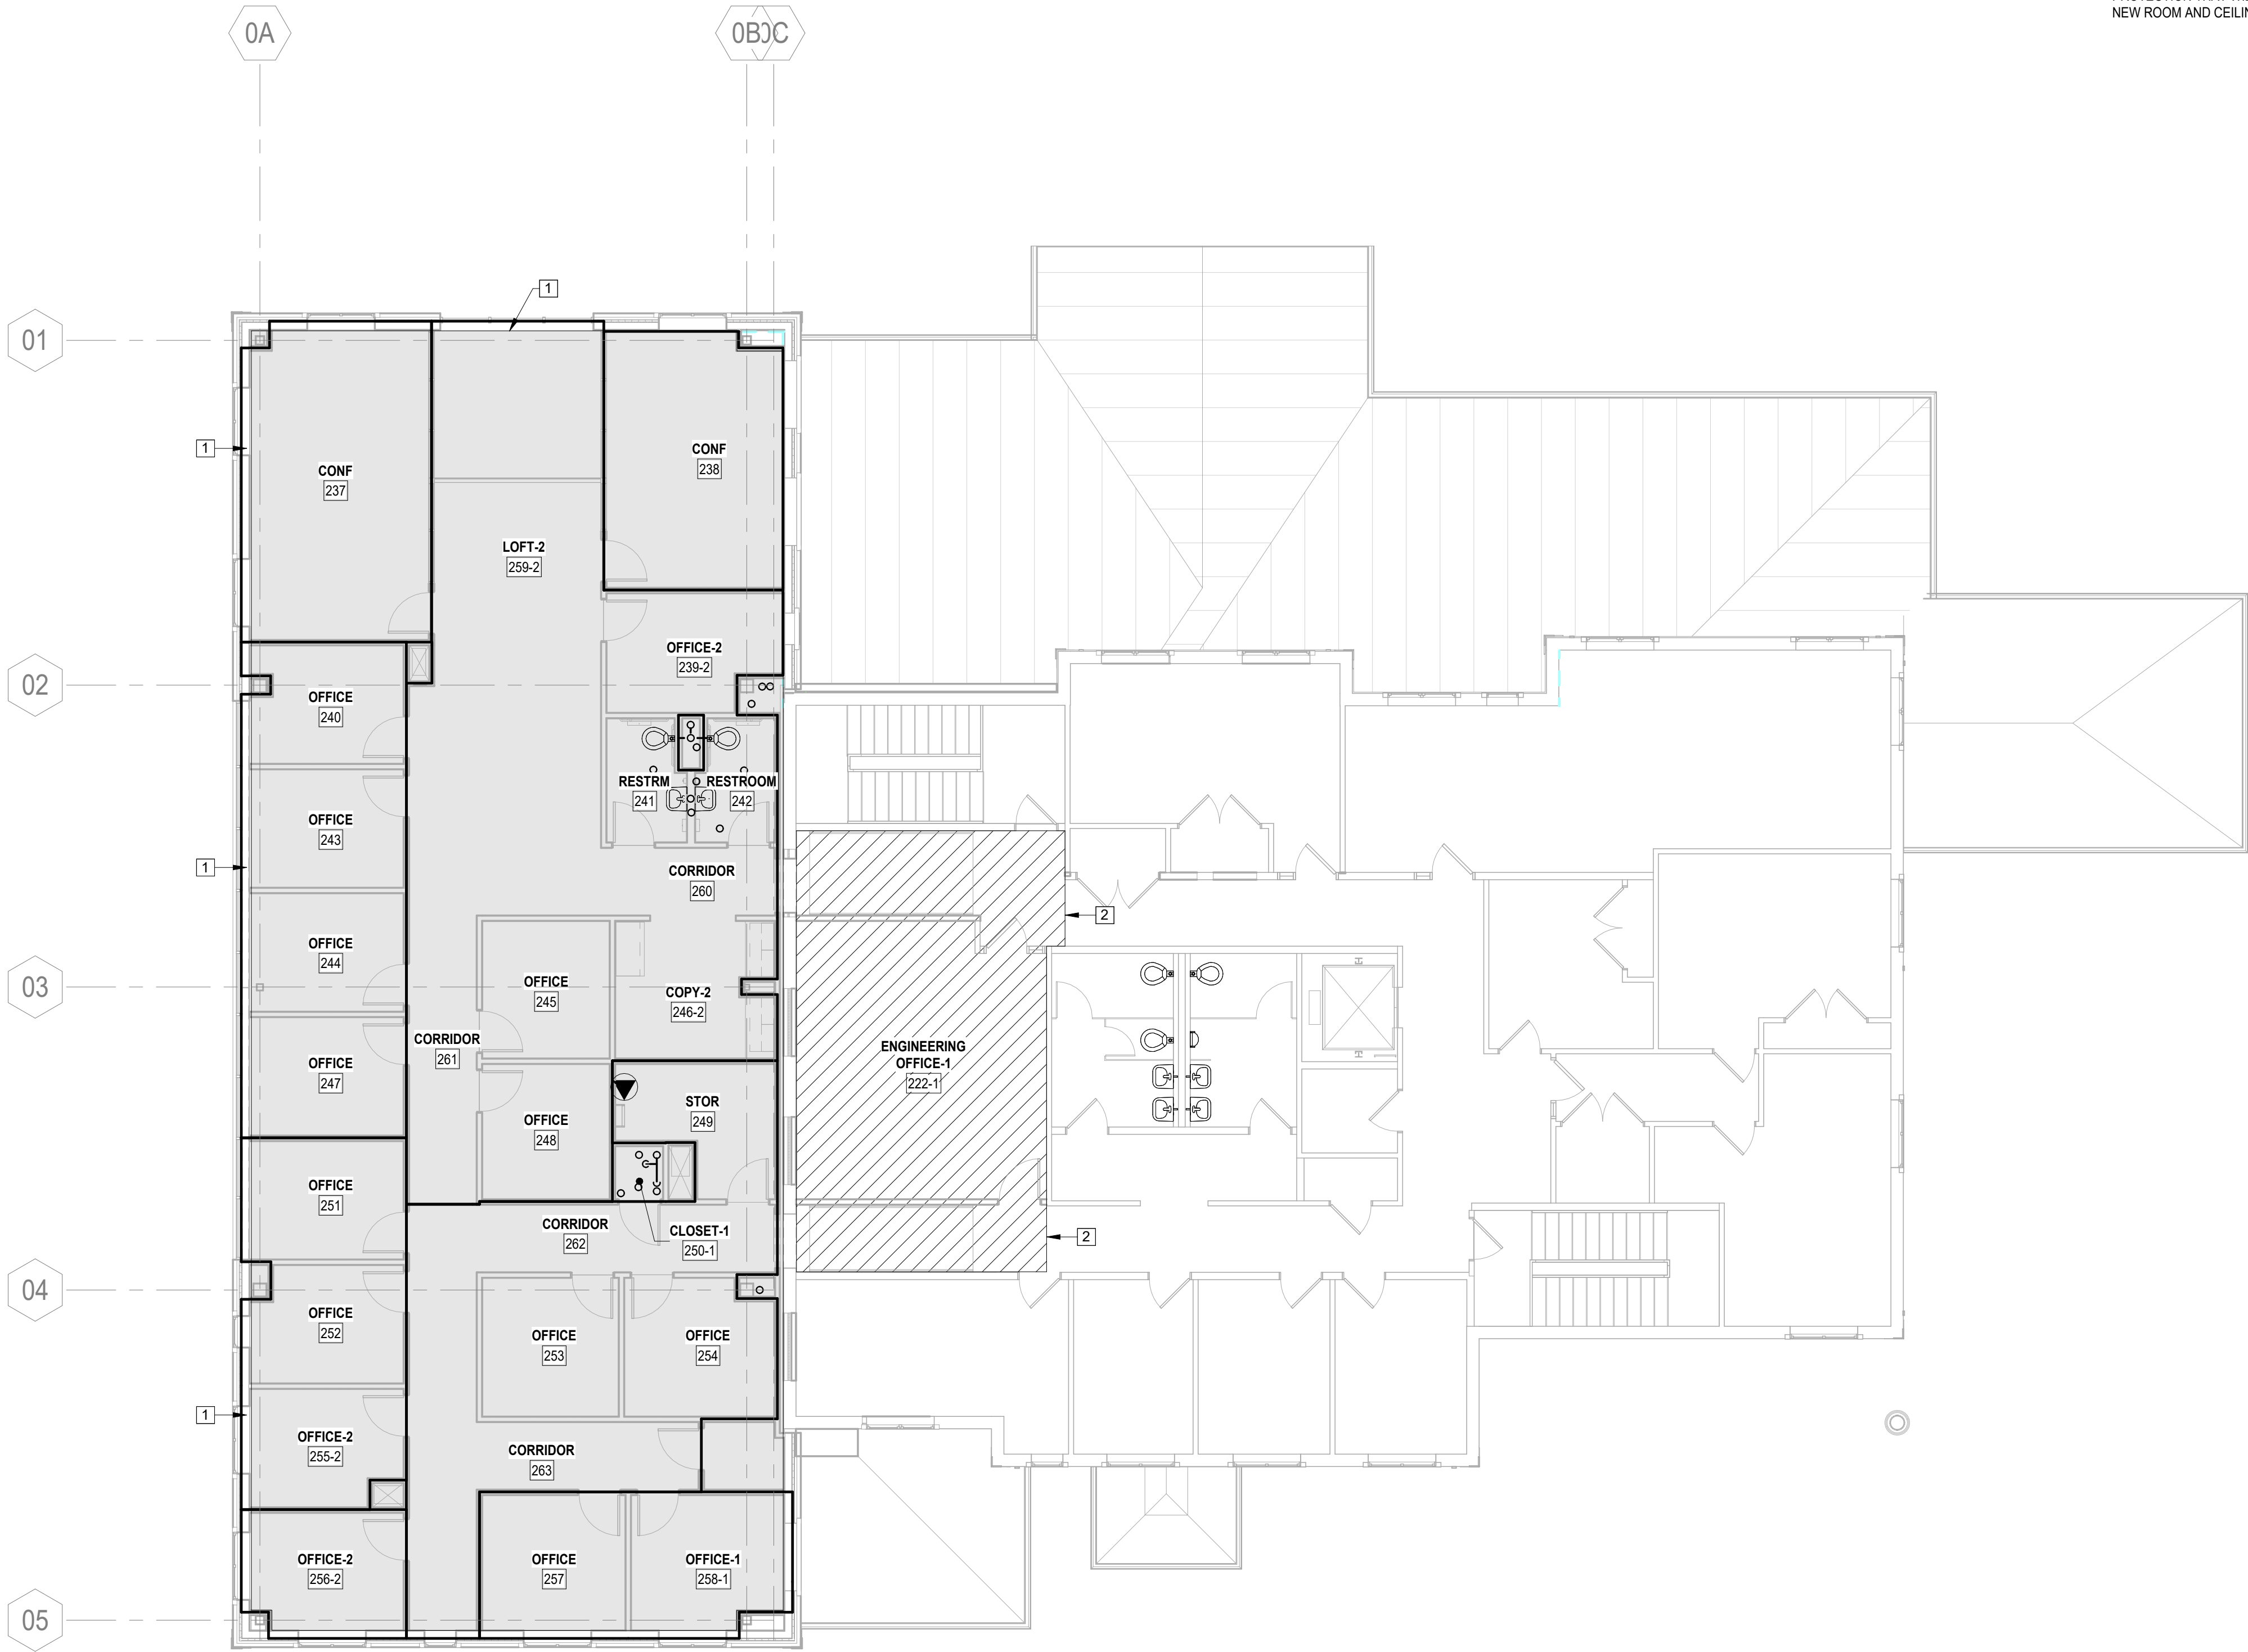

1 SECOND FLOOR FIRE PROTECTION PLAN
SCALE: 1/8" = 1'-0"

GENERAL NOTES:

- A. CONTRACTOR SHALL FIELD VERIFY AND CONFIRM EXISTING PIPING SIZES AND LOCATIONS. NOTIFY ENGINEER OF SIGNIFICANT DISCREPANCIES PRIOR TO COMMENCEMENT OF WORK.
- B. FIRE PROTECTION WORK IS TO BE A DELEGATED DESIGN. CONTRACTOR SHALL BE RESPONSIBLE FOR DESIGN AND INSTALLATION OF A COMPLETE AND OPERABLE NFPA 13 COMPLIANT SPRINKLER SYSTEM WITHIN THE AREA OF WORK SHOWN. REFER TO SPECIFICATIONS FOR FURTHER INFORMATION.

CONSTRUCTION NOTES:

1. SHADED AREA OF WORK INDICATES THE AREA OF NEW CONSTRUCTION. THIS AREA SHALL BE PROVIDED WITH A NEW NFPA 13 SPRINKLER SYSTEM THROUGHOUT. EXTEND FIRE PROTECTION PIPING FROM THE EXISTING MAIN IN THE FIRST FLOOR MECHANICAL ROOM.
2. HATCHED AREA OF WORK INDICATES THE AREA THAT HAS CURRENT SPRINKLER PROTECTION THAT WILL NEED TO BE REWORKED TO PROVIDE PROPER COVERAGE FOR NEW ROOM AND CEILING LAYOUT.



BROWN AND CALDWELL
900 HAMMOND DRIVE, SUITE 500
ATLANTA, GA 30328



7/1/26

CONSTRUCTION
DOCUMENTS
7/01/2026



NCWSA OFFICE
ADDITION

REVISIONS

REV	DATE	DESCRIPTION

LINE IS 2 INCHES
AT FULL SIZE

DESIGNED: NBN

DRAWN: NBN

CHECKED: RFJ

CHECKED:

APPROVED: RFJ

FILENAME

BC PROJECT NUMBER

616202

CLIENT PROJECT NUMBER

SECOND FLOOR
PLAN

DRAWING NUMBER

FP102