


Plot Date: 6/26/2026 8:48:04 AM Path: Autodeskt Docs\NCWSA Admin Bldg_V25\616202-NCWSA-PLBG_V25.rvt

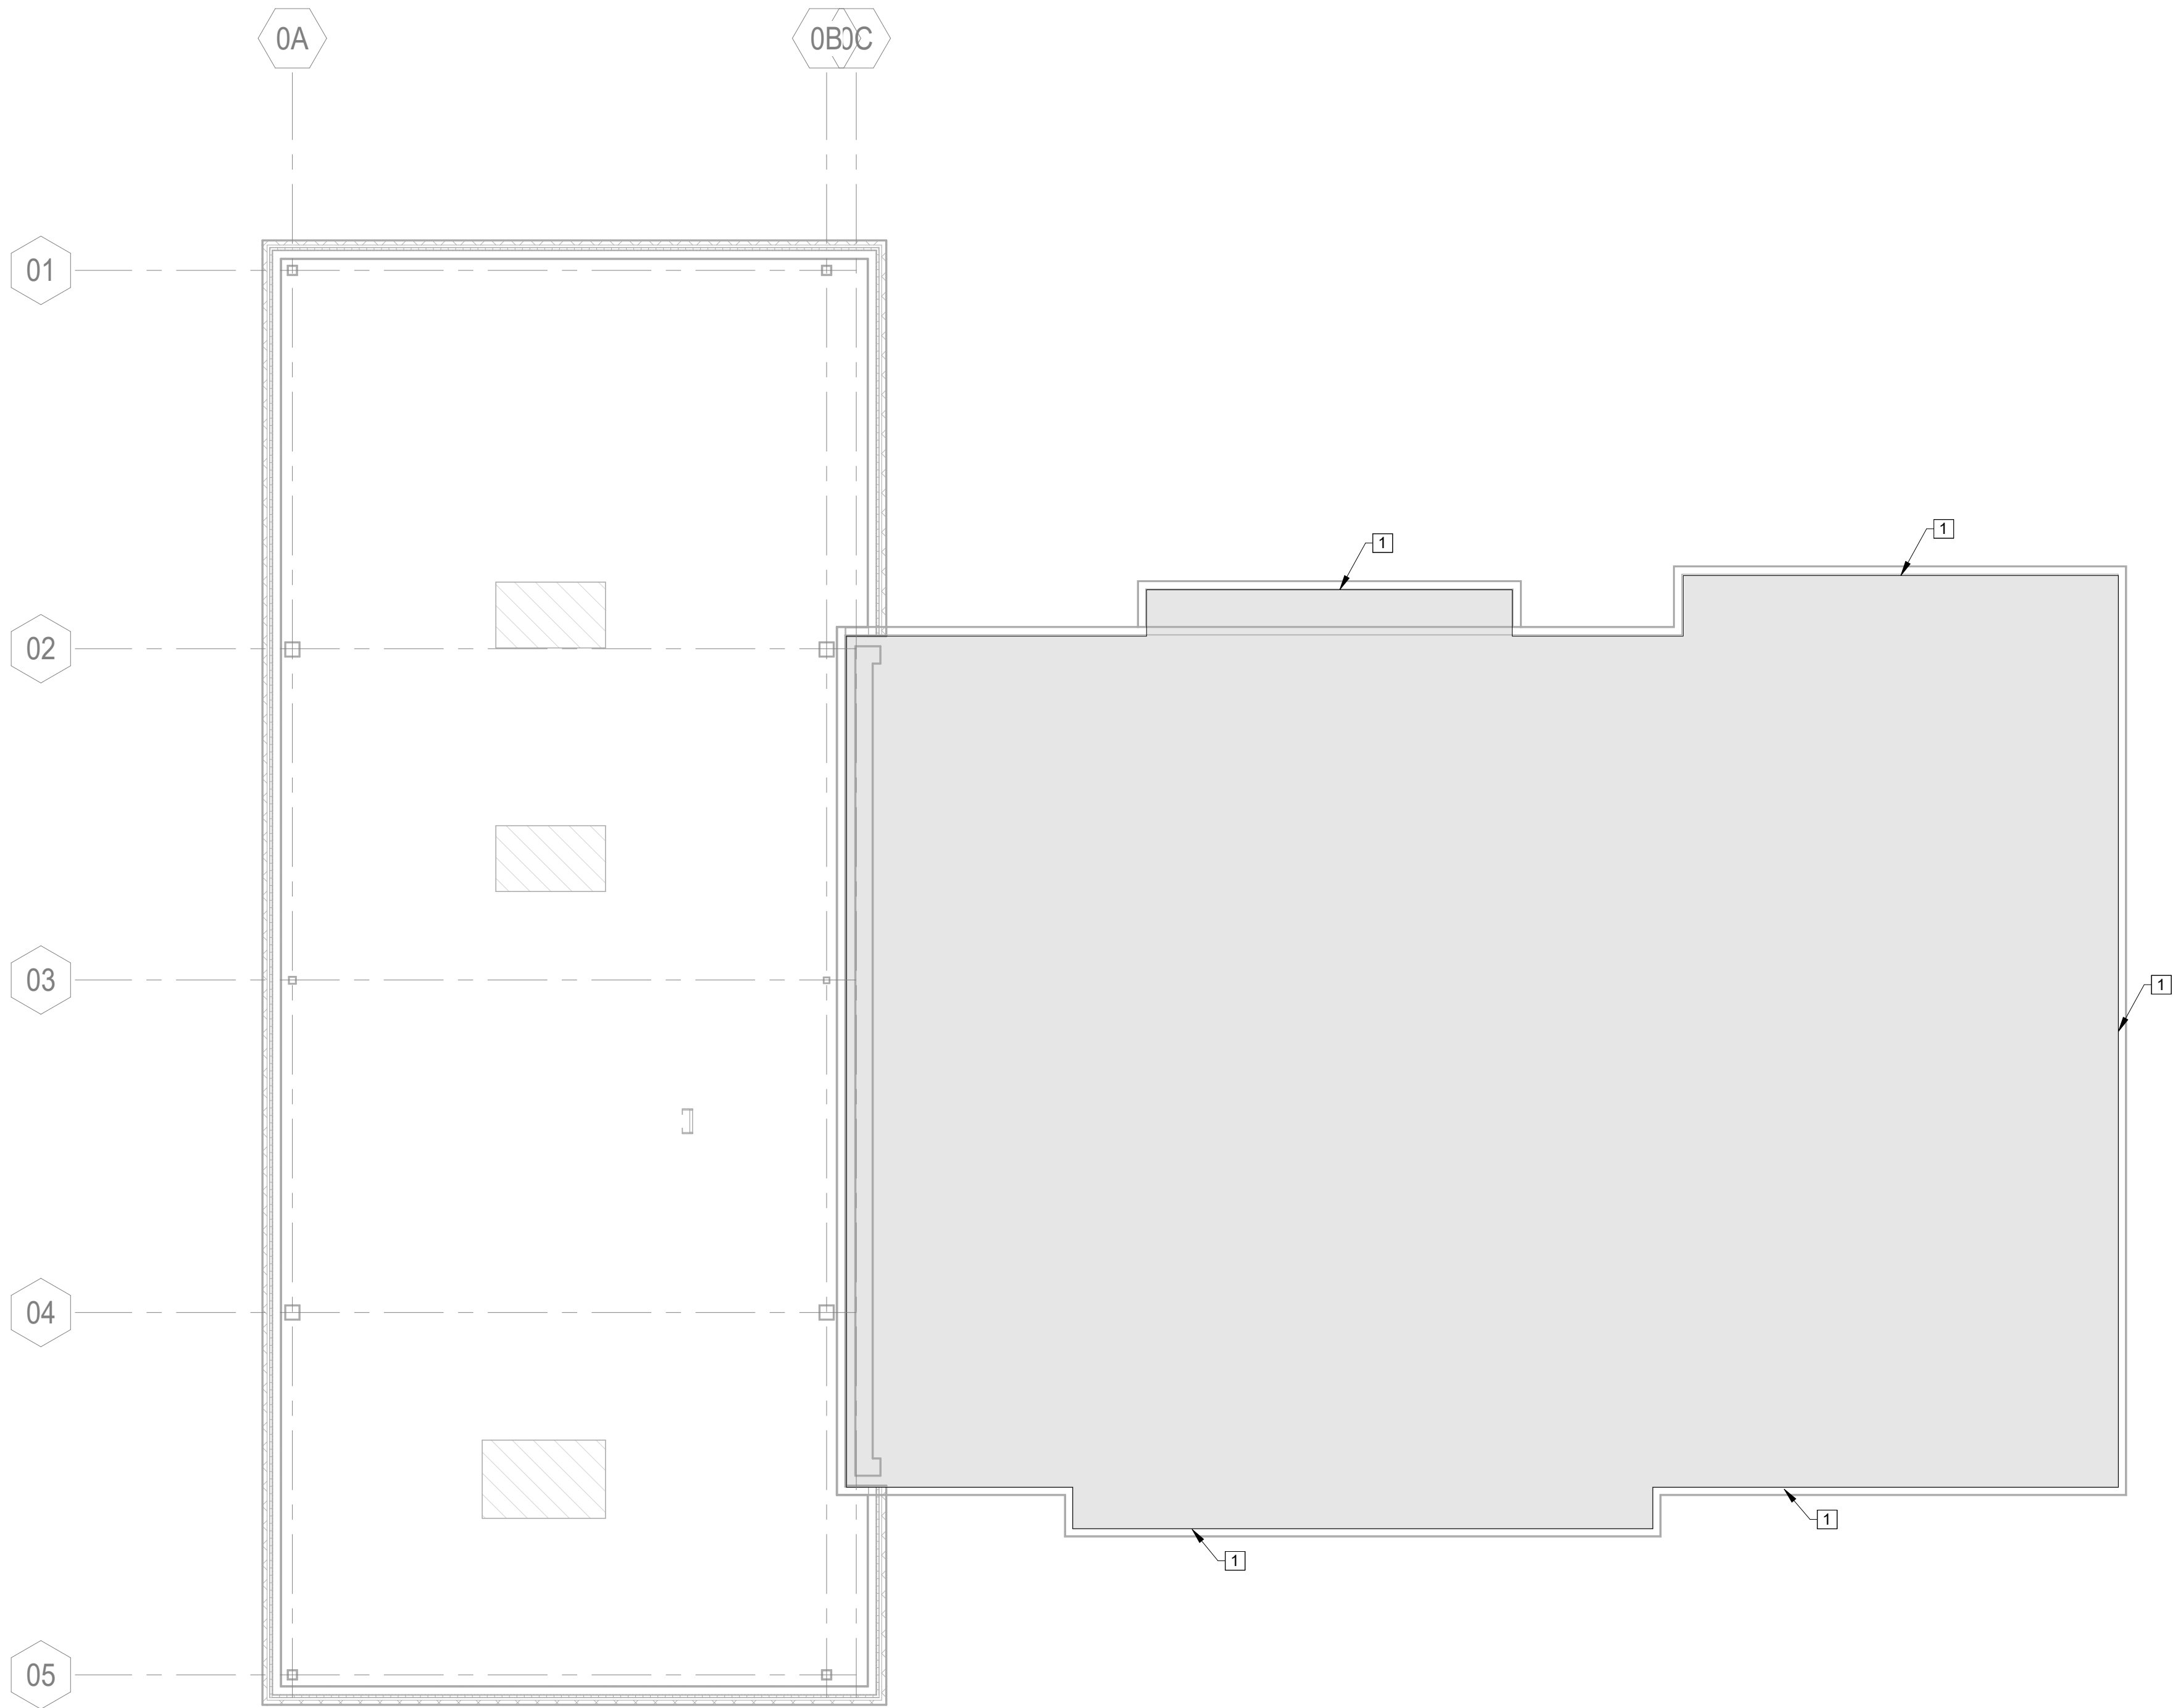


1 ATTIC FIRE PROTECTION PLAN
SCALE: 1/8" = 1'-0"

GENERAL NOTES:

- A. CONTRACTOR SHALL FIELD VERIFY AND CONFIRM EXISTING PIPING SIZES AND LOCATIONS. NOTIFY ENGINEER OF SIGNIFICANT DISCREPANCIES PRIOR TO COMMENCEMENT OF WORK.
- B. FIRE PROTECTION WORK IS TO BE A DELEGATED DESIGN. CONTRACTOR SHALL BE RESPONSIBLE FOR DESIGN AND INSTALLATION OF A COMPLETE AND OPERABLE NFPA 13 COMPLIANT SPRINKLER SYSTEM WITHIN THE AREA OF WORK SHOWN. REFER TO SPECIFICATIONS FOR FURTHER INFORMATION.
- C. COORDINATE ACTUAL ROUTE OF PIPING IN ATTIC WITH FRAMING MEMBERS.
- D. DRY SYSTEM AUXILIARY DRAINS SHALL BE PROVIDED AT ALL LOW POINTS OF THE SYSTEM TO CAPTURE CONDENSATION AND ALLOW FOR DRAINING OF TRAPPED SECTIONS OF WATER. NO POINT OF THE DRY SYSTEM SHALL TRAP ANY AMOUNT OF WATER.

CONSTRUCTION NOTES:

- 1. SHADED AREA OF WORK INDICATES THE ATTIC SPACE IN THE EXISTING BUILDING THAT IS TO BE PROVIDED WITH A DRY PIPE SPRINKLER SYSTEM. NEW LAYOUT IS TO PROVIDE COMPLETE PROTECTION OF THE EXISTING COMBUSTIBLE ATTIC SPACE. EXISTING DRY PIPE SPRINKLER SYSTEM SERVING THE SECOND FLOOR IS TO BE EXTENDED TO COVER ATTIC.

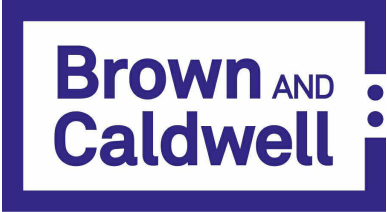

BROWN AND CALDWELL
900 HAMMOND DRIVE, SUITE 500
ATLANTA, GA 30328



CONSTRUCTION DOCUMENTS
7/01/2026



NCWSA OFFICE ADDITION

REVISIONS		
REV	DATE	DESCRIPTION

LINE IS 2 INCHES
AT FULL SIZE

DESIGNED: NBN

DRAWN: NBN

CHECKED: RFJ

CHECKED:

APPROVED: RFJ

FILENAME

BC PROJECT NUMBER

616202

CLIENT PROJECT NUMBER

ATTIC PLAN

DRAWING NUMBER

FP103