


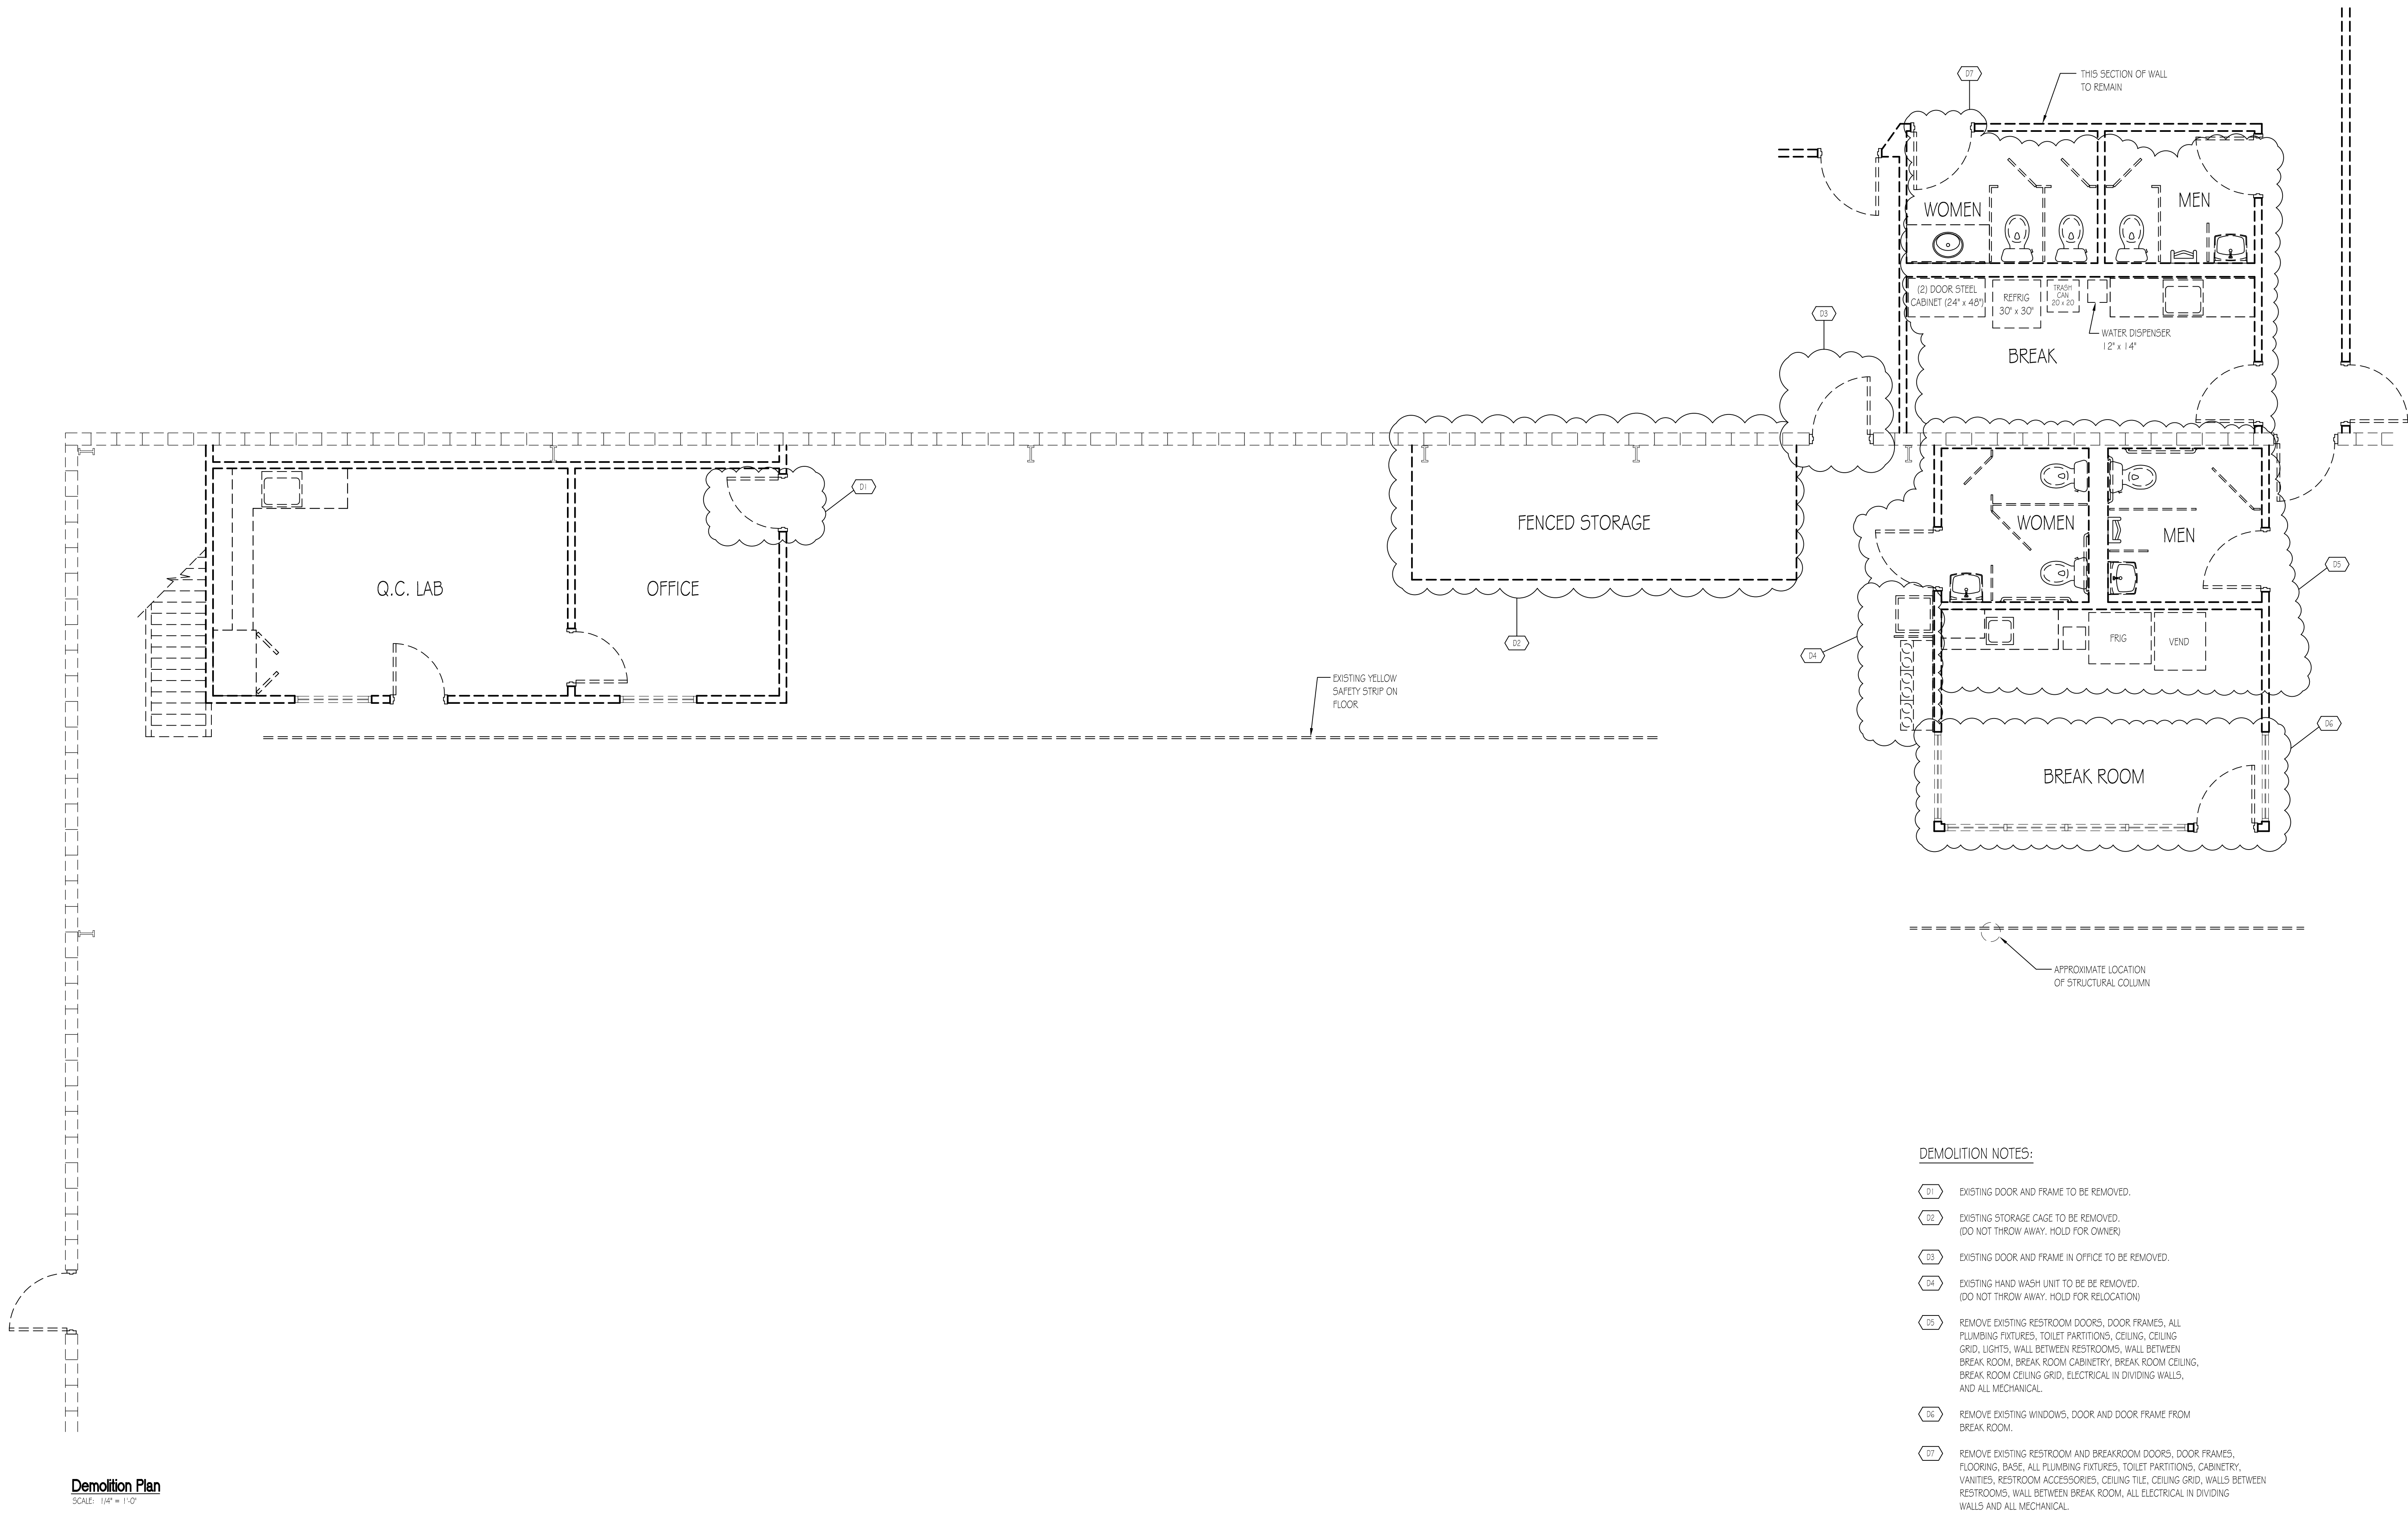

Demolition Plan
SCALE: 1/8" = 1'-0"

DEMOLITION NOTES:

21. EXISTING DOOR AND FRAME TO BE REMOVED.
22. EXISTING STORAGE CAGE TO BE REMOVED.
(DO NOT THROW AWAY. HOLD FOR OWNER)
23. EXISTING DOOR AND FRAME IN OFFICE TO BE REMOVED.
24. EXISTING HAND WASH UNIT TO BE REMOVED.
(DO NOT THROW AWAY. HOLD FOR RELOCATION)
25. REMOVE EXISTING RESTROOM DOORS, DOOR FRAMES, ALL PLUMBING FIXTURES, TOILET PARTITIONS, CEILING, CEILING GRID, LIGHTS, WALL BETWEEN RESTROOMS, WALL BETWEEN BREAK ROOM, BREAK ROOM CABINETRY, BREAK ROOM CEILING, BREAK ROOM CEILING GRID, ELECTRICAL IN DIVIDING WALLS, AND ALL MECHANICAL.
26. REMOVE EXISTING WINDOWS, DOOR AND DOOR FRAME FROM BREAK ROOM.
27. REMOVE EXISTING RESTROOM AND BREAKROOM DOORS, DOOR FRAMES, FLOORING, BASE, ALL PLUMBING FIXTURES, TOILET PARTITIONS, CABINETRY, VANITIES, RESTROOM ACCESSORIES, CEILING TILE, CEILING GRID, WALLS BETWEEN RESTROOMS, WALL BETWEEN BREAK ROOM, ALL ELECTRICAL IN DIVIDING WALLS AND ALL MECHANICAL.

5	06-22-2026 Customer Revisions
6	08-19-2026 Customer Revisions

A New Building Renovation Project For
Precision Concepts

9619 Jackson Trail Rd.
Roselton, Georgia

Architect or Engineer Seal

1	11-03-2023 Customer Review
2	11-10-2023 Customer Revisions
3	12-15-2023 Customer Revisions
4	07-25-2024 Customer Revisions

Project No.
• 00-00
Cad File Name
• 00-00_PC_03_A20
Drawing Scale
• 1/4" = 1'-0"
Sheet Title
• Demolition Plan

Drawn
• dcm
Checked
• mbm

Sunbelt Builders, Inc. ©
DRAWINGS AND SPECIFICATIONS ARE INSTRUMENTS OF SERVICE AND SHALL REMAIN THE PROPERTY OF THIS CORPORATION WHETHER THE PROJECT FOR WHICH THEY ARE MADE IS EXECUTED OR NOT. THEY ARE NOT TO BE USED ON OTHER PROJECTS OR EXTENSIONS TO THIS PROJECT EXCEPT BY AGREEMENT IN WRITING AND APPROPRIATE COMPENSATION TO THIS CORPORATION.