


revisions

- LEGEND NOTES:** (THIS SHEET ONLY)
- ◇ ALL RECEPTABLES BELOW 42" AFF IN THIS ROOM SHALL BE TAMPER RESISTANT (CHILD PROOF) TYPE.
 - ◇ WHITE (NOT IVORY) FLUSH DUPLEX RECEPTACLE IN CEILING OR 6" ABOVE GLASS FOR DISPLAY SIGNS. REFER TO NEC 210-62.
 - ◇ DUPLEX GFCI RECEPTACLE IN A FLUSH FLOOR BOX (FOR VACUUMING) WITH BRASS COVERPLATE, EQUAL TO WALKER 9882C81-1 WITH 9882GFI COVERPLATE.
 - ◇ TWO-GANG FLUSH BOX EQUAL TO WALKER MFI WITH QUAD RECEPTABLES AND CONDUIT FOR MICROPHONE CABLE. PROVIDE NO BLACK CARPET COVERTRIM.

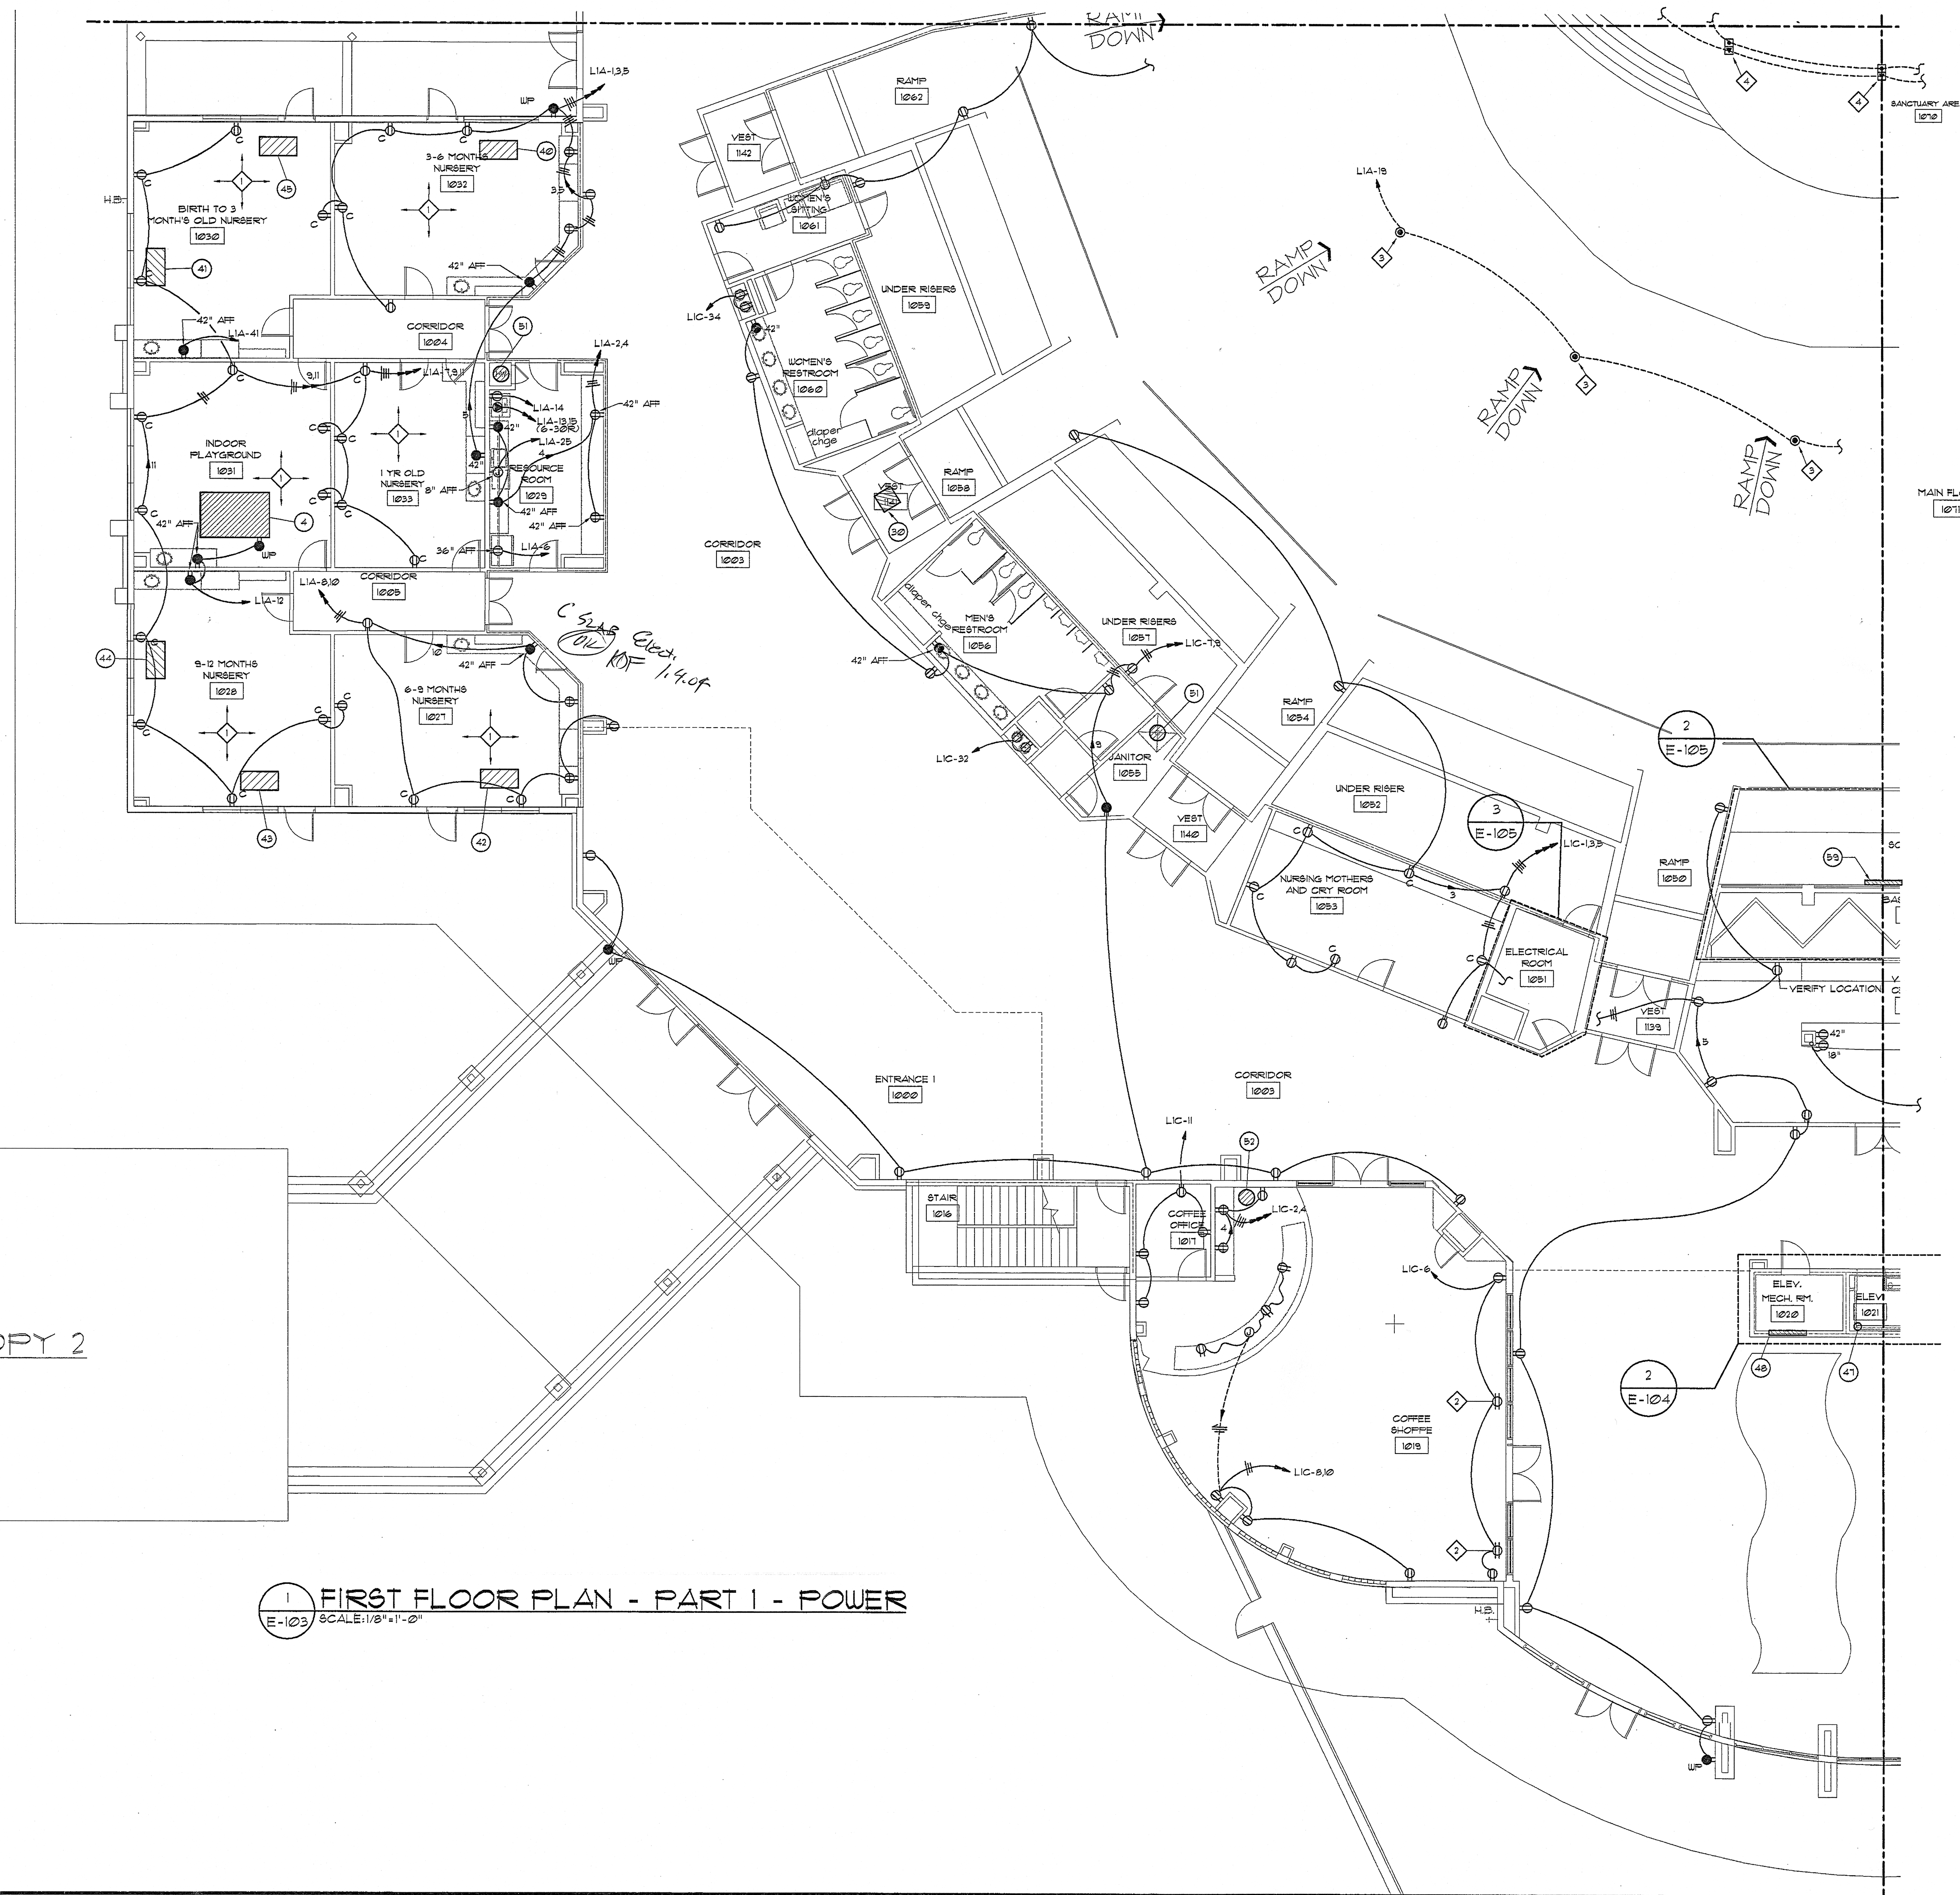

1 FIRST FLOOR PLAN - PART 1 - POWER
E-103 SCALE: 1/8"=1'-0"

for construction

This drawing, as an instrument of service, is and shall remain the property of the Architects and Engineers and shall not be reproduced, published or used in any way without the written permission of the Architect or Engineer.

Copyright ©1998 By John Ware & Associates, Inc.

seal



John Ware & Associates, Inc.
Architects & Engineers

1954 Airport Road
Suite 100
Atlanta, GA 30341
(770) 451-1921
FAX (770) 457-1920

project
**CHURCH
IN THE NOW**

address
1813 4 1933
IRIS DRIVE
CONYERS, GA
for
**COVENANT
SERVICES, INC.**
1111 WESLEY WAY
CONYERS, GA

sheet description
**FIRST FLOOR
PLAN-PART 1-
POWER**

drawn VJ
checked TUM

job 00-145

date 12/20/01

E-103
of

ROBERDS
CONSULTING
ENGINEERS
455 EAST PACES FERRY ROAD, N.E.
SUITE 300
ATLANTA, GEORGIA 30305
TELEPHONE (404) 237-8832
FACSIMILE (404) 237-8161
2001439 TWM