


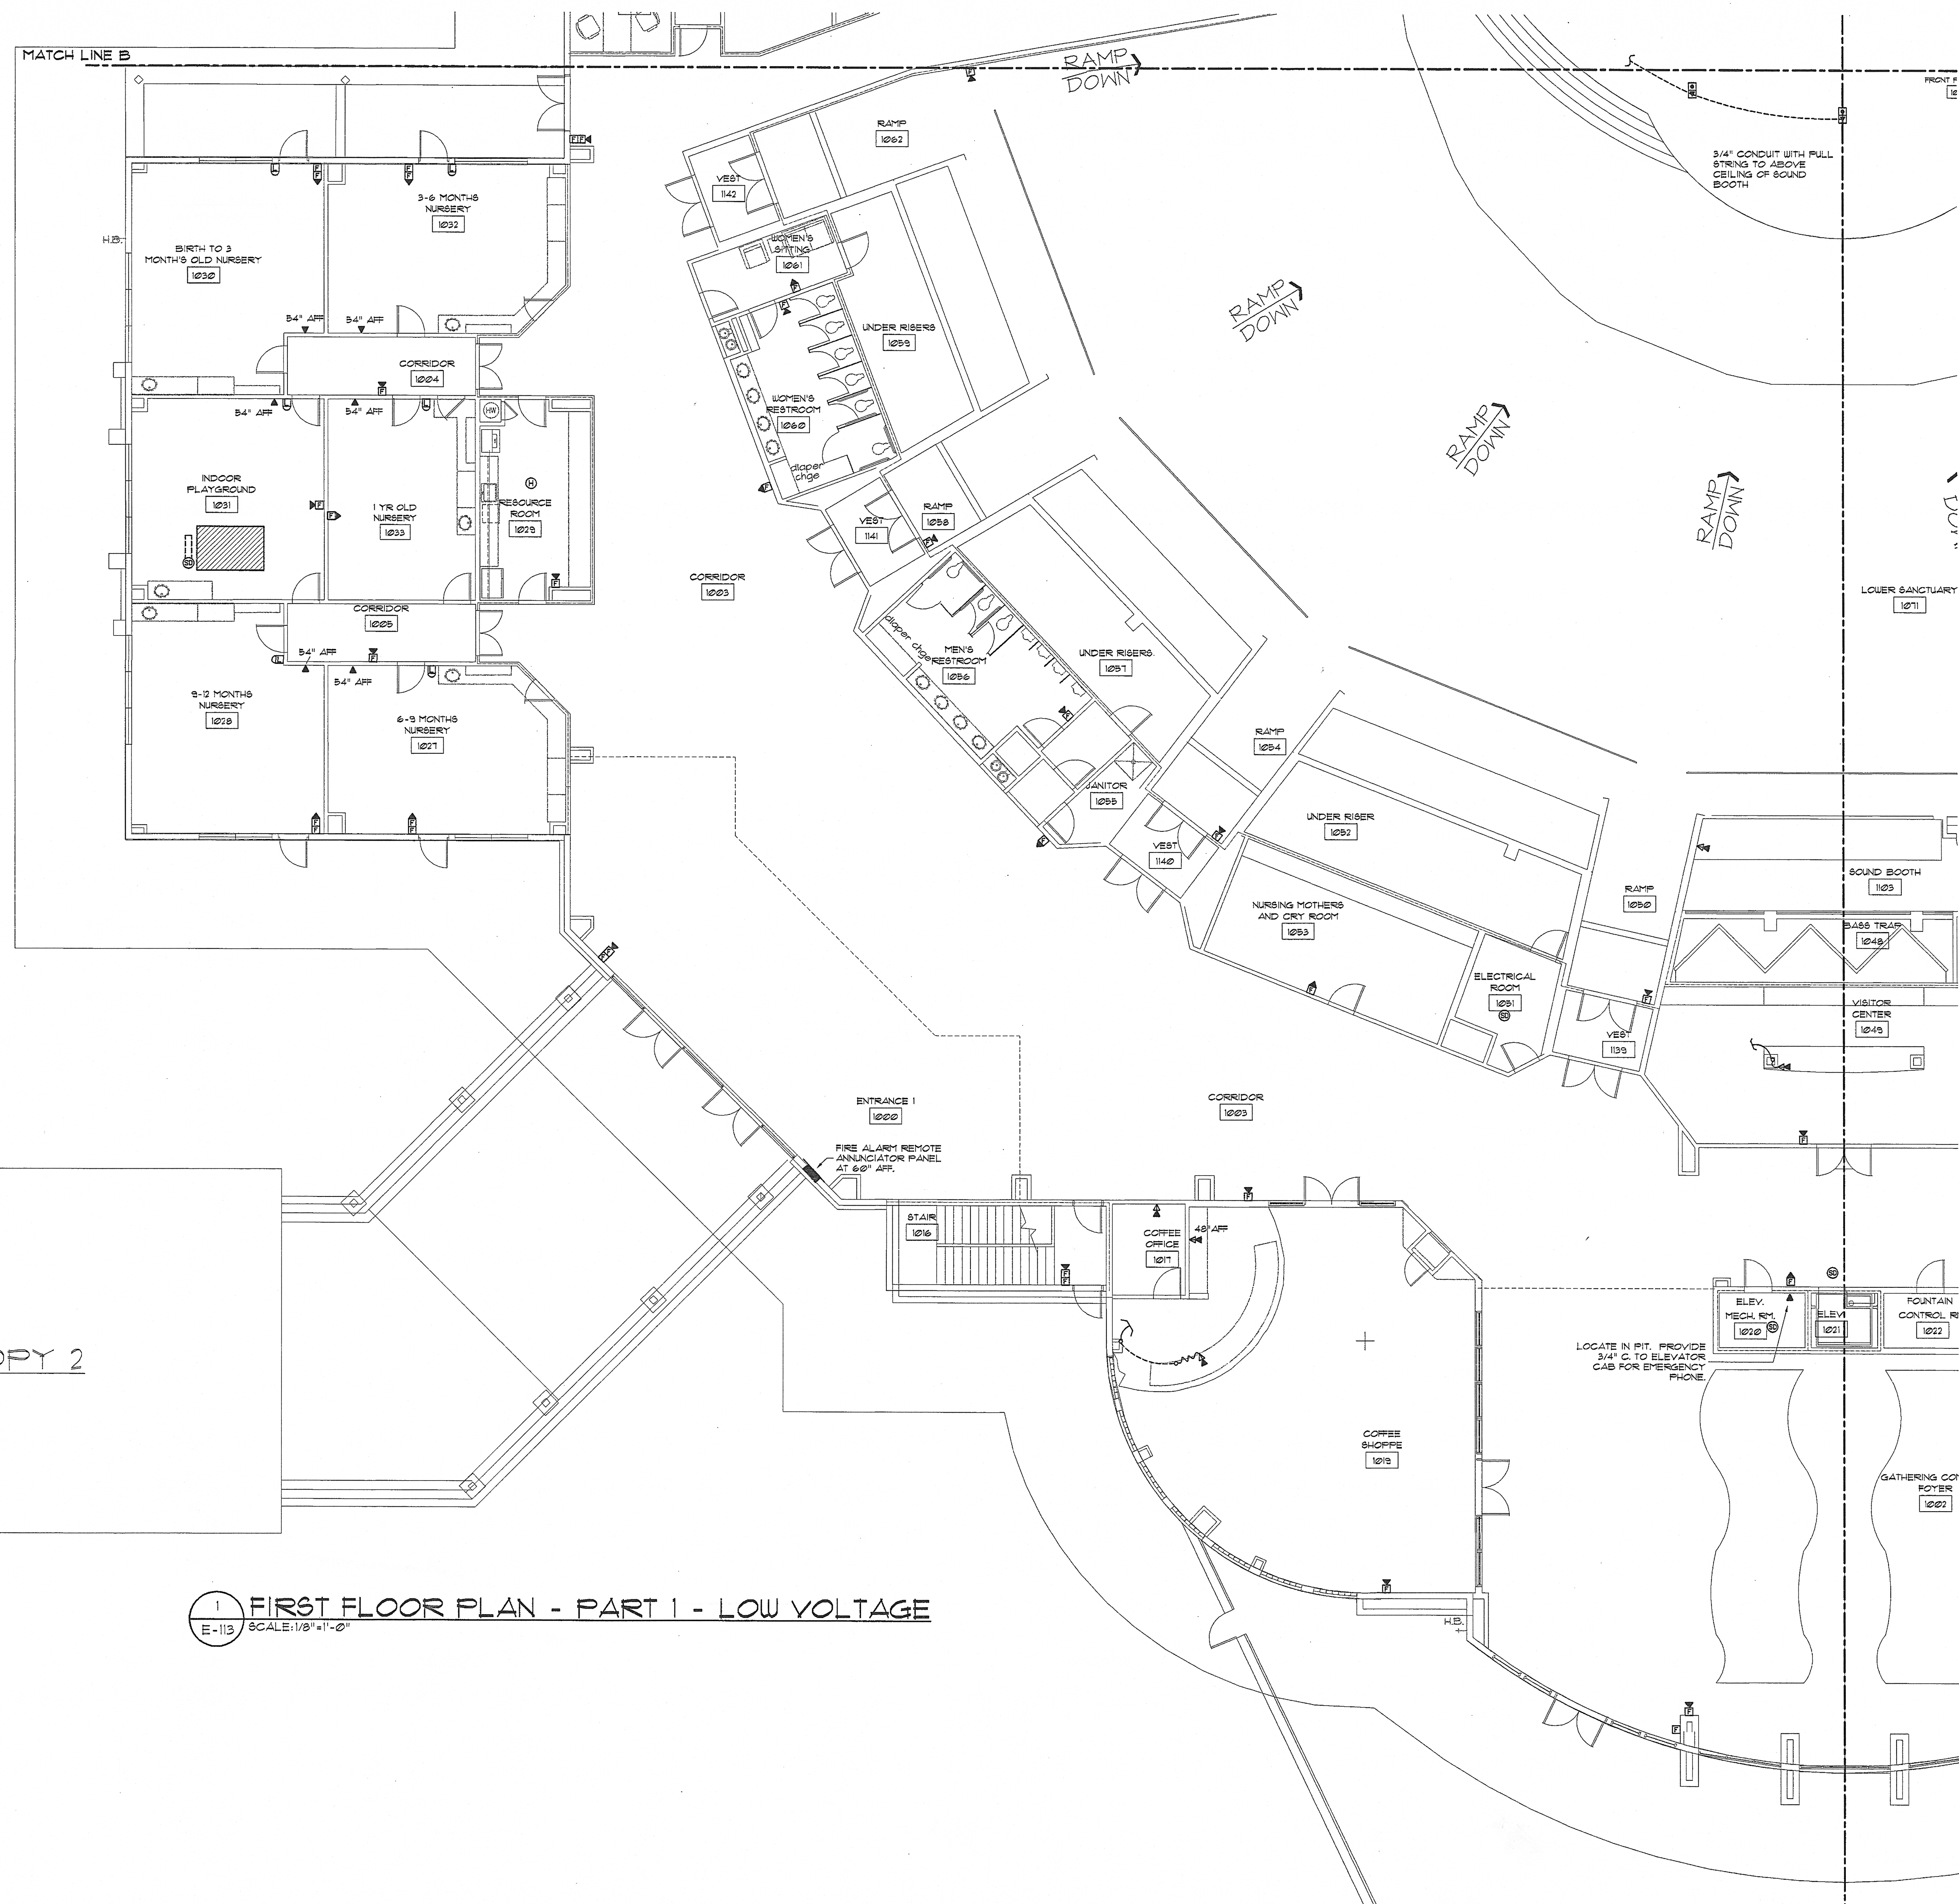

1 FIRST FLOOR PLAN - PART 1 - LOW VOLTAGE
E-113 SCALE: 1/8" = 1'-0"


revisions

for construction

This drawing, as an instrument of service, is and shall remain the property of the Architect and Engineers and shall not be reproduced, published or used in any way without the written permission of the Architect or Engineer.

Copyright © 1998 By John Ware & Associates, Inc.

seal

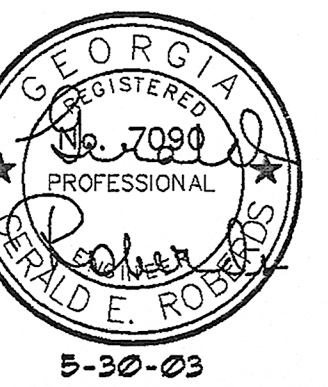

John Ware & Associates, Inc.
Architects & Engineers

1954 Airport Road
Suite 100
Atlanta, GA 30341
(770) 451-1921
FAX (770) 457-1920

project
**CHURCH
IN THE NOW**

address
1813 & 1933
IRIS DRIVE
CONTERS, GA
for
**COVENANT
SERVICES, INC.**
1711 WESLEY WAY
CONTERS, GA

sheet description
**FIRST FLOOR
PLAN-PART 1-
LOW VOLTAGE**

drawn VJ
checked TUM

job 00-145

date 12/20/01

E-113
of

**ROBERDS
CONSULTING
ENGINEERS**

455 EAST PACES FERRY ROAD, N.E.
SUITE 300
ATLANTA, GEORGIA 30305
TELEPHONE (404) 237-8832
FACSIMILE (404) 237-4161

2001439 TWM