


revisions

for construction
This drawing, as an instrument of service,
is and shall remain the property of the
Architects and Engineers and shall not be
reproduced, published or used in any way
without the written permission of the Ar-
chitect or Engineer.
Copyright © 2001 By
A.M.C. Consulting Engineers, Inc.

seal

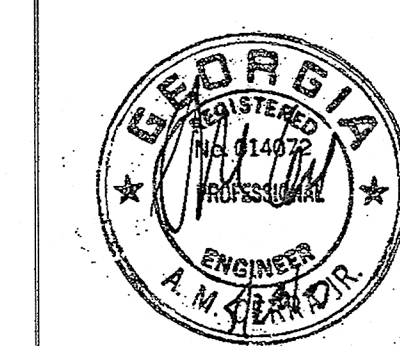

**John Ware
&
Associates,
Inc.**
Architects & Engineers

1954 Airport Road
Suite 100
Atlanta, GA 30341
(770) 451-1921
FAX (770) 457-1920

project
**CHURCH
IN THE NOW**

address
1873 & 1933
IRIS DRIVE
CONYERS, GA
for
**COVENANT
SERVICES INC**
1771 WESLEY WAY
CONYERS, GA


sheet description
PARTIAL 2ND FLOOR PLAN - HVAC

drawn
checked AMC

job 01-145


date 08/15/02

M-104
of 6

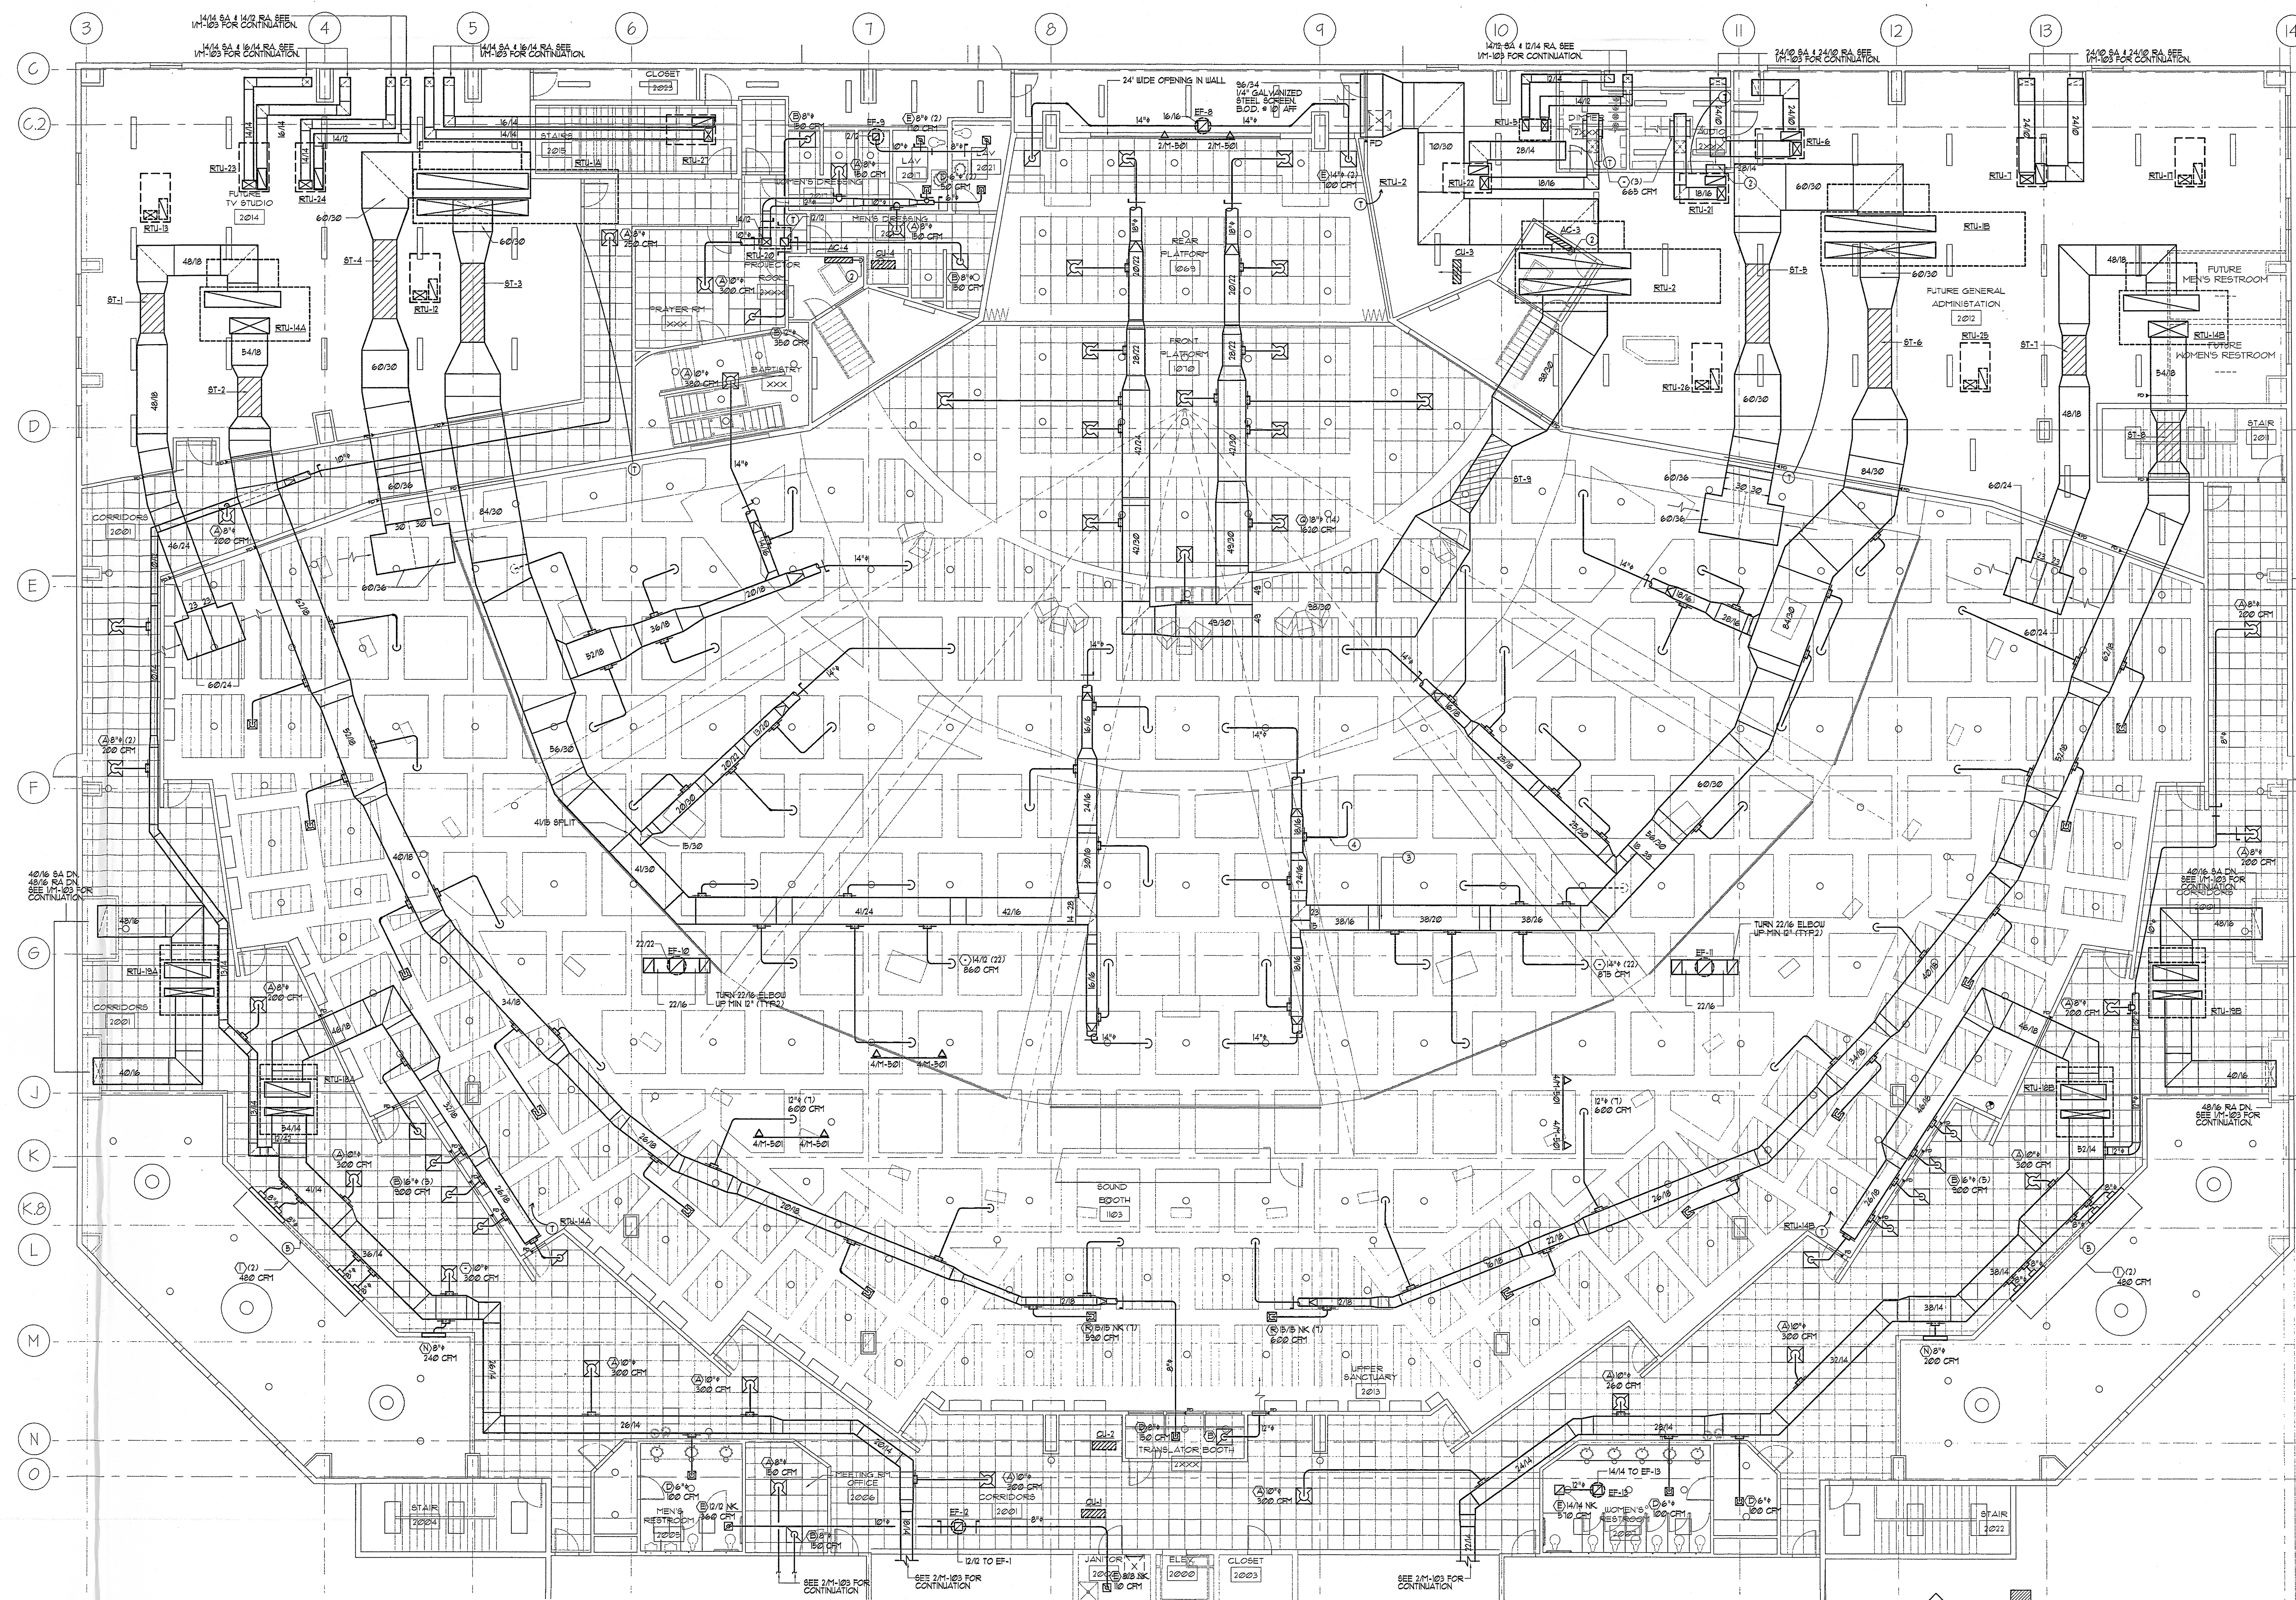

PLAN NORTH
1
PARTIAL 2nd FLOOR PLAN - HVAC
SCALE: 1/8" = 1'-0"

- KEYED NOTES:
- COVER DUCT OPENING W/ 1/4" GALVANIZED WIRE MESH SCREEN
 - 3/4" CONDENSATE DN. SEE M-103 FOR CONTINUATION
 - ALL RECTANGULAR SUPPLY & RETURN DUCT SERVING SANCTUARY, FRONT PLATFORM & RECORDING STUDIO LINED WITH 1" THICK TELCOF. SEE SECTION B320 IN SPECIFICATIONS FOR ADDITIONAL INFORMATION
 - MIN. 1" DUCT DIAMETERS LINED ROUND SPIRAL DUCT BETWEEN SPIN-IN & OUTLET (TYP. SANCTUARY)
 - BLANK SECTION CLOSED TO FLENUM

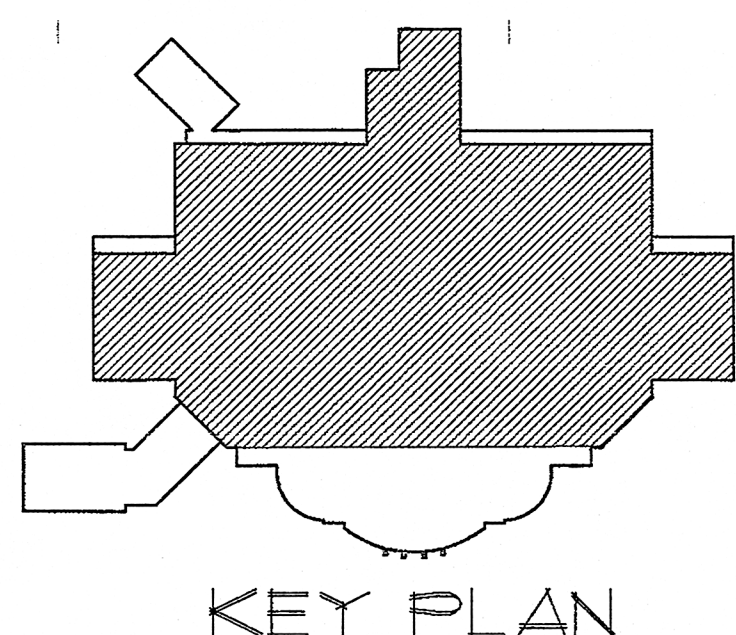

AMC
CONSULTING
ENGINEERS, INC.
1827 POWERS FERRY ROAD
BLDG. 18, SUITE 100
ATLANTA, GEORGIA
30339
PHONE: (770) 980-0591
FAX: (770) 980-0540