


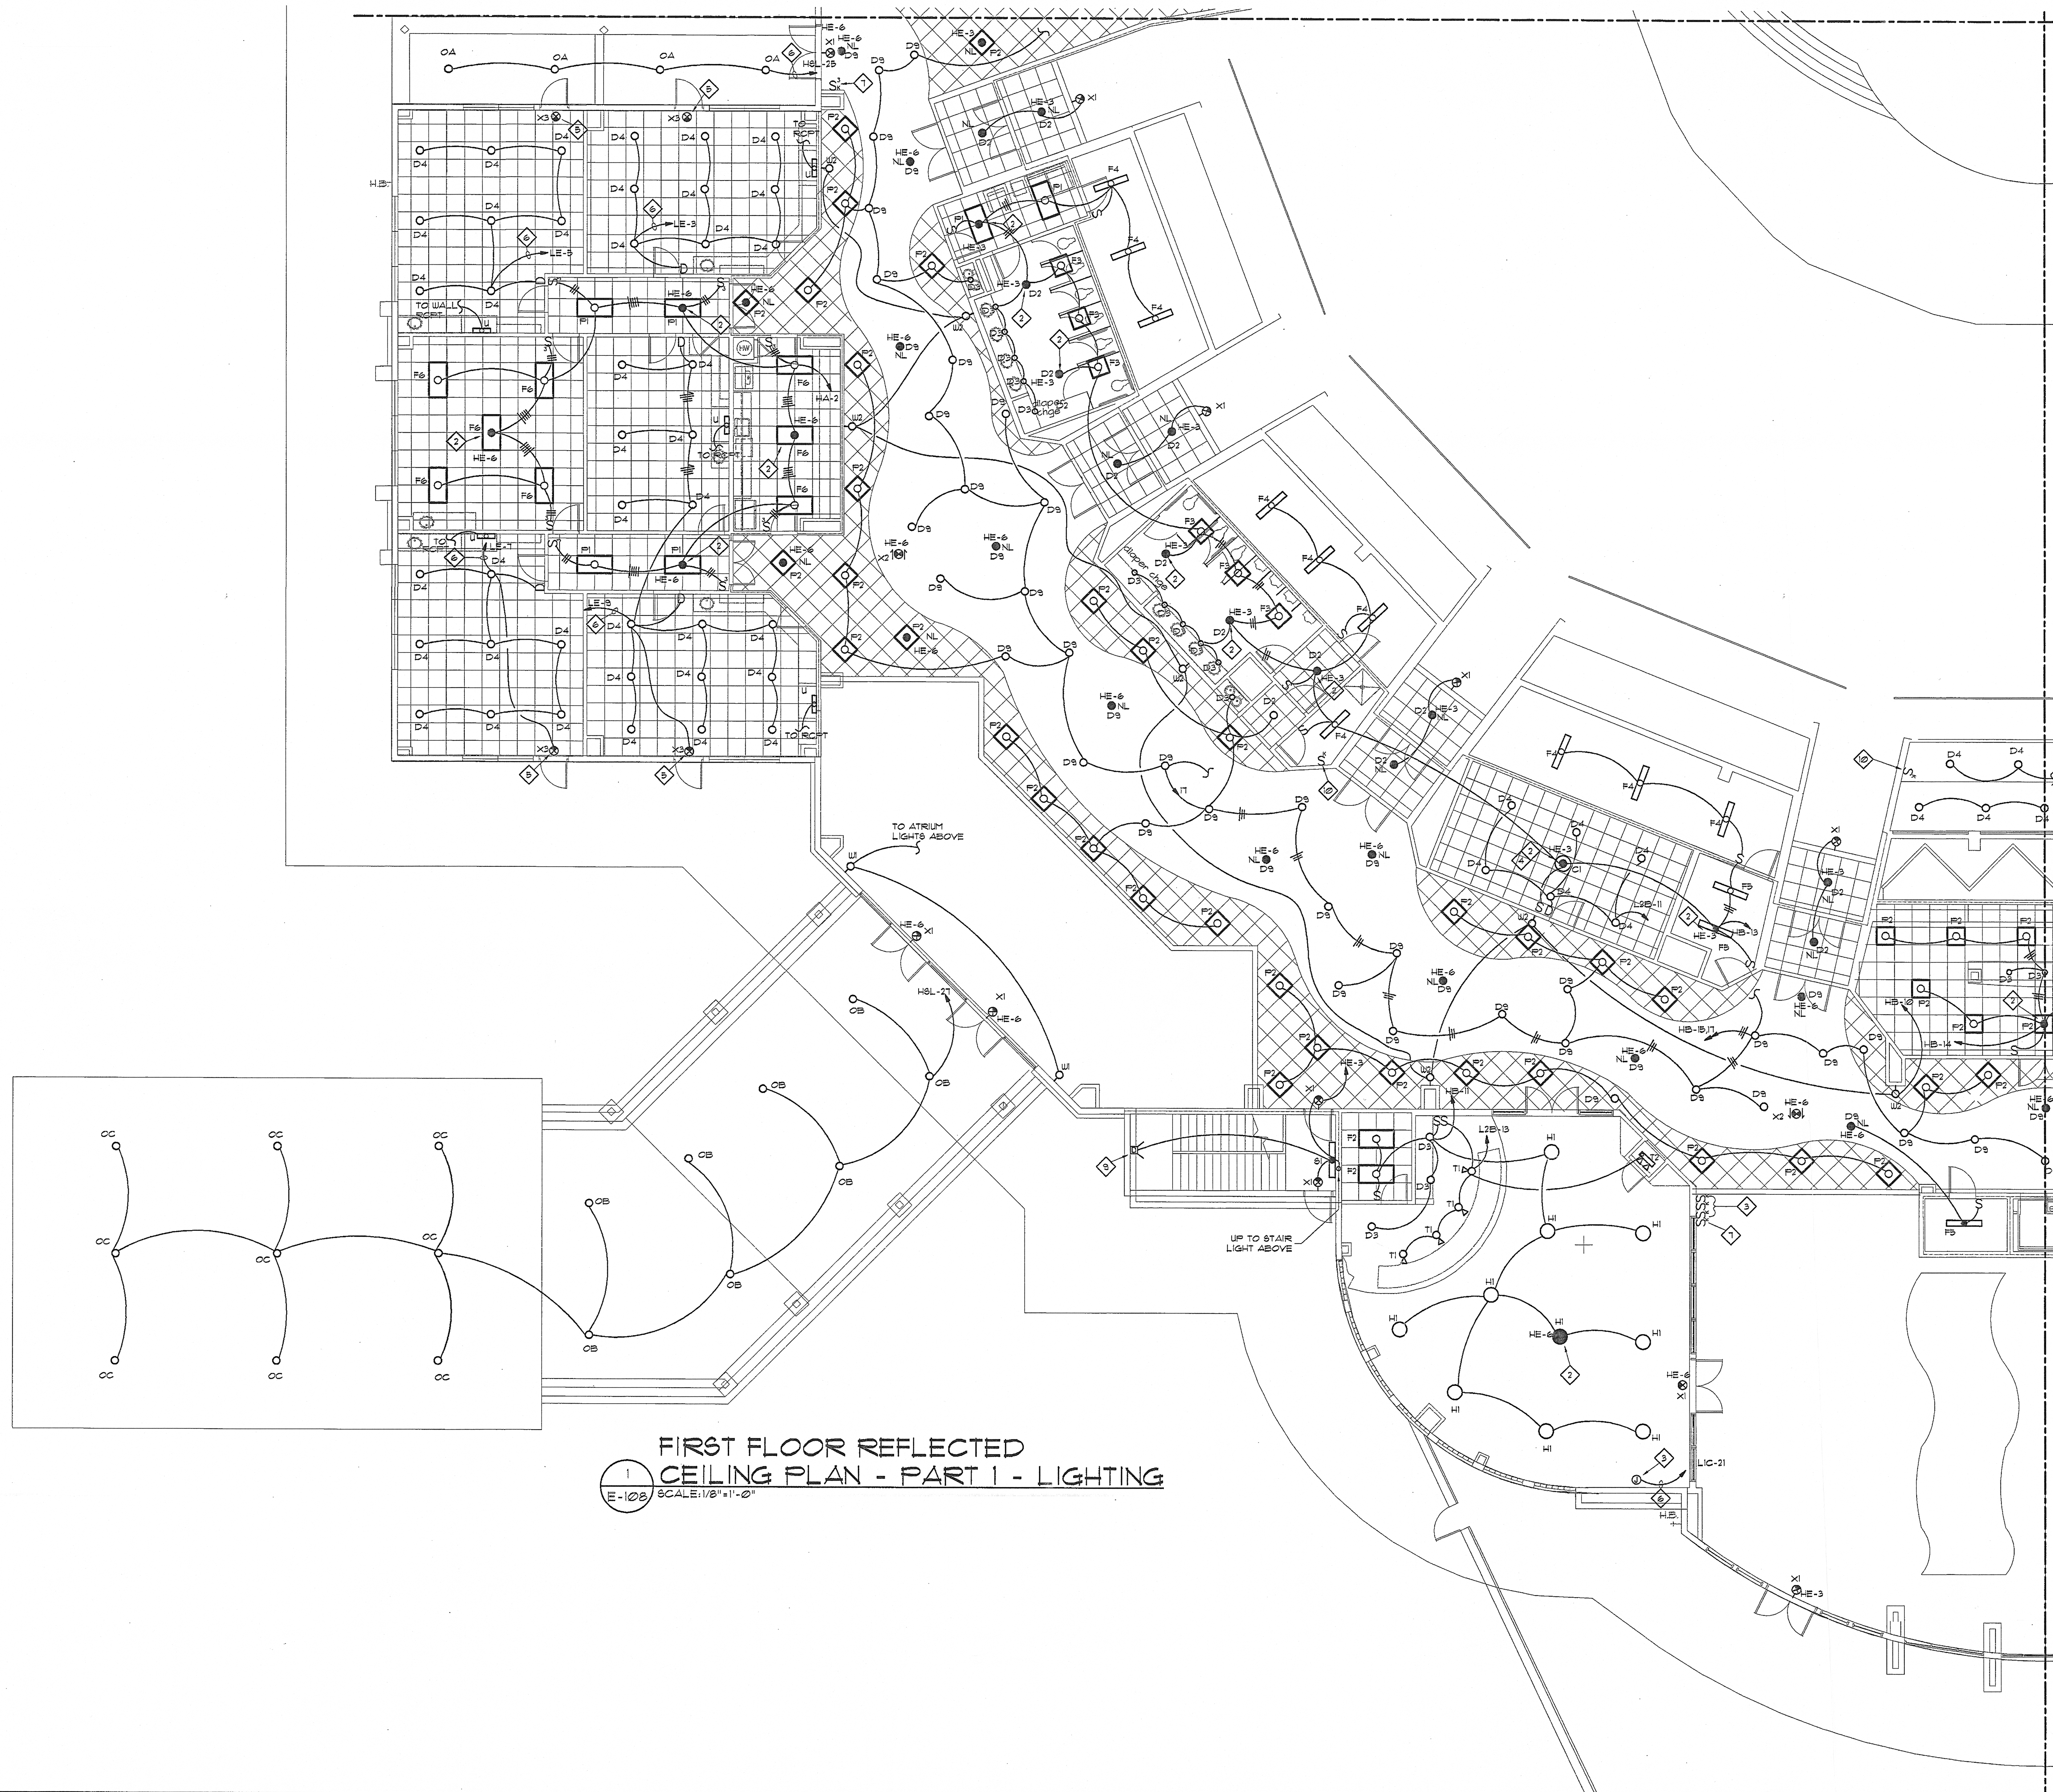

1
E-108
SCALE 1/8" = 1'-0"

FIRST FLOOR REFLECTED
CEILING PLAN - PART I - LIGHTING


- LEGEND NOTES: (THIS SHEET ONLY)
- 1. FLUORESCENT LIGHTS THIS ROOM SHALL HAVE TWO BALLASTS. ONE BALLAST SHALL OPERATE THE CENTER LAMP(S) WHILE THE SECOND BALLAST SHALL OPERATE THE OUTER TWO LAMP(S).
 - 2. THIS FIXTURE SHALL HAVE BODINE 'GTD' GENERATOR TRANSFER DEVICE INSTALLED TO OPERATE ALL LAMPS. PROVIDE SWITCHED POWER FROM LIGHTING CIRCUIT AND POWER FROM GENERATOR PANEL. SEE EMERGENCY CIRCUIT NUMBER ADJACENT TO LIGHT FIXTURE. FIXTURE SHALL NOT OPERATE 24 HOURS.
 - 3. JUNCTION BOX ABOVE CEILING FOR CONNECTION TO EXTERIOR SIGN. PROVIDE CONDUIT FROM BOX TO SIGN LOCATION.
 - 4. PROVIDE 'GTD' REMOTE FROM LIGHT FIXTURE (ABOVE CEILING).
 - 5. PROVIDE UNBUNDLED POWER FROM GENERATOR PANEL.
 - 6. PROVIDE 18GAUS CONDUCTORS TO PANEL.
 - 7. 3-WAY KEY SYSTEM FOR CONTROL OF CORRIDOR LIGHTING CONTACTOR. SEE PANEL SCHEDULE NOT 5, AND E-103.
 - 8. KEY SWITCHES FOR CONTROL OF ATRIUM LIGHTS. SEE E-102.
 - 9. MOTION DETECTOR SWITCH TO OPERATE LIGHTS. INSTALL AT 8' AFF. DETECTOR EQUAL TO SENSOR SWITCH MSD-FST-U.
 - 10. PROVIDE 3-WAY KEY SWITCH AT 6' AFF FOR CONTROL OF SANCTUARY MAINTENANCE LIGHTING CONTACTOR. SEE 4-WAY SWITCH LOCATED IN ROOM 1041 AND 3-WAY SWITCH LOCATED IN SOUND BOOTH.

revisions

for construction

This drawing, as an instrument of service, is and shall remain the property of the Architects and Engineers and shall not be reproduced, published or used in any way without the written permission of the Architect or Engineer.

Copyright © 1998 By
John Ware & Associates, Inc.

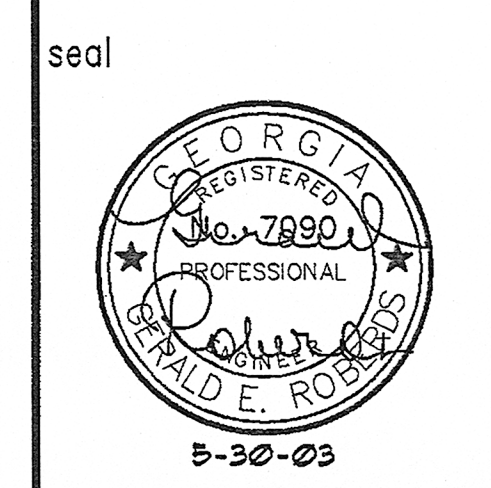

John Ware & Associates, Inc.
Architects & Engineers

1954 Airport Road
Suite 100
Atlanta, GA 30341
(770) 451-1921
FAX (770) 457-1920

project
CHURCH IN THE NOW

address
1873 4 1933
IRIS DRIVE
CONYERS, GA
for
COVENANT SERVICES, INC.
1171 WESLEY WAY
CONYERS, GA

sheet description
**FIRST FLOOR
REFL. CEILING
PLAN- PART I
-LIGHTING**
drawn VJ
checked TW1

job 00-145
date 12/20/01

ROBERDS
CONSULTING
ENGINEERS

455 EAST PACES FERRY ROAD, N.E.
SUITE 300
ATLANTA, GEORGIA 30305
TELEPHONE (404) 237-6832
FACSIMILE (404) 237-6101

2001439 TW1

E-108
of