

revisions

for construction
This drawing, as an instrument of service, is and shall remain the property of the Architect and Engineers and shall not be reproduced, published or used in any way without the written permission of the Architect or Engineer.
Copyright © 2001 By
A.M.C. Consulting Engineers, Inc.

seal



John Ware & Associates, Inc.
Architects & Engineers

1954 Airport Road
Suite 100
Atlanta, GA 30341
(770) 451-1921
FAX (770) 457-1920

project
**CHURCH
IN THE NOW**

address
1873 & 1933
IRIS DRIVE
CONYERS, GA
for
**COVENANT
SERVICES INC**
1111 WESLEY WAY
CONYERS, GA

sheet description
PARTIAL 1st FLOOR
PLAN - HVAC


drawn
checked AMC

job 01-145


date 08/15/02

M-101

of 6

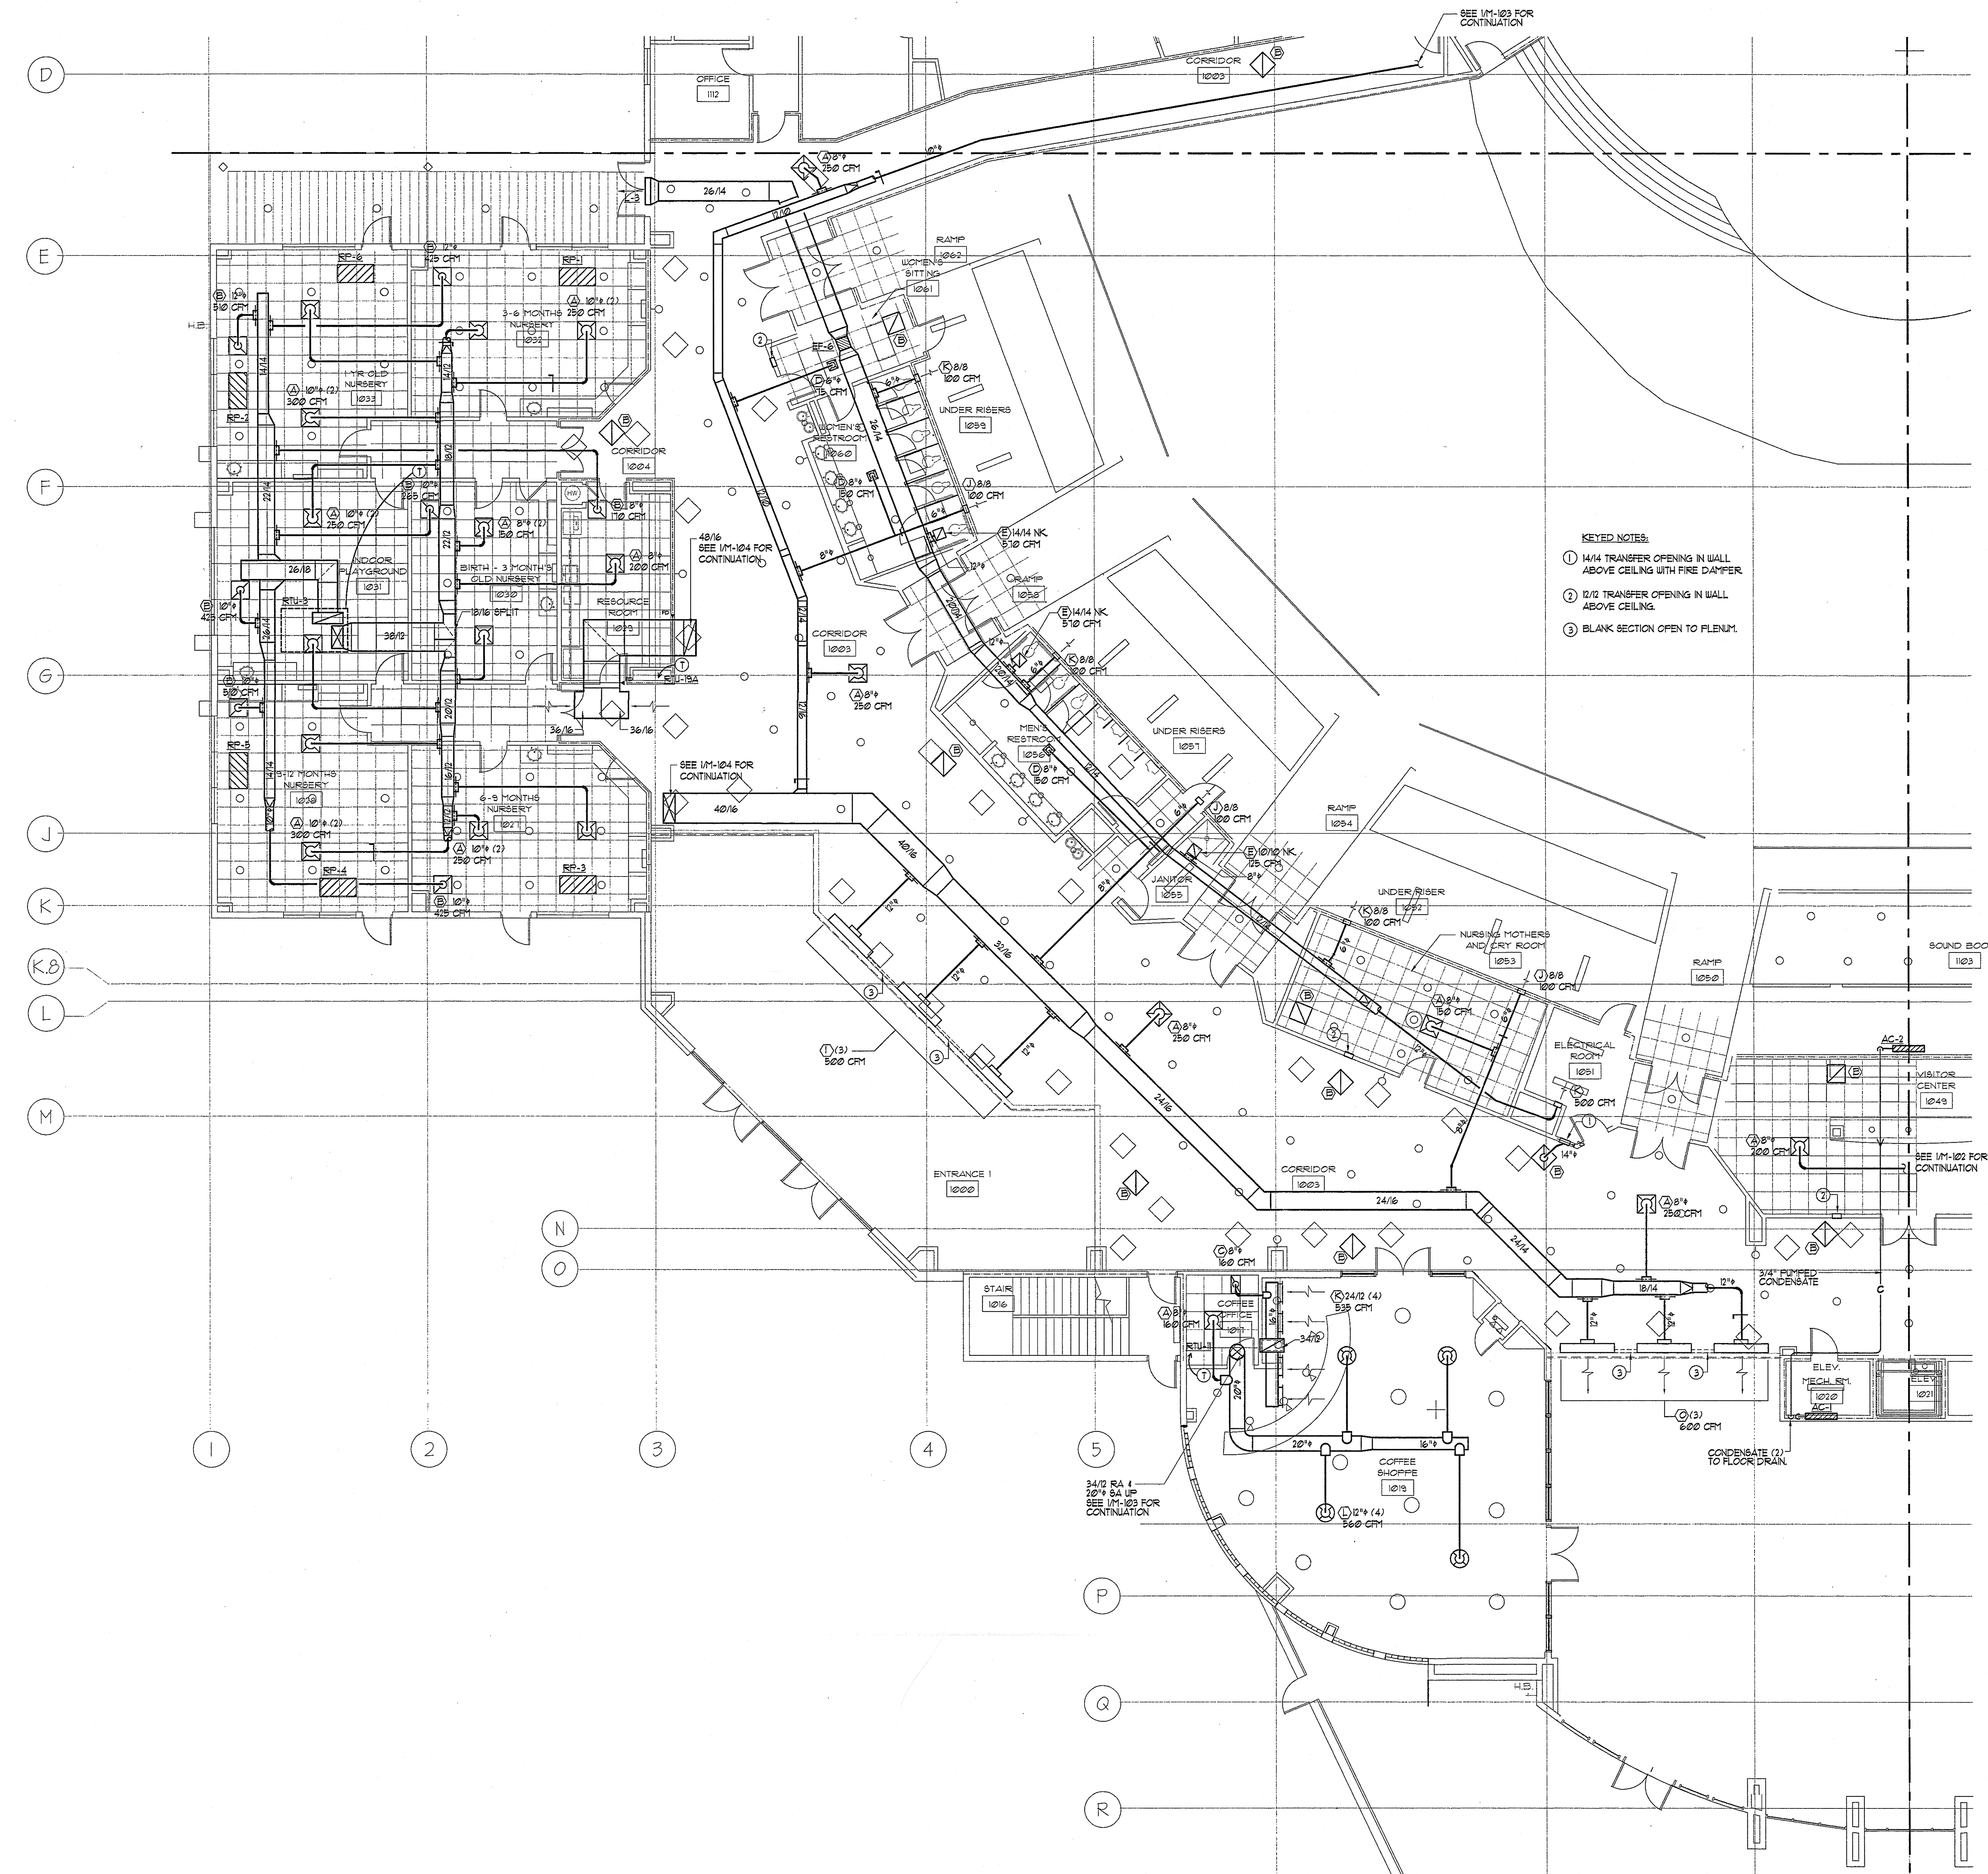

PARTIAL 1st FLOOR PLAN - HVAC
SCALE: 1/8" = 1'-0"

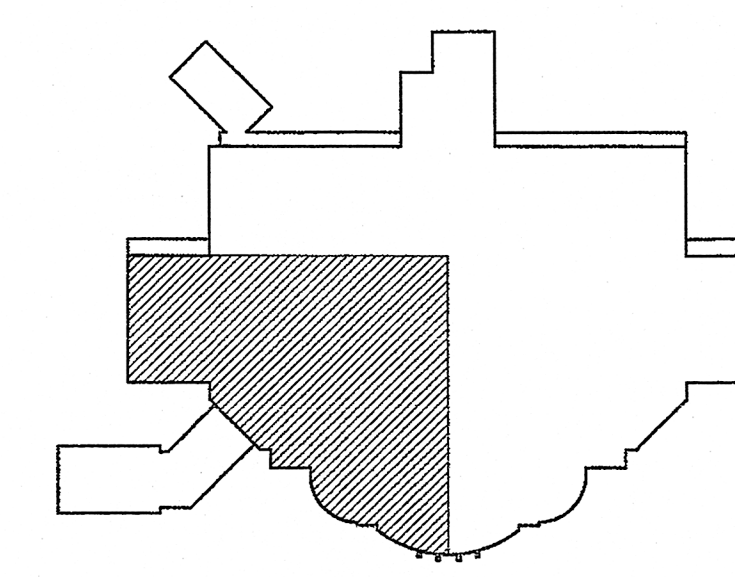

KEY PLAN

AMC
CONSULTING
ENGINEERS, INC.
1827 POWERS FERRY ROAD
BLDG 18, SUITE 100
ATLANTA, GEORGIA
30339
PHONE (770) 980-0581
FAX (770) 988-6340