



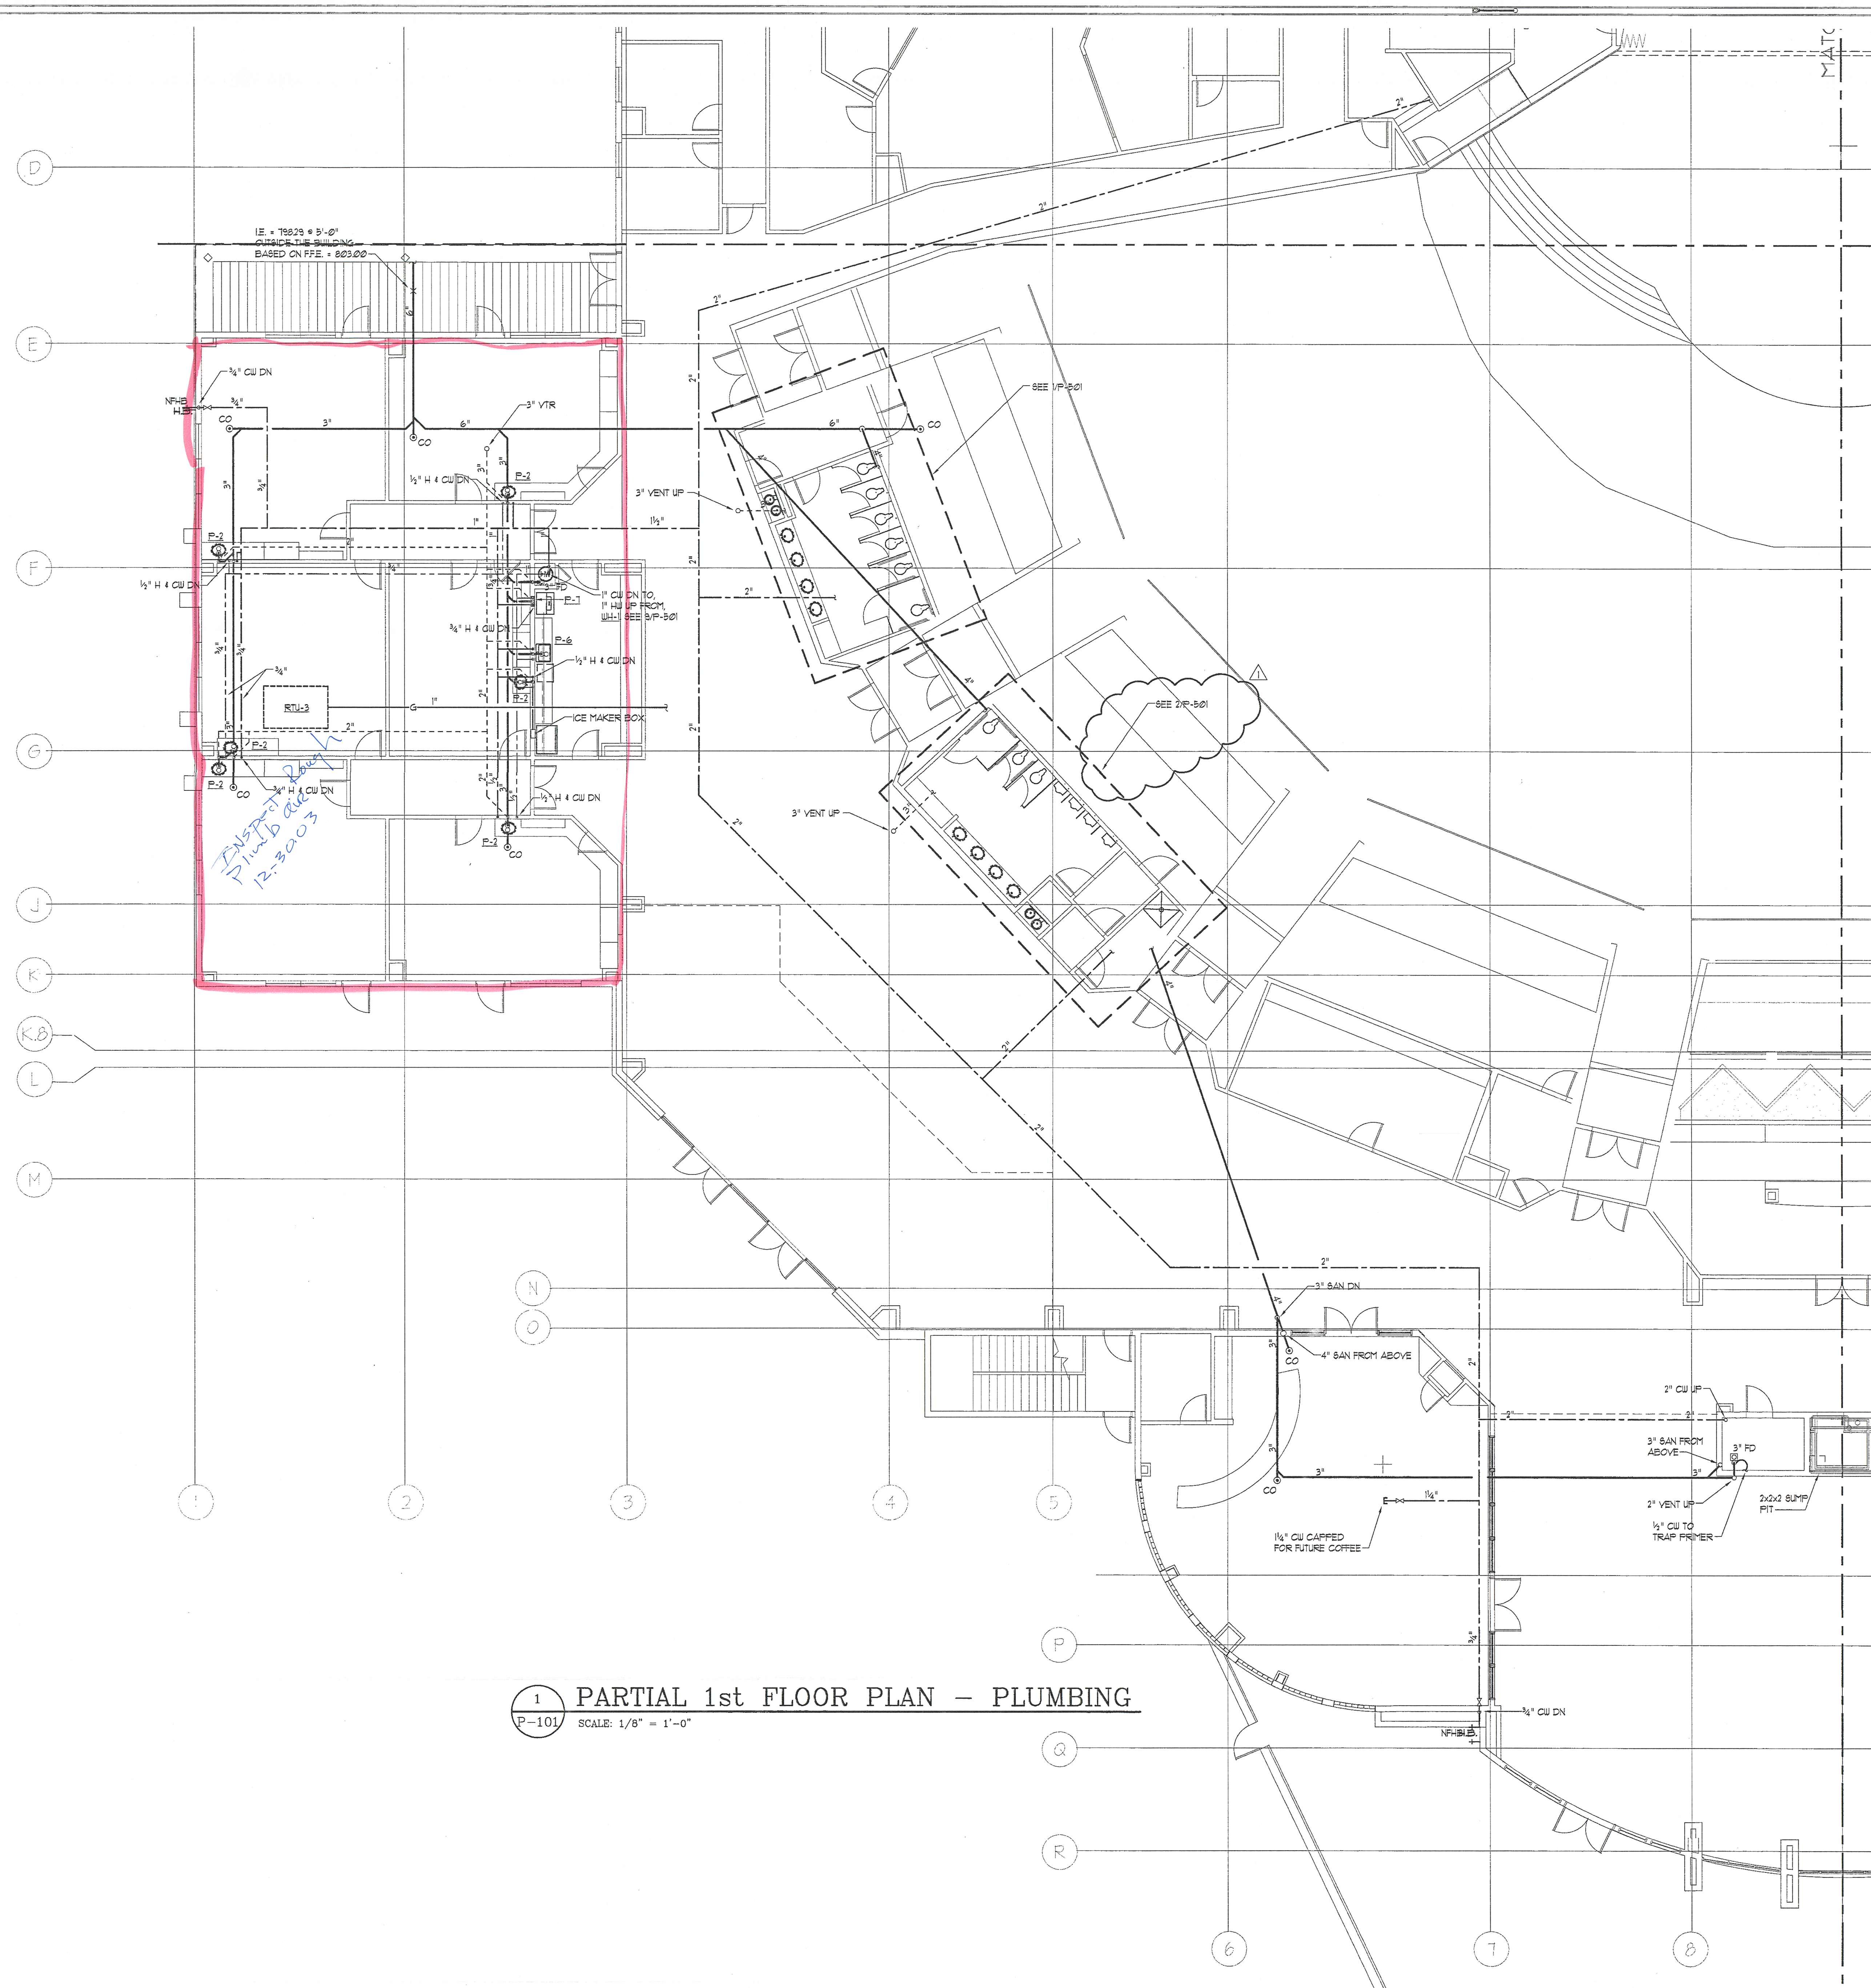

1 PARTIAL 1st FLOOR PLAN - PLUMBING
P-101 SCALE: 1/8" = 1'-0"

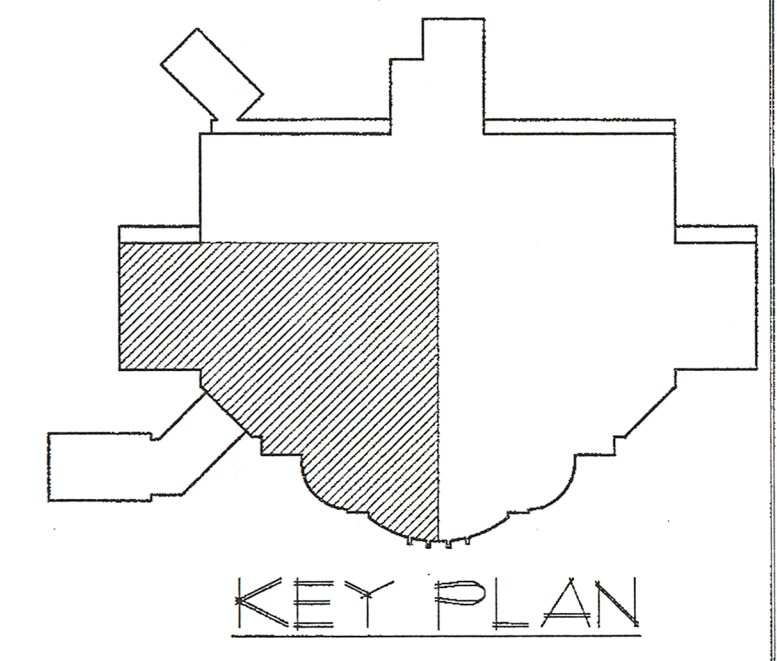

revisions
3/5/03 GENERAL REVISION

for construction
This drawing, as an instrument of service, is and shall remain the property of the Architects and Engineers and shall not be reproduced, published or used in any way without the written permission of the Architect or Engineer.
Copyright © 2001 By
A.M.C. Consulting Engineers, Inc.

seal

John Ware & Associates, Inc.
Architects & Engineers
1954 Airport Road
Suite 100
Atlanta, GA 30341
(770) 451-1921
FAX (770) 457-1920

project
**CHURCH
IN THE NOW**

address
1873 4 1933
IRIS DRIVE
CONTERS, GA
for
**COVENANT
SERVICES INC**
1111 WESLEY WAY
CONTERS, GA

sheet description
PARTIAL 1ST FLOOR PLAN -
PLUMBING

drawn
checked AMC

job 01-145
date 08/15/02

2/12/01

1827 POWERS FERRY ROAD
BLDG. 19, SUITE 100
ATLANTA, GEORGIA
30339
PHONE: (770) 980-0581
FAX: (770) 988-8340

P-101
of