


LEGEND NOTES:
 (THIS SHEET ONLY)
 JUNCTION BOX AT BOTTOM CHORD OF ROOF STRUCTURE FOR FUTURE CONNECTION TO RECEPTACLE. WRITE CIRCUIT NUMBER ON COVER PLATE.

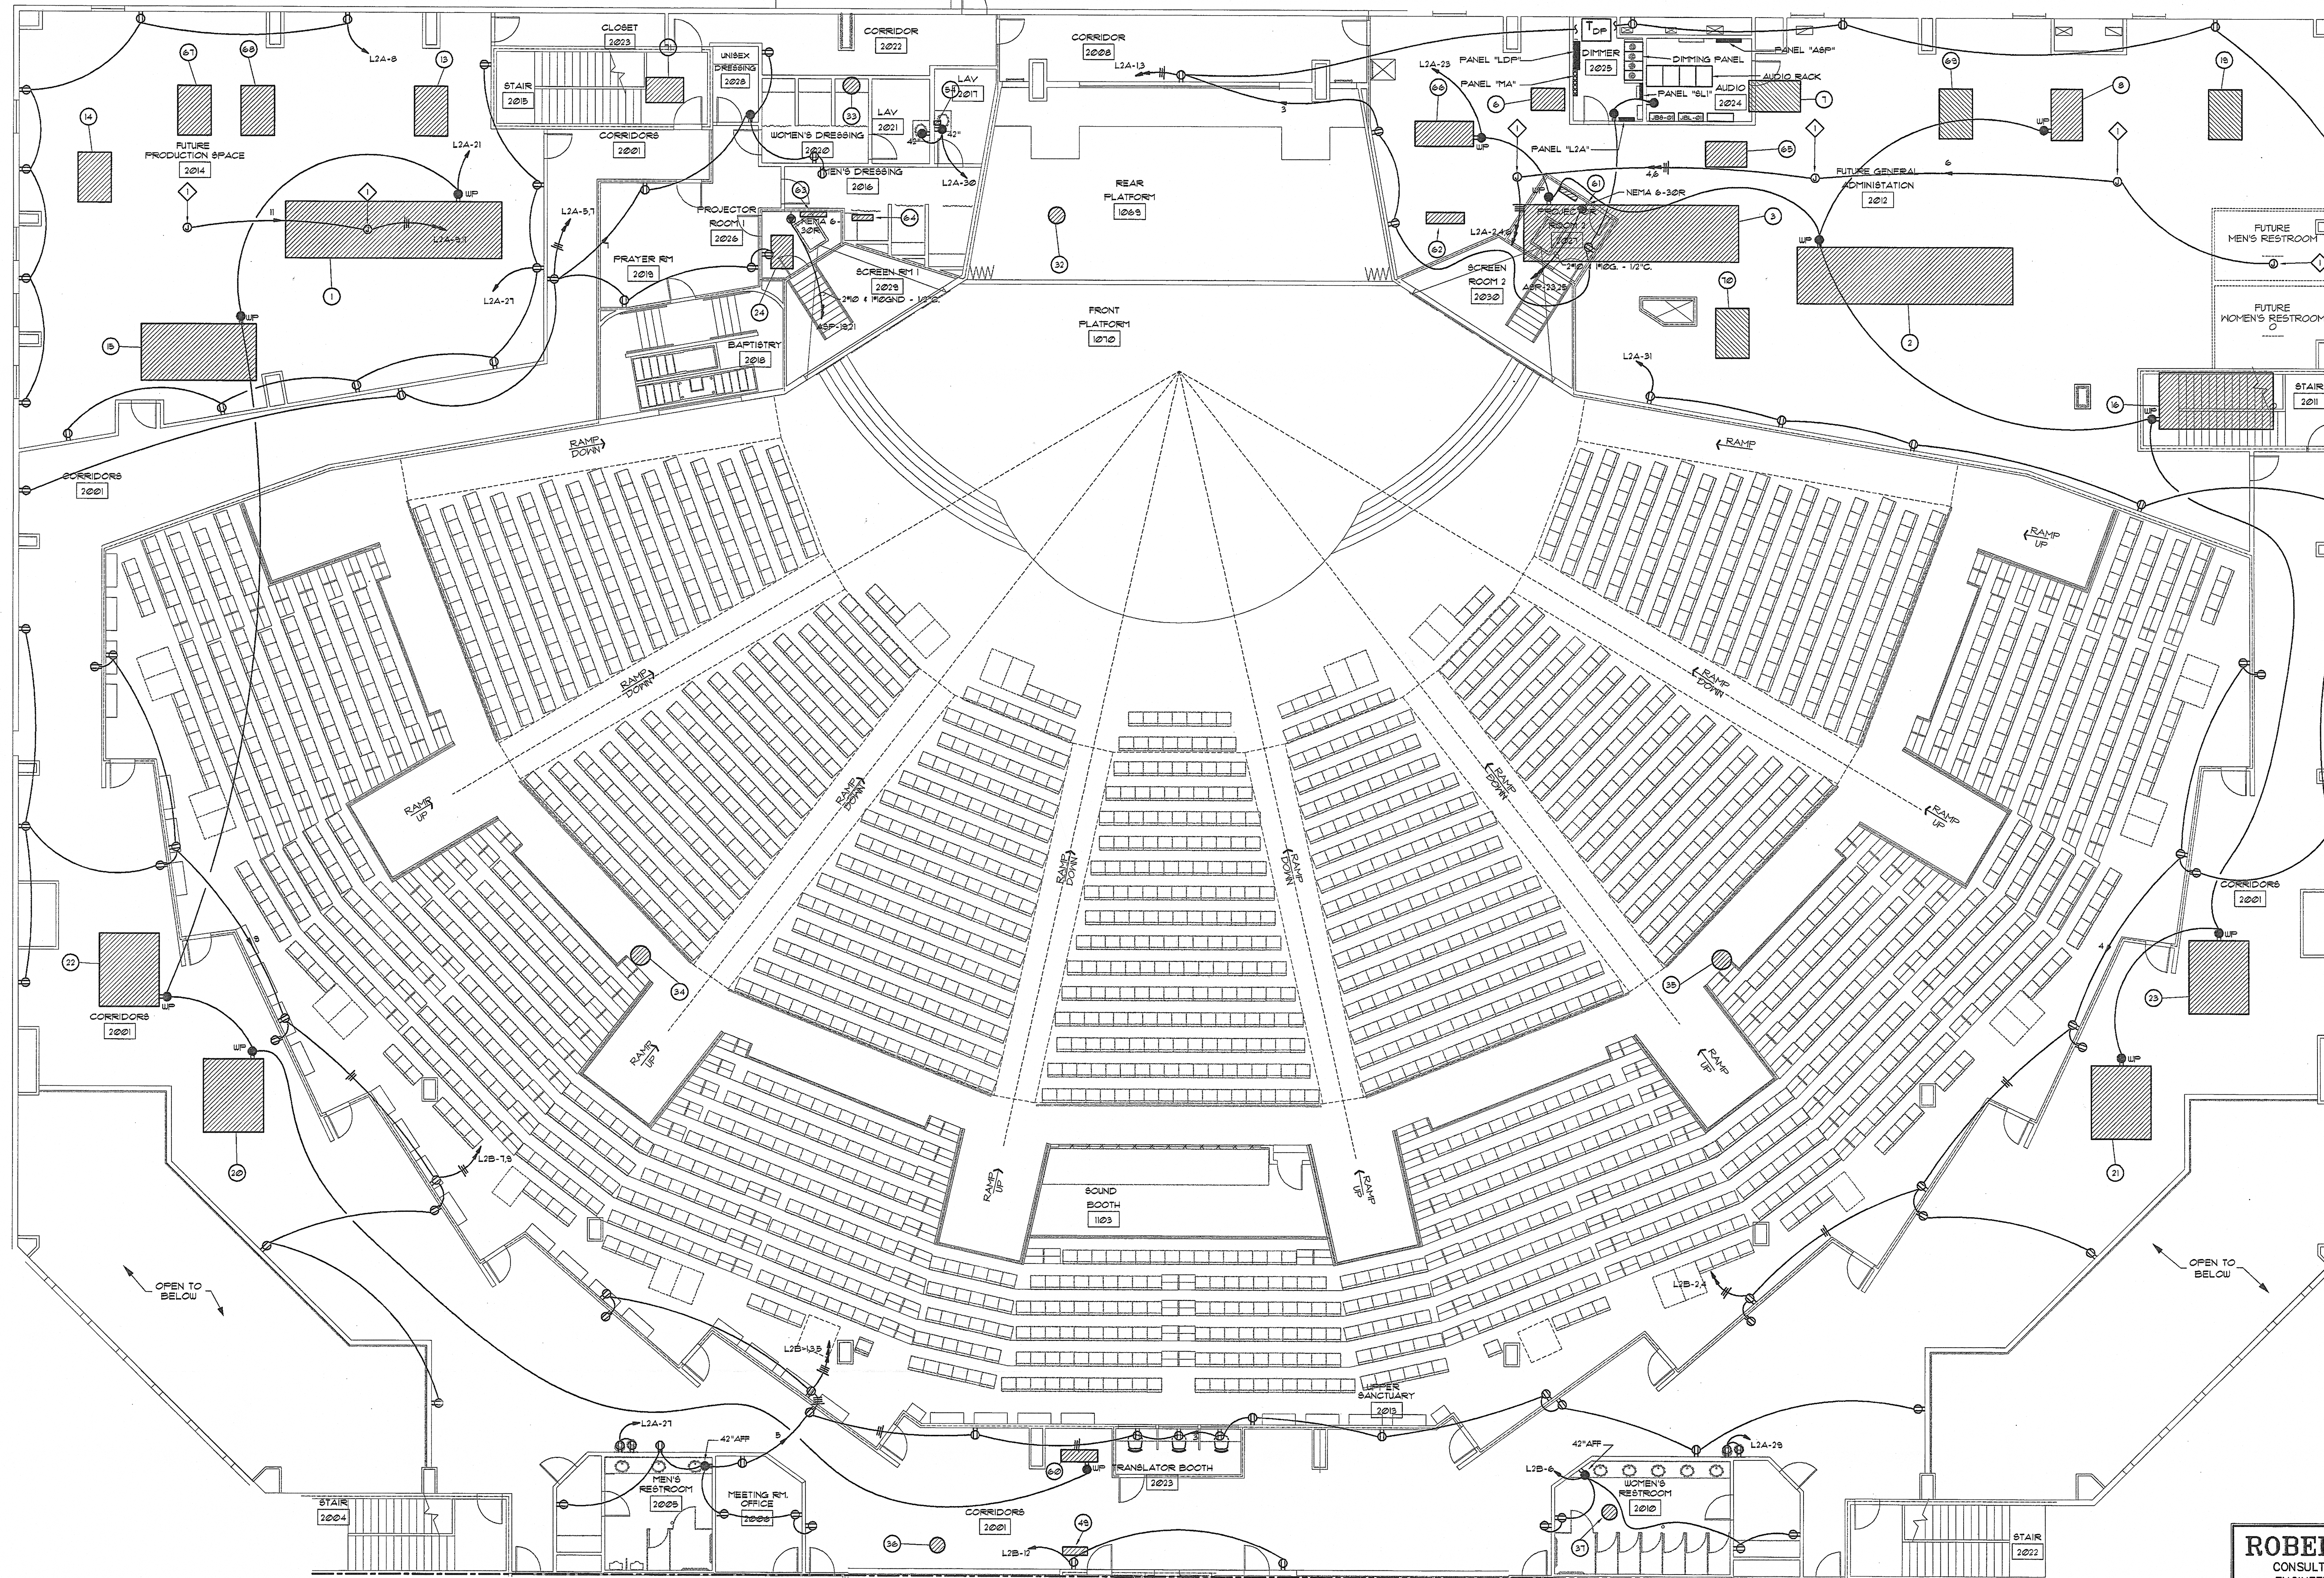


1 SECOND FLOOR PLAN - PART 1 - POWER
 E-106 SCALE: 1/8" = 1'-0"

ROBERDS
 CONSULTING
 ENGINEERS
 455 EAST PACES FERRY ROAD, N.E.
 SUITE 300
 ATLANTA, GEORGIA 30305
 TELEPHONE (404) 237-8832
 FACSIMILE (404) 237-4101
 2001439 TWM

revisions

for construction
 This drawing, as an instrument of service, is and shall remain the property of the Architects and Engineers and shall not be reproduced, published or used in any way without the written permission of the Architect or Engineer.
 Copyright © 1998 By
 John Ware & Associates, Inc.

seal

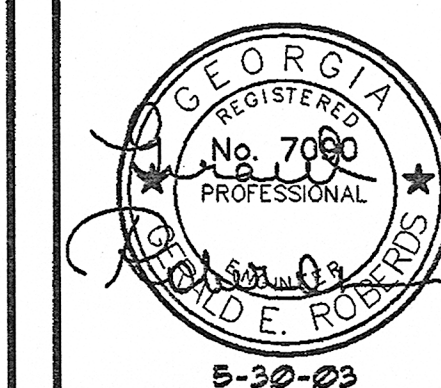

John Ware & Associates, Inc.
 Architects & Engineers

1954 Airport Road
 Suite 100
 Atlanta, GA 30341
 (770) 451-1921
 FAX (770) 457-1920

project
**CHURCH
 IN THE NOW**

address
 1873 4 1933
 IRIS DRIVE
 CONYERS, GA
 for
**COVENANT
 SERVICES, INC.**
 1111 WESLEY WAY
 CONYERS, GA

sheet description
**SECOND
 FLOOR PLAN -
 PART 1 - POWER**

drawn VJ
 checked TWM

job 00-143

date 12/20/01

E-106

of