



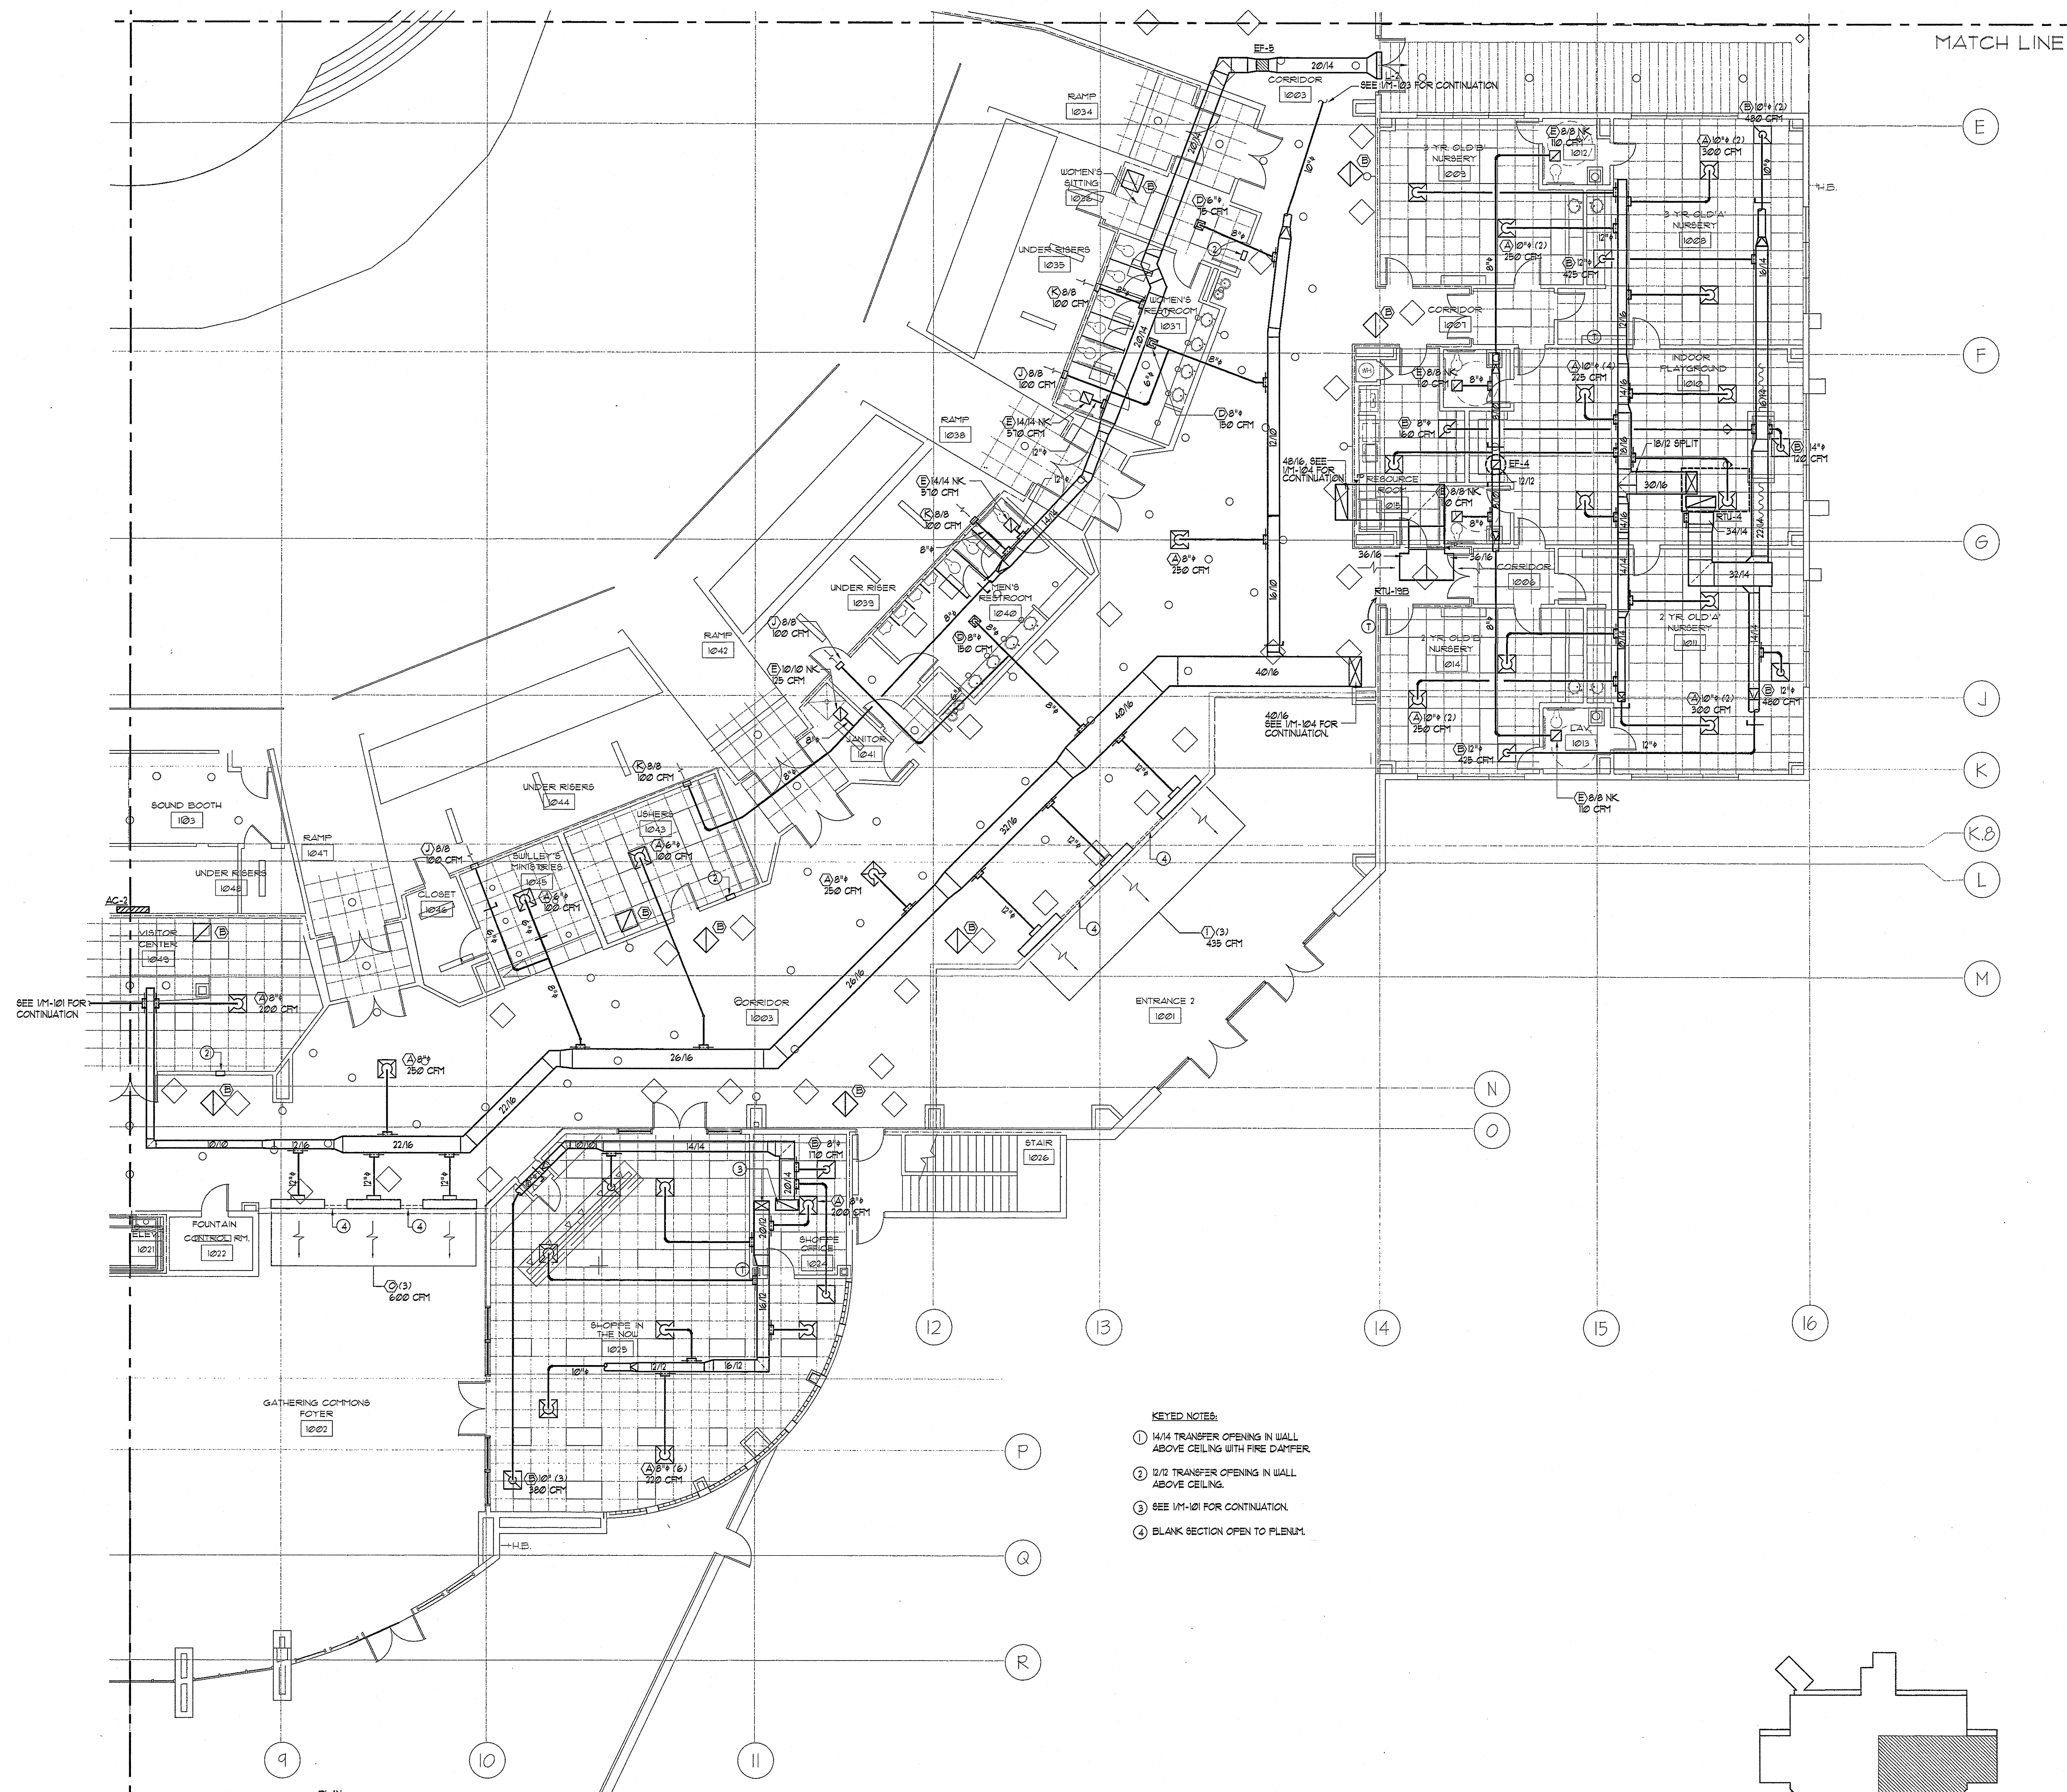

- KEYED NOTES:**
- ① 14/14 TRANSFER OPENING IN WALL ABOVE CEILING WITH FIRE DAMPER.
 - ② 12/12 TRANSFER OPENING IN WALL ABOVE CEILING.
 - ③ SEE 1M-101 FOR CONTINUATION.
 - ④ BLANK SECTION OPEN TO FLENUM.

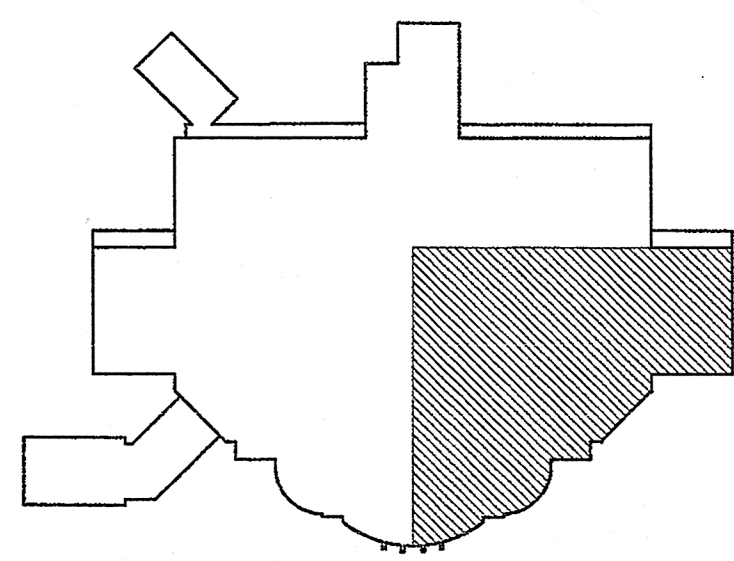

KEY PLAN

1 PARTIAL 1st FLOOR PLAN - HVAC
M-102 SCALE: 1/8" = 1'-0"

revisions

for construction
This drawing, as an instrument of service, is and shall remain the property of the Architects and Engineers and shall not be reproduced, published or used in any way without the written permission of the Architect or Engineer.
Copyright © 2001 By
A.M.C. Consulting Engineers, Inc.

seal



John Ware & Associates, Inc.
Architects & Engineers

1954 Airport Road
Suite 100
Atlanta, GA 30341
(770) 451-1921
FAX (770) 457-1920

project
CHURCH IN THE NOW

address
1873 4 1933
IRIS DRIVE
CONYERS, GA
for
COVENANT SERVICES INC
1711 WESLEY WAY
CONYERS, GA

sheet description
PARTIAL 1st FLOOR
PLAN - HVAC

drawn
checked AMC

job 01-145

date 02/15/02

M-102

of 6

212001
AMC
CONSULTING
ENGINEERS, INC.
1827 POWERS FERRY ROAD
BLOD 18, SUITE 100
ATLANTA, GEORGIA
30339
PHONE: (770) 980-0581
FAX: (770) 985-8340