



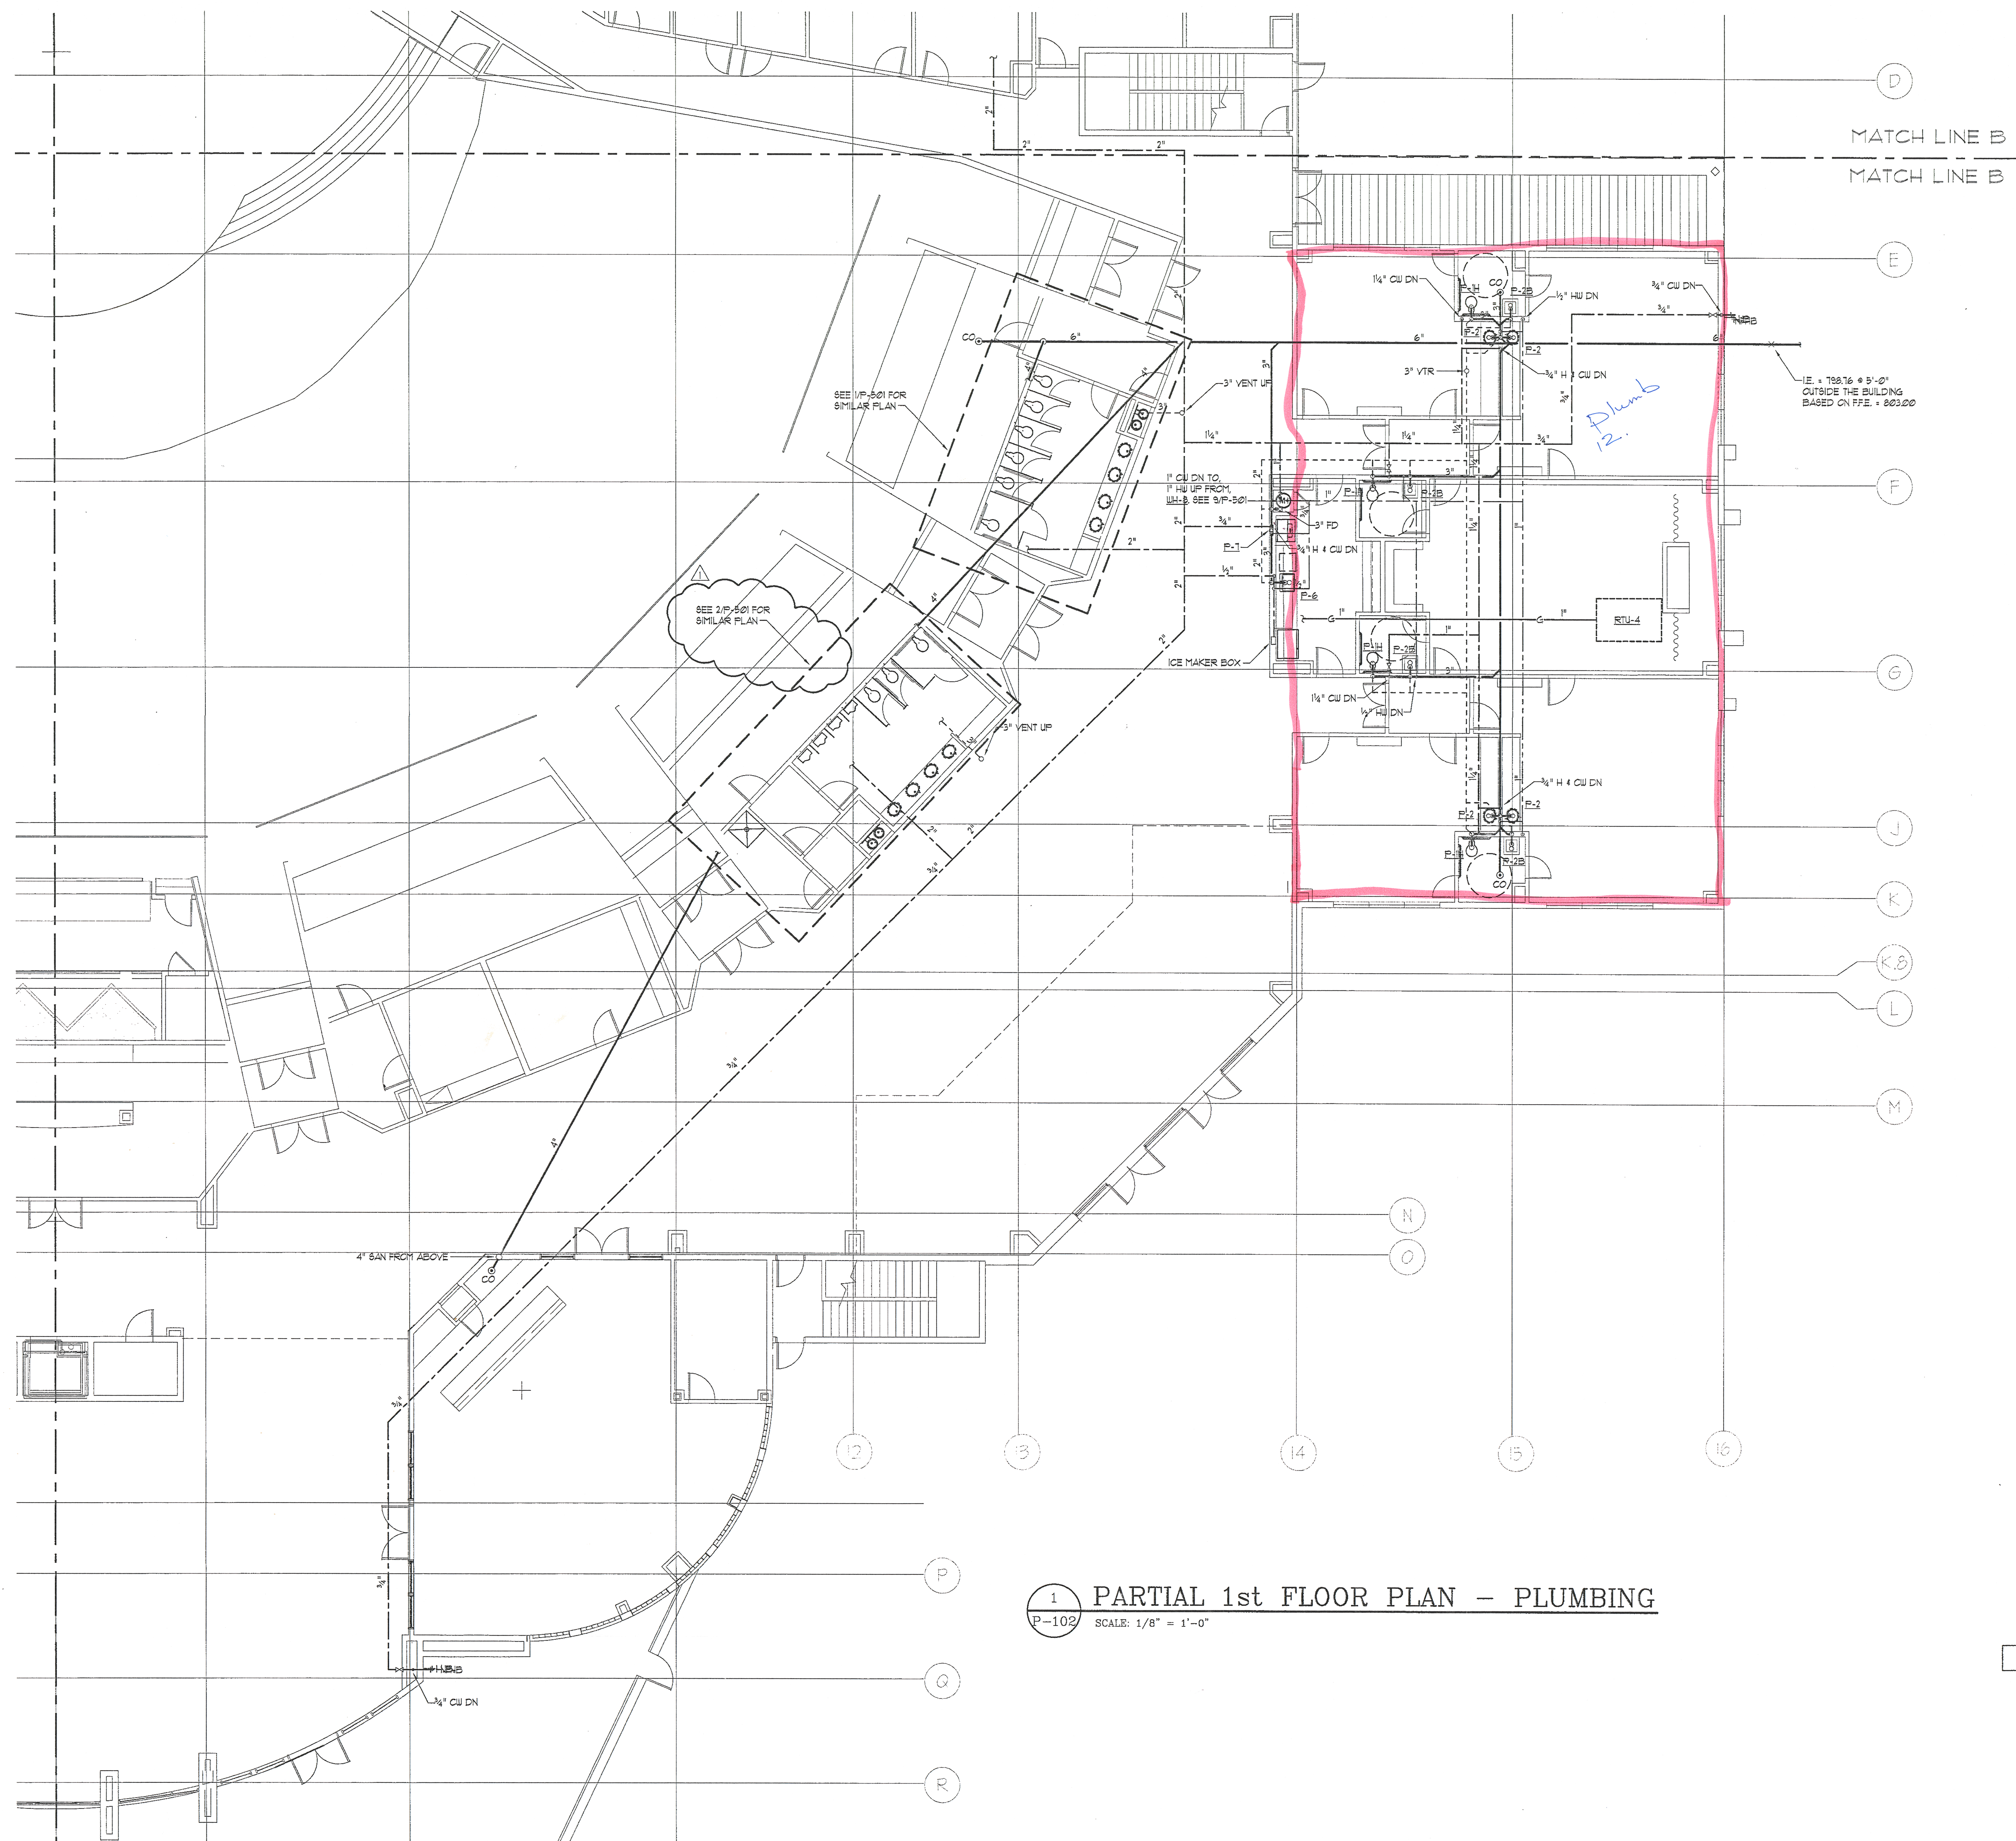


1 PARTIAL 1st FLOOR PLAN - PLUMBING  
P-102 SCALE: 1/8" = 1'-0"

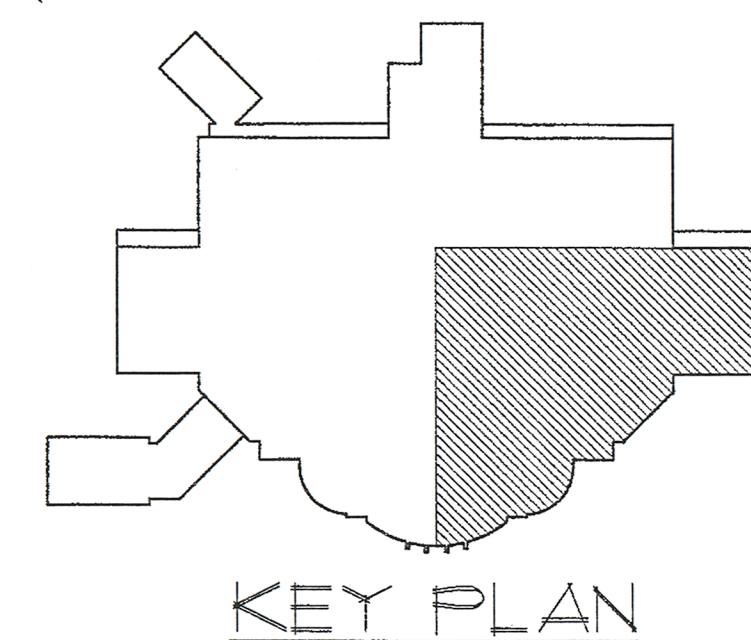

revisions  
B/B/03 GENERAL REVISION

for construction  
This drawing, as an instrument of service, is and shall remain the property of the Architects and Engineers and shall not be reproduced, published or used in any way without the written permission of the Architect or Engineer.  
Copyright © 2001 By  
A.M.C. Consulting Engineers, Inc.

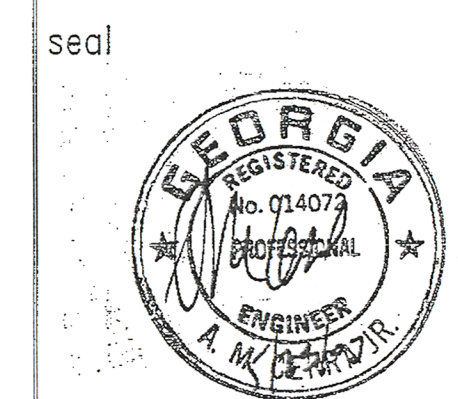

**John Ware & Associates, Inc.**  
Architects & Engineers  
1954 Airport Road  
Suite 100  
Atlanta, GA 30341  
(770) 451-1921  
FAX (770) 457-1920

project  
**CHURCH IN THE NOW**

address  
1873 4 1933  
IRIS DRIVE  
CONYERS, GA  
for  
**COVENANT SERVICES INC**  
1771 WEELEY WAY  
CONYERS, GA

sheet description  
PARTIAL 1ST FLOOR PLAN - PLUMBING

drawn  
checked AMC

job 01-145

date 08/15/02

2112021  
**AMC**  
CONSULTING ENGINEERS, INC.  
1827 POWERS FERRY ROAD  
BLDG 1A, SUITE 100  
ATLANTA, GEORGIA 30339  
PHONE: (770) 980-0581  
FAX: (770) 988-8340