

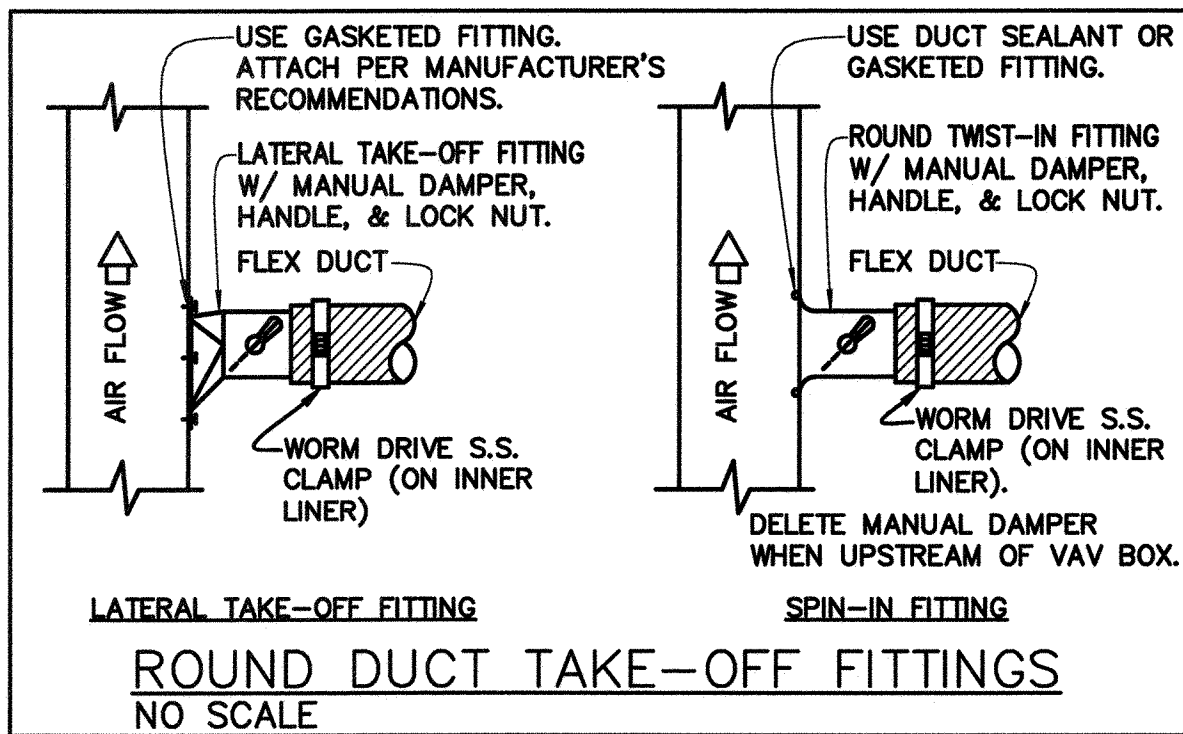
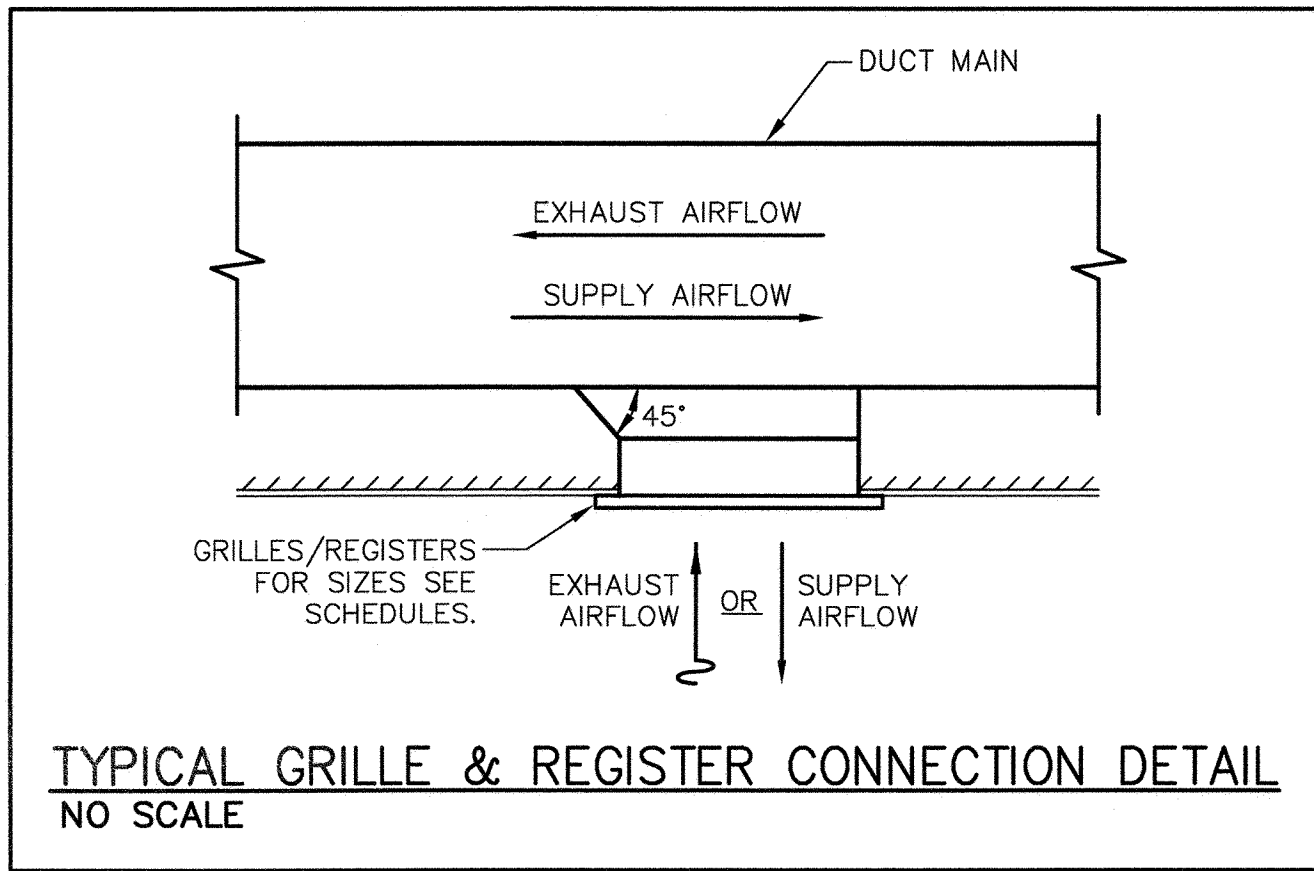
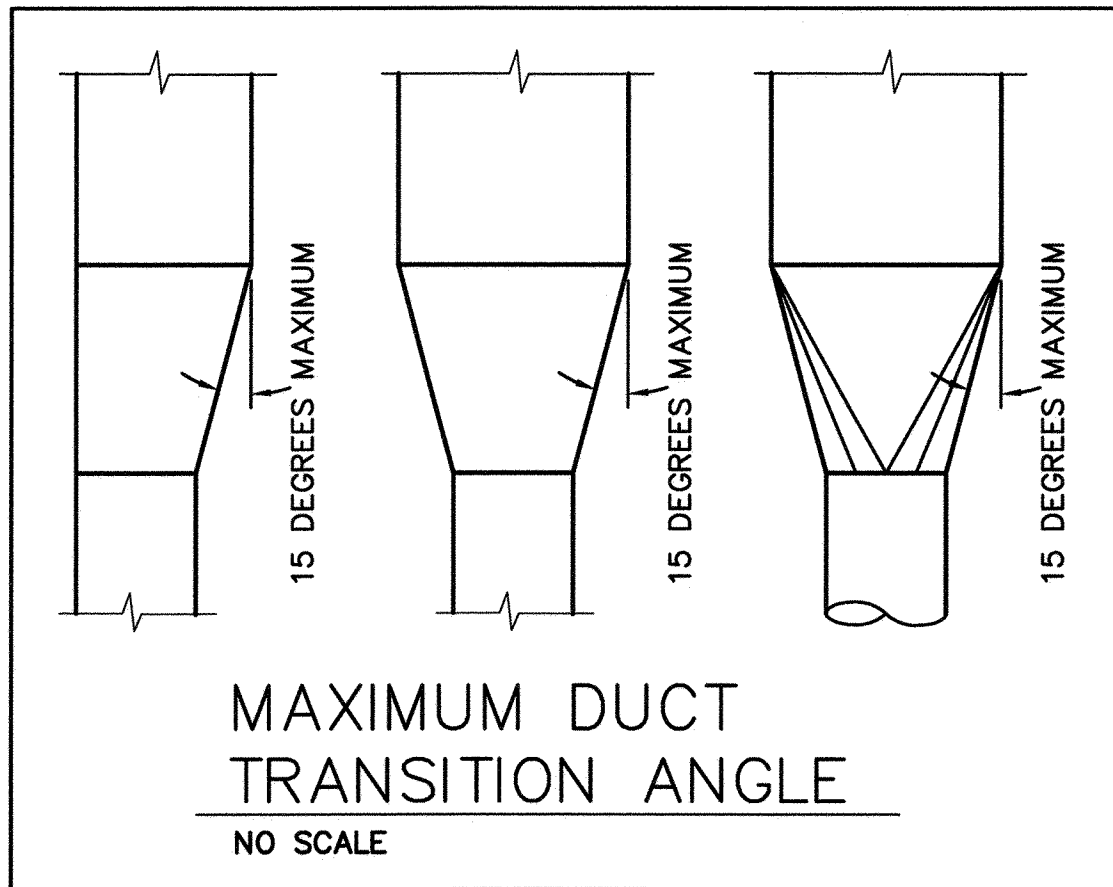
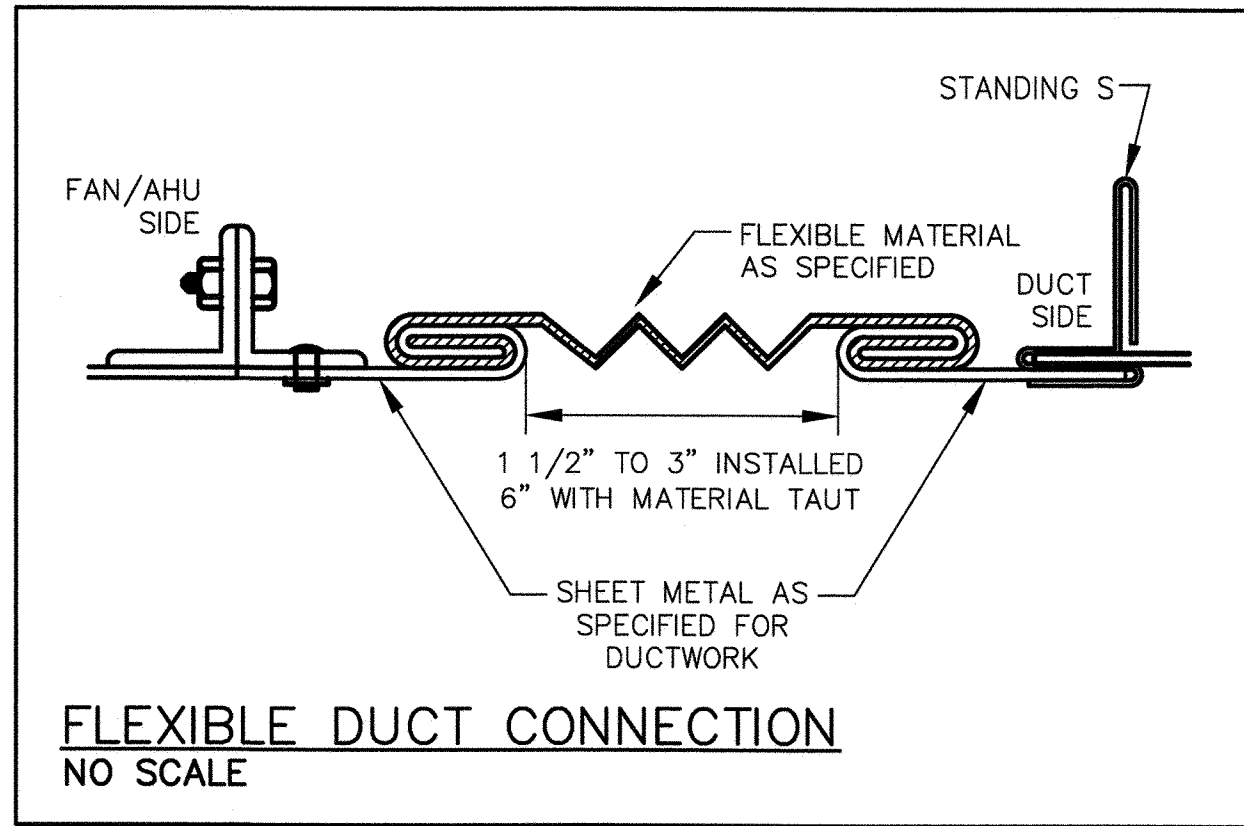


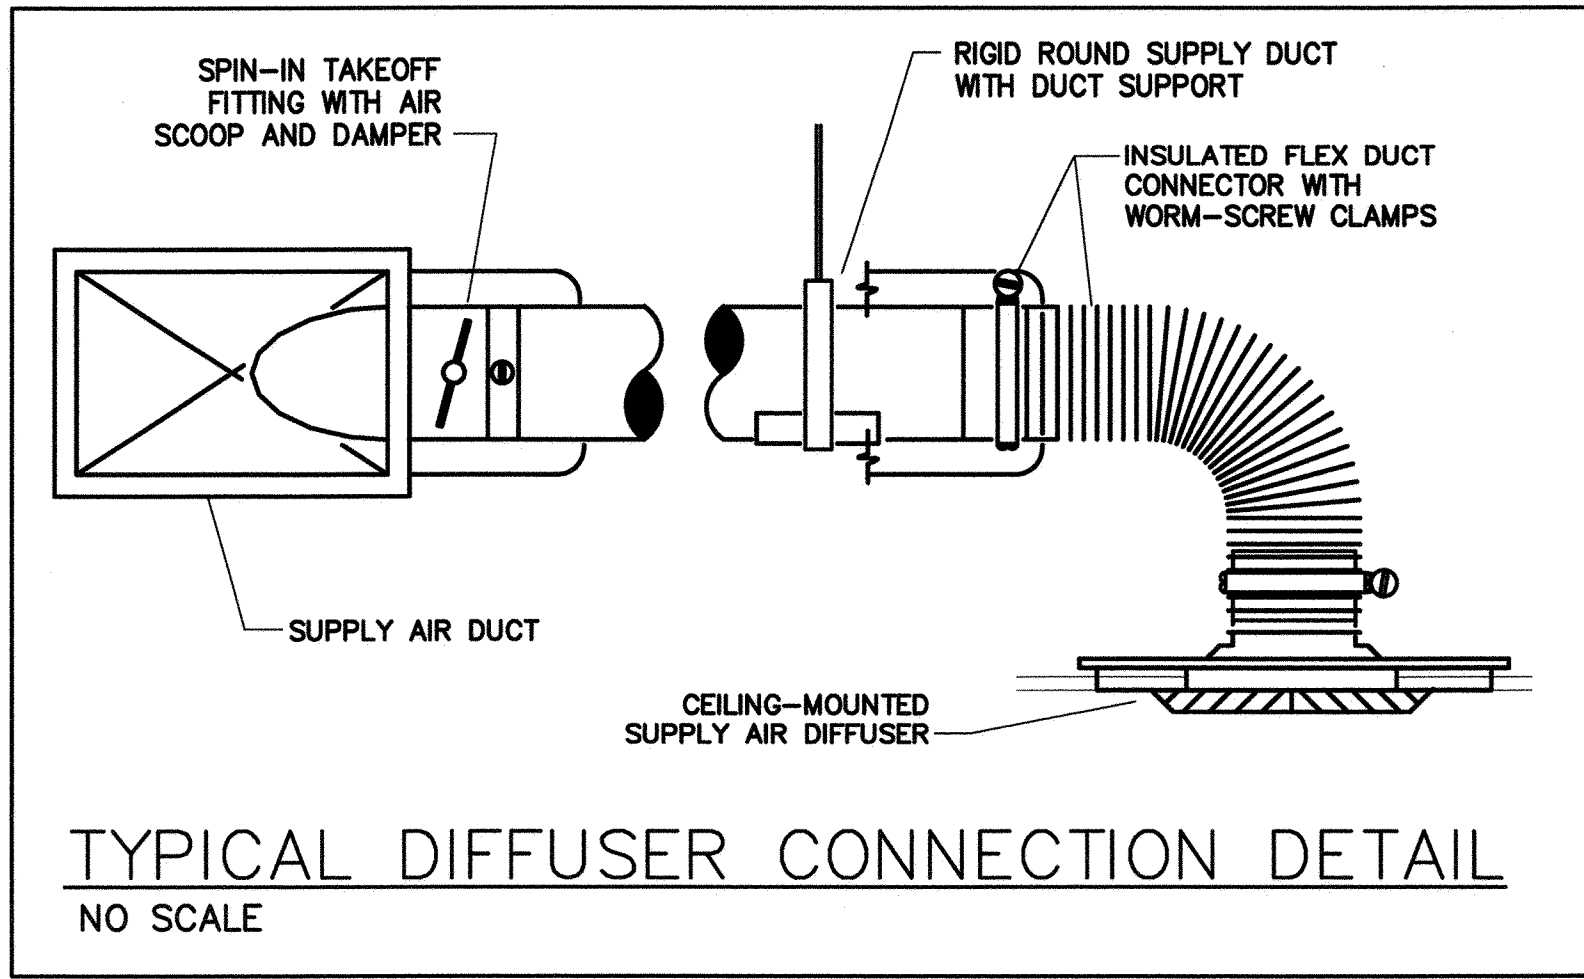

ISSUE / REVISIONS

0 (2/28/22) ISSUE FOR PERMIT AND CONSTRUCTION

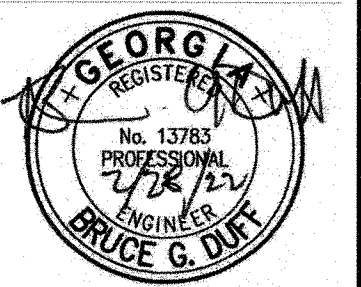

RENOVATIONS TO
WATSON STREET WAREHOUSE
6667 WATSON STREET
UNION CITY, GA

Kent Ahrenhold
Architect
6851 ROSWELL RD. NE, NO K-22
ATLANTA, GEORGIA 30328
PHONE: 404-374-6985

DRAWN BY
JEL

CHECKED BY
BGD

DATE
28 Feb. 2022

DRAWING TITLE
HVAC DETAILS

SHEET NO.

M-1.1