


OFFICE
BLDG. AREA #1

***SEE MECHANICAL EQUIPMENT SCHEDULE, SHEET E-2.0**

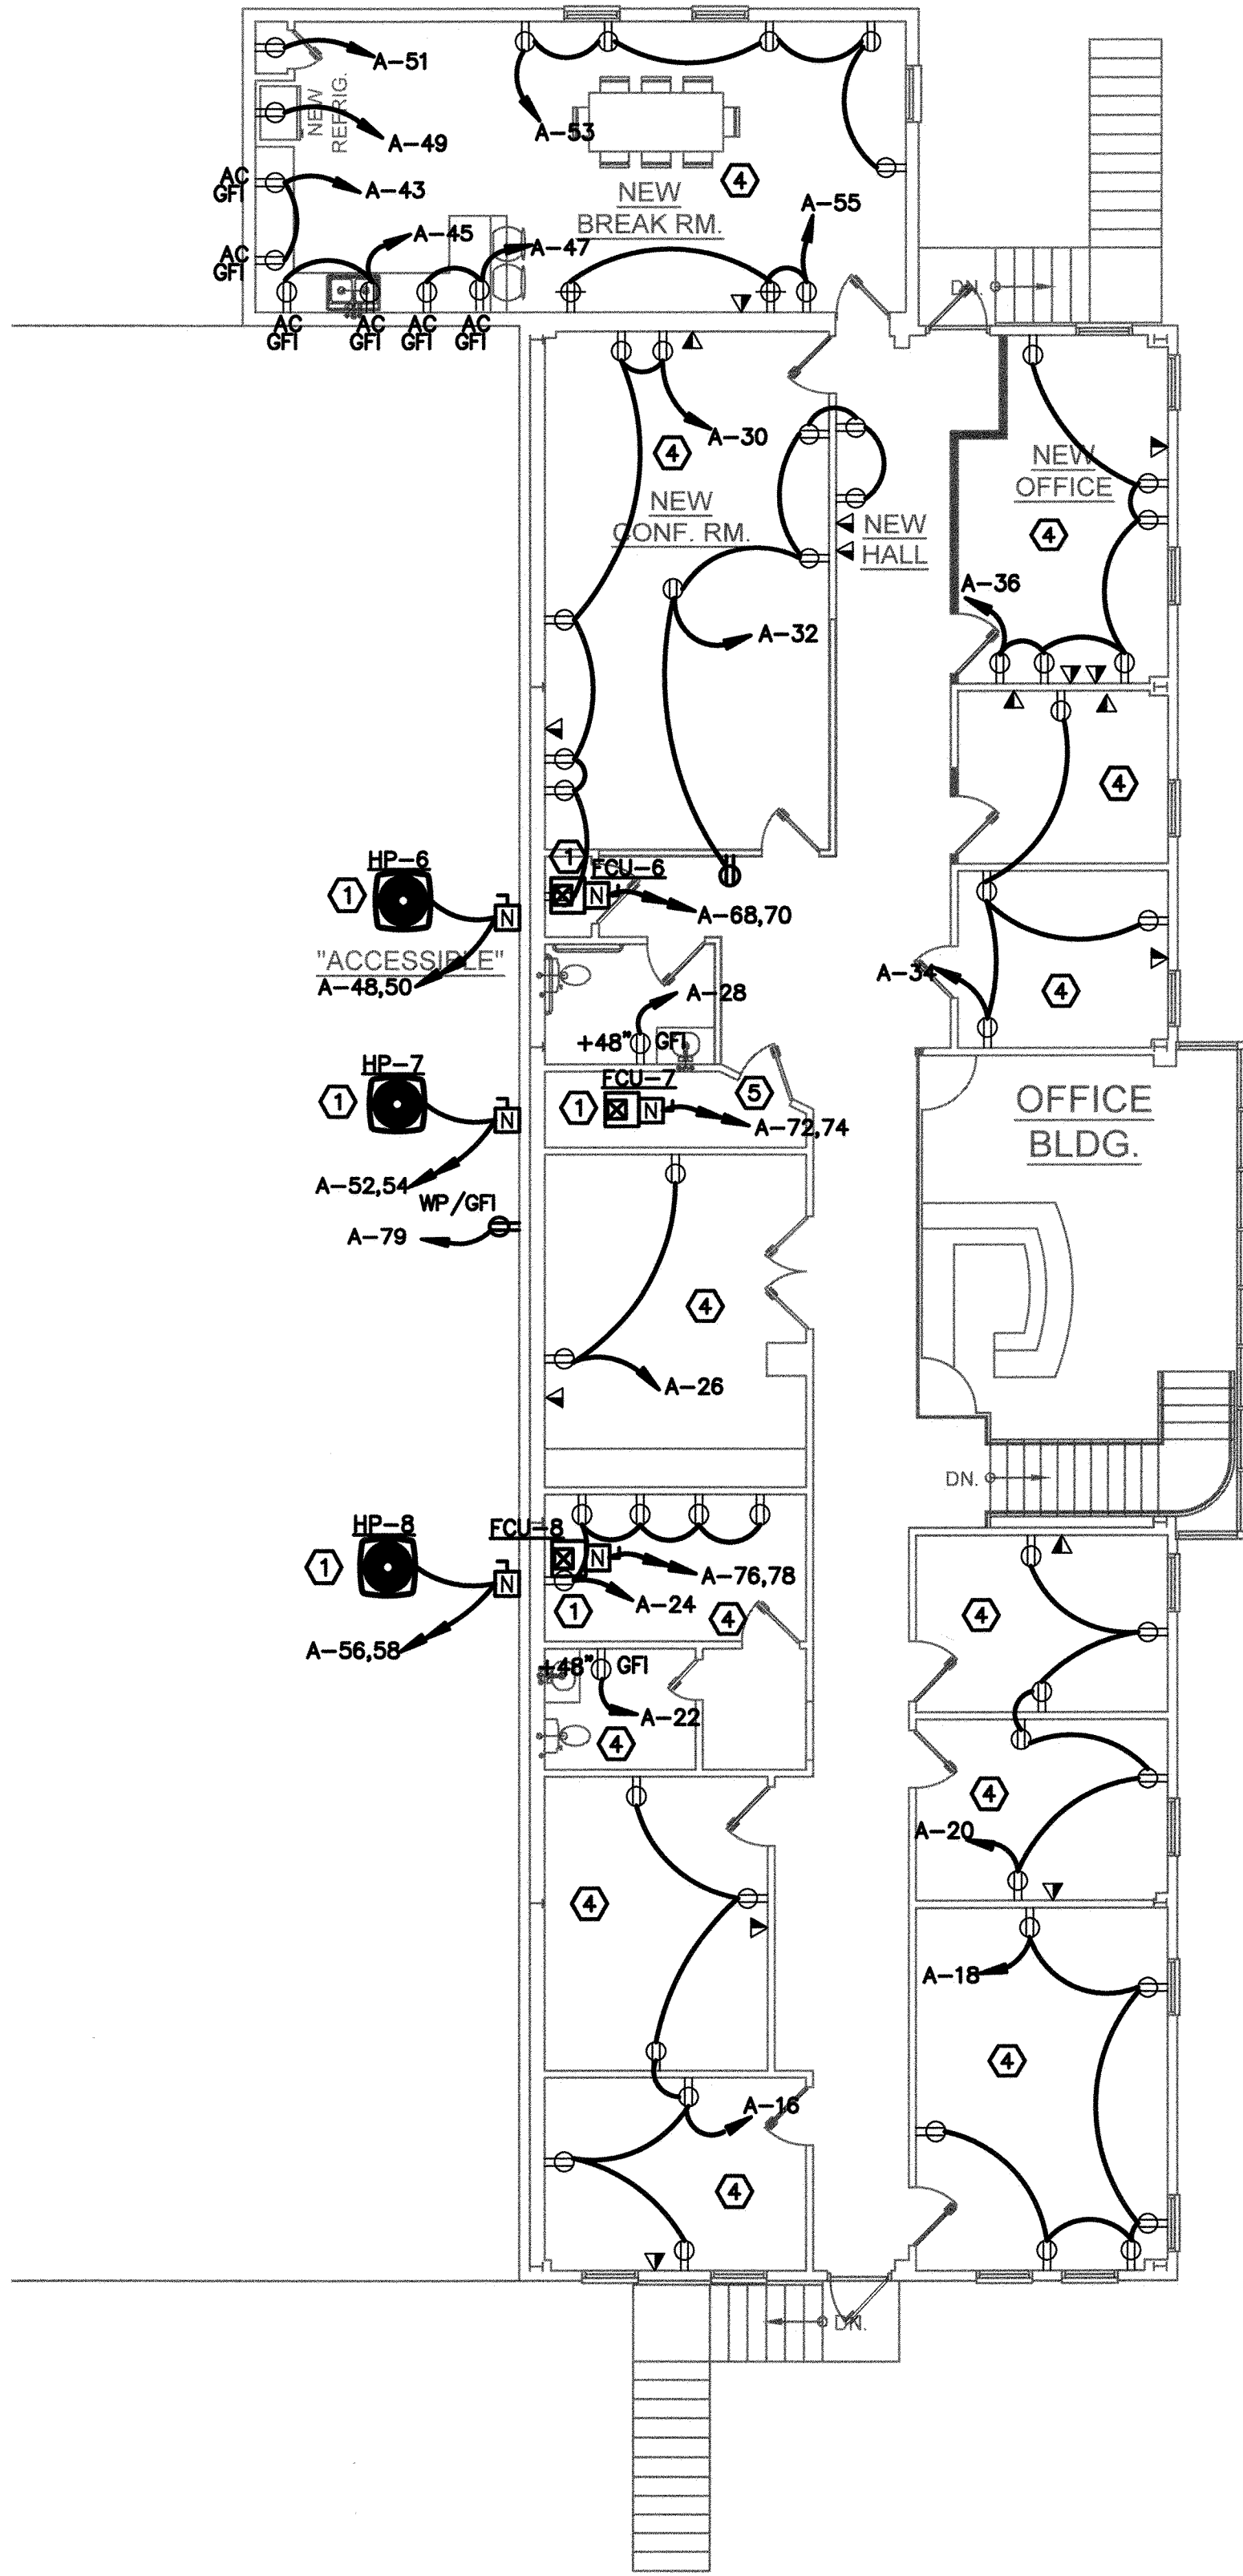

POWER PLAN — SECOND FLOOR
SCALE: 1/8" = 1'-0"

ISSUE / REVISIONS
0 (2-28-22) ISSUE FOR PERMIT AND CONSTRUCTION



RENOVATIONS TO
WATSON STREET WAREHOUSE
6667 WATSON STREET
UNION CITY, GA

Kent Ahrenhold
Architect

6851 ROSWELL RD. NE, NO K-22
ATLANTA, GEORGIA 30328
PHONE: 404-374-6985

RAWN BY
DAM

HECKED BY
JAN

DATE
Feb. 2022

DRAWING TITLE
ELECTRICAL
POWER PLAN
2ND FLOOR

SHEET NO. _____

E-2.1

RELEASED FOR
CONSTRUCTION

**CS CORNERSTONE
DS DESIGN SERVICES**
Mechanical | Electrical | Plumbing | HVAC | Fire Safety
3740 DAVINCI CT, SUITE 100 PEACHTREE CORNERS, GA 30092
o 770.717.0060 w www.csdesignservices.net

**CS CORNERSTONE
DS DESIGN SERVICES**
Mechanical | Electrical | Plumbing | HVAC | Fire Safety
3740 DAVINCI CT, SUITE 100 PEACHTREE CORNERS, GA 30092
o 770.717.0060 w www.csdesignservices.net