



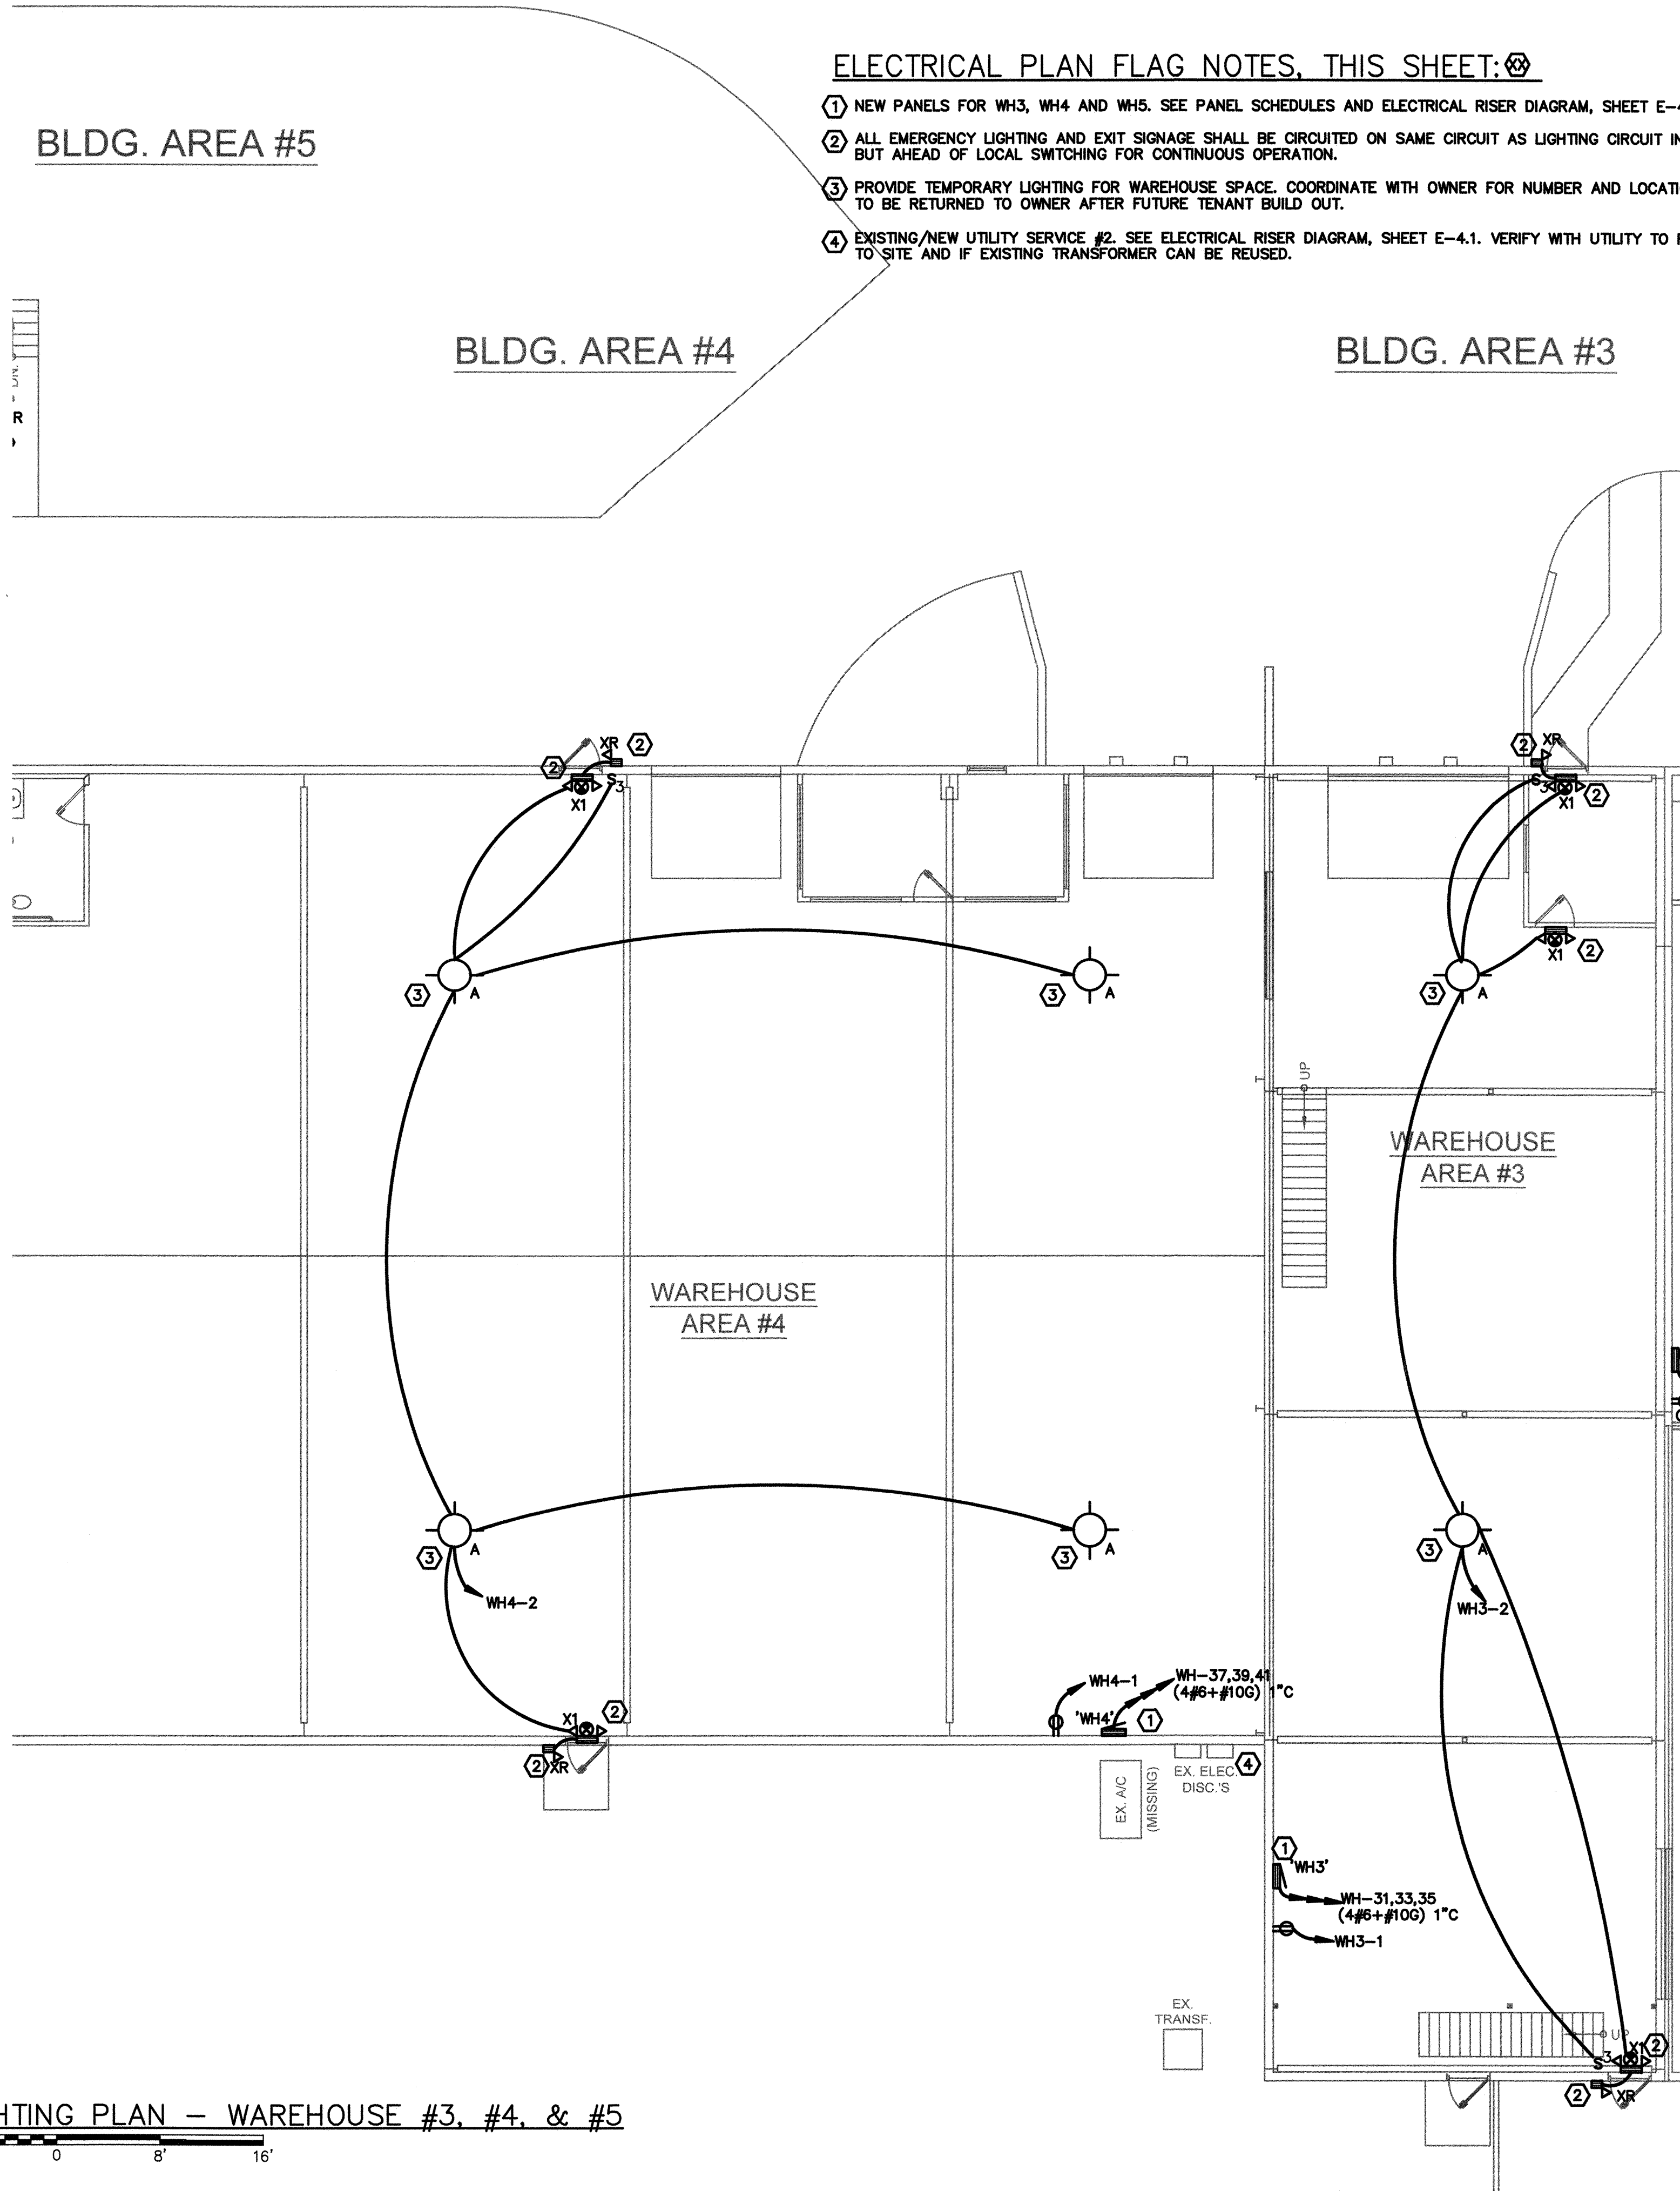

- ELECTRICAL PLAN FLAG NOTES, THIS SHEET:**
- 1 NEW PANELS FOR WH3, WH4 AND WH5. SEE PANEL SCHEDULES AND ELECTRICAL RISER DIAGRAM, SHEET E-4.1.
 - 2 ALL EMERGENCY LIGHTING AND EXIT SIGNAGE SHALL BE CIRCUITED ON SAME CIRCUIT AS LIGHTING CIRCUIT IN SAME SPACE, BUT AHEAD OF LOCAL SWITCHING FOR CONTINUOUS OPERATION.
 - 3 PROVIDE TEMPORARY LIGHTING FOR WAREHOUSE SPACE. COORDINATE WITH OWNER FOR NUMBER AND LOCATIONS. FIXTURES TO BE RETURNED TO OWNER AFTER FUTURE TENANT BUILD OUT.
 - 4 EXISTING/NEW UTILITY SERVICE #2. SEE ELECTRICAL RISER DIAGRAM, SHEET E-4.1. VERIFY WITH UTILITY TO RESTORE SERVICE TO SITE AND IF EXISTING TRANSFORMER CAN BE REUSED.

POWER AND LIGHTING PLAN — WAREHOUSE #3, #4, & #5
SCALE: 1/8" = 1'-0"

ISSUE / REVISIONS
0 03/23/20 ISSUE FOR PERMIT AND CONSTRUCTION

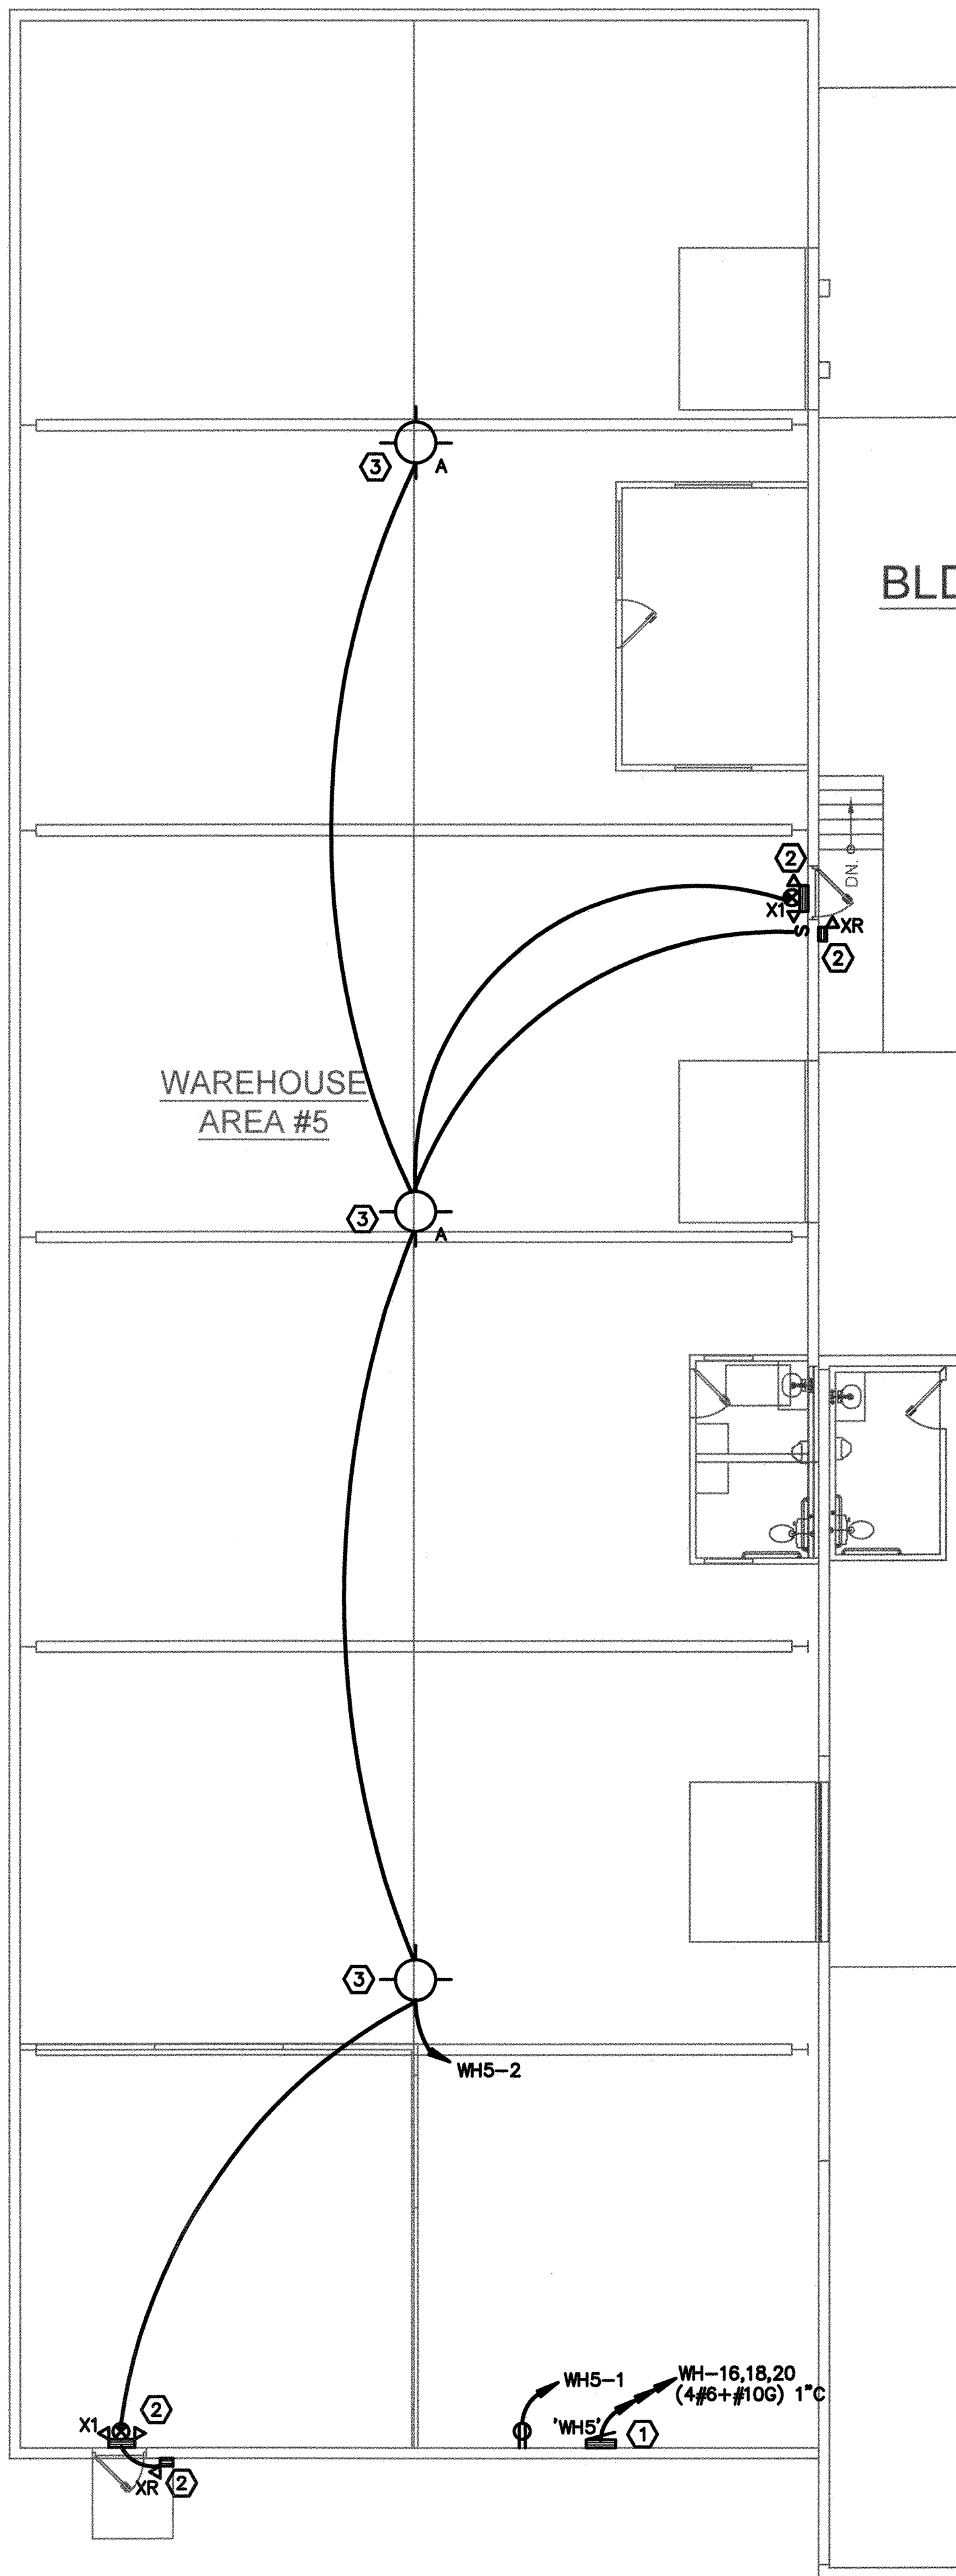

RENOVATIONS TO
WATSON STREET WAREHOUSE
6667 WATSON STREET
UNION CITY, GA

Kent Ahrenhold
Architect
6851 ROSWELL RD. NE, NO K-22
ATLANTA, GEORGIA 30328
PHONE: 404-374-6985

DRAWN BY
DAM
CHECKED BY
JAN
DATE
28 Feb. 2022
DRAWING TITLE
POWER &
LIGHTING PLANS
WAREHOUSE #3,
#4 & #5
SHEET NO.

E-2.2

**C S CORNERSTONE
DESIGN SERVICES**
Mechanical | Electrical | Plumbing | HVAC | Fire Safety
3740 DAYVINC CT, SUITE 100 PEACHTREE CORNERS, GA 30092
770.717.0040 www.csdesignservices.net

RELEASED FOR
CONSTRUCTION